



PROJECT: SUPPLY AND DELIVERY OF LABOR AND MATERIALS FOR THE REPAIR/RENOVATION OF THE CED BUILDING

LOCATION: DOST Compound, Gen. Santos Ave., Bicutan, Taguig City

OWNER: Industrial Technology Development Institute (ITDI)

SUBJECT: BID BULLETIN NO. 1

Date: October 22, 2019

This Bid Bulletin No. 1 is being issued to Bidders for their information and guidance in the preparation of their bids and shall be taken into consideration in their proposal. This bid bulletin will form part of the contract for this project.

1. Governing Rules:

Bidding and contract award for the above project shall be governed by the Revised Implementing Rules and Regulations of RA 9184 and the Philippine Bidding Documents (PBD), Fifth Edition, October 2016. Any discrepancy between the General Conditions and RA 9184, R.A 9184 shall prevail.

2. Marking and Sealing of Bids

- a. Contents of sealed envelope marked **"ORIGINAL BID"**
Sealed Envelope 1 marked **"Original – Eligibility & Technical Proposal"**
Sealed Envelope 2 marked **"Original – Financial Proposal"**
- b. Contents of sealed envelope marked **"COPY NO. 1"**
Sealed Envelope 1 marked **"Copy No. 1 – Eligibility & Technical Proposal"**
Sealed Envelope 2 marked **"Copy No. 1 – Financial Proposal"**
- c. Contents of sealed envelope marked **"COPY NO. 2"**
Sealed Envelope 1 marked **"Copy No. 2 – Eligibility & Technical Proposal"**
Sealed Envelope 2 marked **"Copy No. 2 – Financial Proposal"**
- d. The sealed outer envelopes marked **"ORIGINAL BID", "COPY NO. 1" and "COPY NO. 2"** shall be enclosed in one single envelope/package.

Our Business is Industry

Membership:

- General Conference on Weights and Measures (CGPM)
- Asia Pacific Metrology Programme (APMP)
- Asia Pacific Legal Metrology Forum (APLMF)

- e. All envelopes shall contain the following:

PROJECT: (NAME OF THE PROJECT) (NAME AND ADDRESS OF BIDDER IN CAPITAL LETTER) TO: THE INDUSTRIAL TECHNOLOGY DEVELOPMENT INSTITUTE (ITDI) NORBERTO G. AMBAGAN, PhD ITDI-BAC CHAIRPERSON, SUB.COM. FOR INFRASTRUCTURE Metrology Building, DOST Compound Bicutan, Taguig City DO NOT OPEN BEFORE: Scheduled date & time of opening of bids

3. Items to be considered in the preparation of Bid

3.1 Bid Proposal shall be in Philippine currency.

3.2 The bid shall be signed on each and every page by the duly authorized signatory of the bidder. Items with erasures on the bid should bear the initials of the authorized signatory.

3.3 Bidders shall submit a Bid Securing Declaration or at least one (1) other Bid Security, the amount of which shall not be less than the percentage of the ABC in accordance with the following schedule:

Forms of bid Security	Amount of Bid Security (Not less than to Percentage of the ABC)
a) Cash or Cashier's/manager's check issued by a Universal or Commercial Bank	Two percent (2%)
b) Bank draft/guarantee or irrevocable letter of credit issued by a Universal or commercial Bank: Provided, however, that it shall be confirmed or authenticated by a Universal or Commercial Bank, if issued by a foreign bank	
c) Surety bond callable upon demand issued by a surety or insurance company duly certified by the Insurance Commission as authorized to issue such security	Five percent (5%)

Our Business is Industry

Membership:

- General Conference on Weights and Measures (CGPM)
- Asia Pacific Metrology Programme (APMP)
- Asia Pacific Legal Metrology Forum (APLMF)

- 3.4 Bid bonds should be posted in favor of the **Industrial Technology Development Institute**. If other than the GSIS, the bid bond should be accompanied with a certificate of accreditation from the Insurance Commission. Bid bonds should be submitted with original receipts of payments. Bid security shall be Callable on Demand with a validity period of 120 calendar days.
- 3.5 To guarantee the faithful performance by the winning bidder of its obligations under the contract, it shall post performance security taken from the categories below the amount of which shall be not be less than the percentage of the total contract price in accordance with the following schedule:

Forms of Performance Security	Amount of Performance Security Not less than the Percentage of the Total Contract Price)
a) Cash or Cashier's/manager's check issued by a Universal or Commercial Bank b) Bank draft/guarantee or irrevocable letter of credit issued by a Universal or commercial Bank: Provided, however, that it shall be confirmed or authenticated by a Universal or Commercial Bank, if issued by a foreign bank	Goods and Consulting Services - Five Percent (5%)
c) Surety bond callable upon demand issued by a surety or insurance company duly certified by the Insurance Commission as authorized to issue such security	Thirty percent (30%)

4. Submission of Bids – October 29, 2019, 8:30A.M. to 9:00A.M.

Late bids shall not be accepted

Opening of Bids – October 29, 2019, 9:01A.M.

5. Minimum Work Experience for the following project staff:

- Project Manager – A licensed Civil Engineer or Architect with 7 to 10years experience as project manager for similar projects;
- Construction Manager - with experience as project manager with 7 to 10experience for similar projects;
- Site Engineer - A licensed Engineer with 7 to 10 years experience as Site Engineer; and
- Site Architect - A licensed Architect with 7 to 10years experience as Site Architect of similar projects.

Our Business is Industry

Membership:

- General Conference on Weights and Measures (CGPM)
- Asia Pacific Metrology Programme (APMP)
- Asia Pacific Legal Metrology Forum (APLMF)

6. The plans E1 of 3, E2 of 3 and E3 of 3 for the UPGRADING OF POWER PROVISION FOR STORAGE AND EQUIPMENT, of which E3 of 3 has a clouded part (which are the additional scope of work) will be attached herewith. Moreover, the plan for the **Steam Line** will also be attached herewith. However, the bidder should undertake detailed measurements at the site for the actual quantities and specifications of the scope's components.

Based on the Blank Bill of Quantities (BOQ), the Item PUMBING AND SANITARY WORKS: HDPE and PPR FITTINGS, has no quantity since it is one (1) LOT. The As-Built Plans for the Plumbing, Mechanical and Fire-Protection Works will be attached herewith as reference for the estimation of the quantities and specifications. Actual measurements at the site is advised.

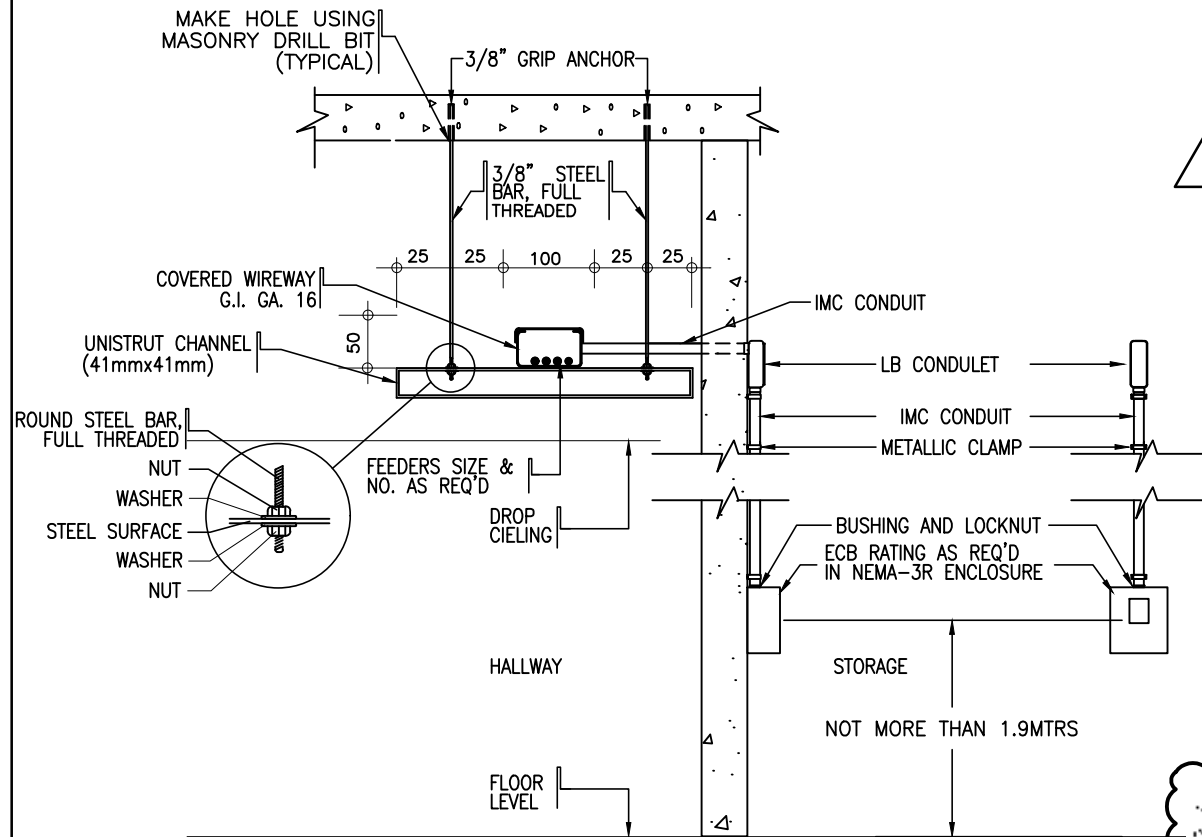
Issued by:


ENGR. JOSEPH L. HERRERA
ITDI-BAC Co-Chairperson, Sub. Com. for Infrastructure


Our Business is Industry

Membership:

- General Conference on Weights and Measures (CGPM)
- Asia Pacific Metrology Programme (APMP)
- Asia Pacific Legal Metrology Forum (APLMF)



DETAILS AND SECTION

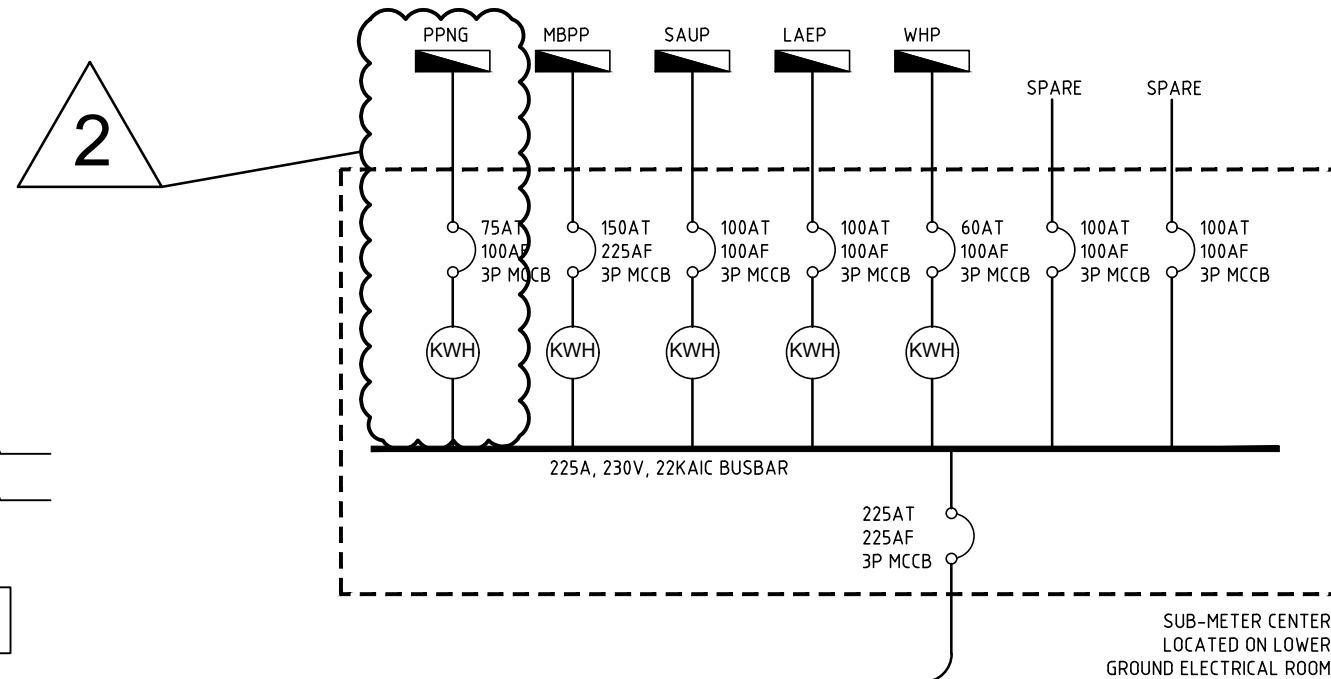

NO.	DESCRIPTION	PPNG	MBPP	SAUP	LAEP	WHP	SPARE	SPARE
1	75AT 100AF 3P MCCB	1	1	1	1	1	1	1
2	225AT 225AF 3P MCCB	1	1	1	1	1	1	1
3	225A, 230V, 22KAIC BUSBAR	1	1	1	1	1	1	1
4	75AT 100AF 3P MCCB	1	1	1	1	1	1	1
5	225AT 225AF 3P MCCB	1	1	1	1	1	1	1
6	225A, 230V, 22KAIC BUSBAR	1	1	1	1	1	1	1
7	75AT 100AF 3P MCCB	1	1	1	1	1	1	1
8	225AT 225AF 3P MCCB	1	1	1	1	1	1	1
9	225A, 230V, 22KAIC BUSBAR	1	1	1	1	1	1	1
10	75AT 100AF 3P MCCB	1	1	1	1	1	1	1
11	225AT 225AF 3P MCCB	1	1	1	1	1	1	1
12	225A, 230V, 22KAIC BUSBAR	1	1	1	1	1	1	1
13	75AT 100AF 3P MCCB	1	1	1	1	1	1	1
14	225AT 225AF 3P MCCB	1	1	1	1	1	1	1
15	225A, 230V, 22KAIC BUSBAR	1	1	1	1	1	1	1
16	75AT 100AF 3P MCCB	1	1	1	1	1	1	1
17	225AT 225AF 3P MCCB	1	1	1	1	1	1	1
18	225A, 230V, 22KAIC BUSBAR	1	1	1	1	1	1	1
19	75AT 100AF 3P MCCB	1	1	1	1	1	1	1
20	225AT 225AF 3P MCCB	1	1	1	1	1	1	1
21	225A, 230V, 22KAIC BUSBAR	1	1	1	1	1	1	1
22	75AT 100AF 3P MCCB	1	1	1	1	1	1	1
23	225AT 225AF 3P MCCB	1	1	1	1	1	1	1
24	225A, 230V, 22KAIC BUSBAR	1	1	1	1	1	1	1
25	75AT 100AF 3P MCCB	1	1	1	1	1	1	1
26	225AT 225AF 3P MCCB	1	1	1	1	1	1	1
27	225A, 230V, 22KAIC BUSBAR	1	1	1	1	1	1	1
28	75AT 100AF 3P MCCB	1	1	1	1	1	1	1
29	225AT 225AF 3P MCCB	1	1	1	1	1	1	1
30	225A, 230V, 22KAIC BUSBAR	1	1	1	1	1	1	1

NO.	DESCRIPTION	PPNG	MBPP	SAUP	LAEP	WHP	SPARE	SPARE
1	75AT 100AF 3P MCCB	1	1	1	1	1	1	1
2	225AT 225AF 3P MCCB	1	1	1	1	1	1	1
3	225A, 230V, 22KAIC BUSBAR	1	1	1	1	1	1	1
4	75AT 100AF 3P MCCB	1	1	1	1	1	1	1
5	225AT 225AF 3P MCCB	1	1	1	1	1	1	1
6	225A, 230V, 22KAIC BUSBAR	1	1	1	1	1	1	1
7	75AT 100AF 3P MCCB	1	1	1	1	1	1	1
8	225AT 225AF 3P MCCB	1	1	1	1	1	1	1
9	225A, 230V, 22KAIC BUSBAR	1	1	1	1	1	1	1
10	75AT 100AF 3P MCCB	1	1	1	1	1	1	1
11	225AT 225AF 3P MCCB	1	1	1	1	1	1	1
12	225A, 230V, 22KAIC BUSBAR	1	1	1	1	1	1	1
13	75AT 100AF 3P MCCB	1	1	1	1	1	1	1
14	225AT 225AF 3P MCCB	1	1	1	1	1	1	1
15	225A, 230V, 22KAIC BUSBAR	1	1	1	1	1	1	1
16	75AT 100AF 3P MCCB	1	1	1	1	1	1	1
17	225AT 225AF 3P MCCB	1	1	1	1	1	1	1
18	225A, 230V, 22KAIC BUSBAR	1	1	1	1	1	1	1
19	75AT 100AF 3P MCCB	1	1	1	1	1	1	1
20	225AT 225AF 3P MCCB	1	1	1	1	1	1	1
21	225A, 230V, 22KAIC BUSBAR	1	1	1	1	1	1	1
22	75AT 100AF 3P MCCB	1	1	1	1	1	1	1
23	225AT 225AF 3P MCCB	1	1	1	1	1	1	1
24	225A, 230V, 22KAIC BUSBAR	1	1	1	1	1	1	1
25	75AT 100AF 3P MCCB	1	1	1	1	1	1	1
26	225AT 225AF 3P MCCB	1	1	1	1	1	1	1
27	225A, 230V, 22KAIC BUSBAR	1	1	1	1	1	1	1
28	75AT 100AF 3P MCCB	1	1	1	1	1	1	1
29	225AT 225AF 3P MCCB	1	1	1	1	1	1	1
30	225A, 230V, 22KAIC BUSBAR	1	1	1	1	1	1	1

PART OF EXISTING ONE-LINE DIAGRAM

1
E-02
SCALE

NTS

REVISION DETAILS

2 ADDED PANEL "PPNG" and KWH-METER

EXISTING PANEL SCHEDULE

2
E-02
SCALE

NTS

ENRIQUE O. OLONAN *enp* & ASSOCIATES
HENRY STEVE R. OLONAN *enp* - ASSOCIATE
KIM V. OLONAN - INTERIOR DESIGNER
ARCHITECTS ENGINEERS CONSULTANTS

SUITE 305 XAVIERVILLE SQUARE CONDOMINIUM NO. 38 XAVIERVILLE AVE.,
LOYOLA HEIGHTS QUEZON CITY 1108
TEL. NOS.: 426 7009; 426 3002 TO 04 FAX NOS.: 927 0608; 426 7214

ENGINEER:
ENGR. MANUEL V. PANIS
PROFESSIONAL ELECTRICAL ENGINEER
PRC No.: 1210 VALIDITY: 10-13-2020
PTR No.: 6601230 DATE: 01-03-2019
TIN No.: 132-466-222 DATE ISSUED: QUEZON CITY

REPUBLIC ACT 9266
DRAWINGS AND SPECIFICATIONS AND OTHER CONTRACT
DOCUMENTS DULY SIGNED, STAMPED OR SEALED, AS
INSTRUMENTS OF SERVICE, ARE THE INTELLECTUAL
PROPERTY AND DOCUMENT OF THE ARCHITECT.
WHETHER THE OBJECT FOR WHICH THEY ARE MADE IS
EXECUTED OR NOT, IT SHALL BE UNLAWFUL FOR ANY
PERSON TO DUPLICATE OR TO MAKE COPIES OF SAID
DOCUMENTS FOR USE IN THE REPETITION OF AND FOR
OTHER PROJECTS OR BUILDINGS, WHETHER EXECUTED
PARTY OR IN WHOLE, WITHOUT THE WRITTEN CONSENT
OF ARCHITECT OR AUTHOR OF SAID DOCUMENT.

PROJECT:
CONSULTING SERVICES FOR THE EXPANSION AND
EXTENSION RENOVATION OF THE EXISTING TSD FOR
THE MODULAR MULTI-INDUSTRY INNOVATION CENTER
AND EXECUTIVE OFFICES
LOCATION: BICUTAN, TAGUIG

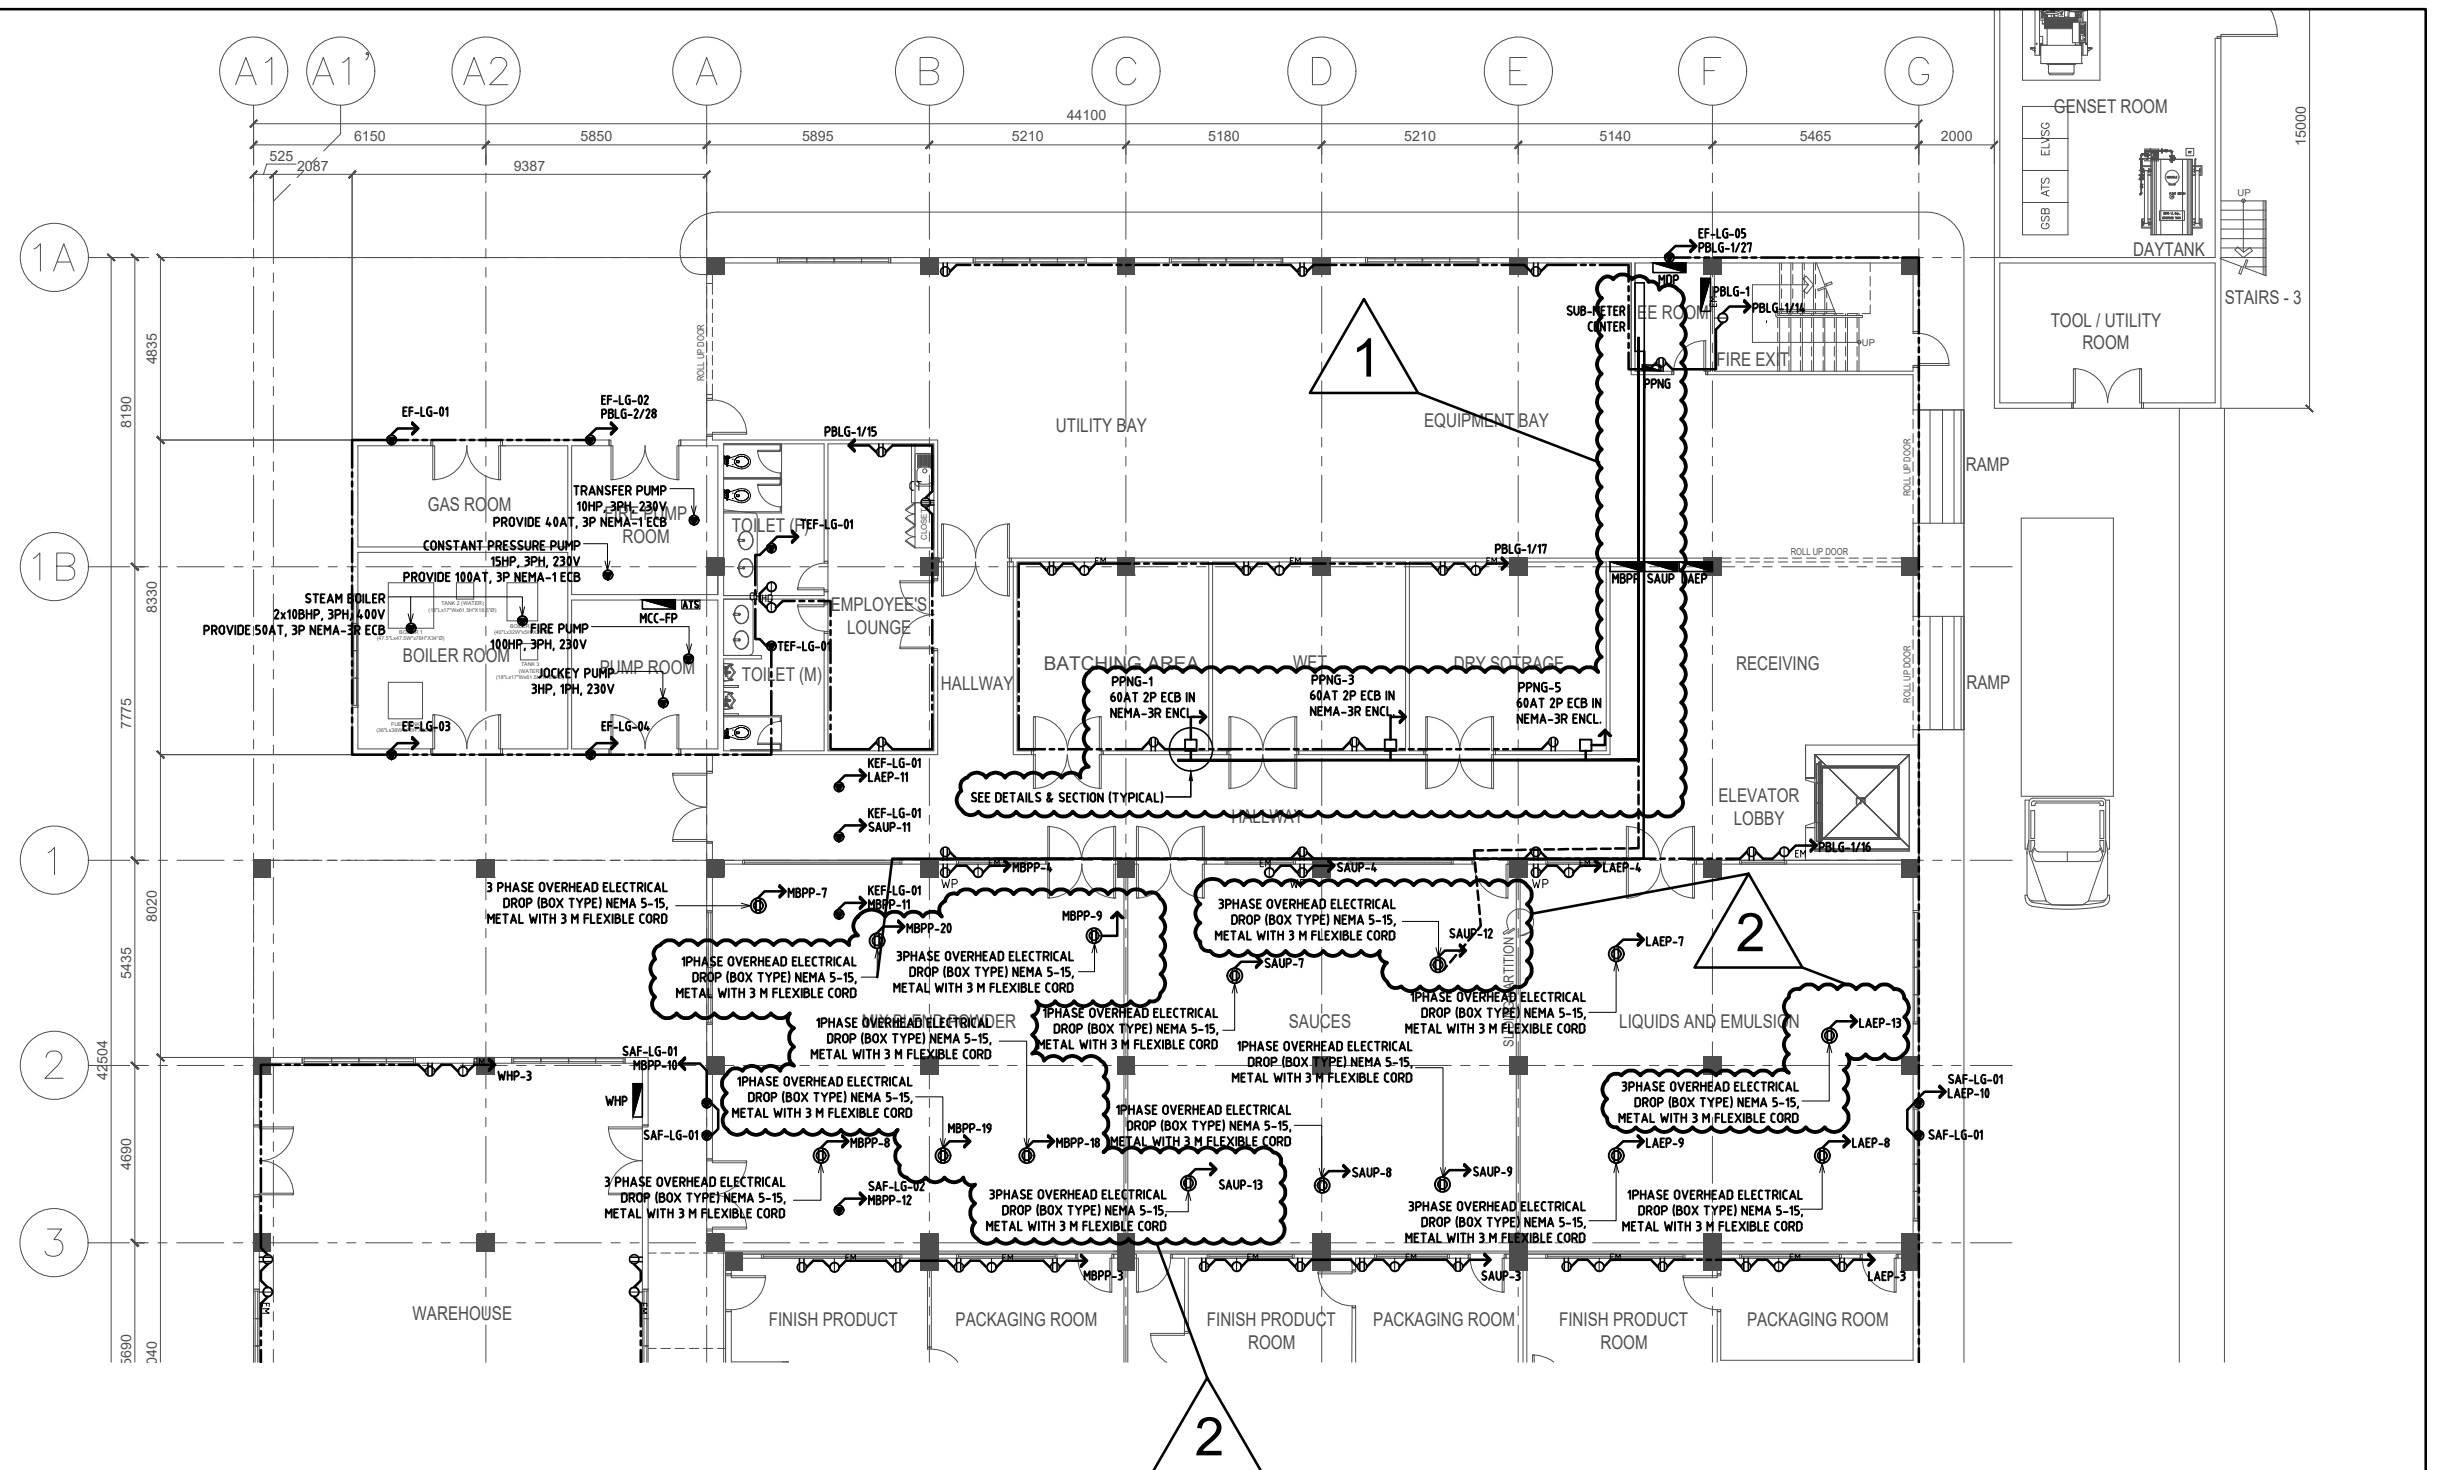
DESIGNED FOR:
DOST-ITDI

RECOMMENDING APPROVAL:
REYNALDO L. ESGUERRA
Co-Chairman, Technical Advisory Committee

APPROVED BY:
ANNABELLE V. BRIONES, Ph.D.
OIC, Office of the Director
Head of Procuring Entity

SHEET CONTENTS:
DETAILS; EXISTING PANEL
SCHEDULE; PART OF
EXISTING ONE-LINE DIAGRAM

E
2 3



UPGRADING OF LOWER GROUND FLOOR EQUIPMENTS POWER LAYOUT

1
E-01

SCALE

1:100 MTS.

REVISION DETAILS

- 1. ADDED 60AT 2P ECB FOR HIGHER RATING EQUIPMENT/S
- 2. ADDED PANEL "PPNG"
- 3. ADDED CABLE TRAY
- 4. ADDED OVERHEAD ELECTRICAL DROP FOR EQUIPMENTS PROVISION
- 5. REVISED CIRCUIT DESIGNATION AND ADDED INFORMATION DETAILS

ENRIQUE O. OLONAN *Inc.* & ASSOCIATES
HENRY STEVE R. OLONAN *Inc.* - ASSOCIATE
KIM V. OLONAN - INTERIOR DESIGNER
ARCHITECTS ENGINEERS CONSULTANTS

SUITE 305 XAVIERVILLE SQUARE CONDOMINIUM NO. 38 XAVIERVILLE AVE.,
LOYOLA HEIGHTS QUEZON CITY 1108
TEL. NOS.: 426 7009; 426 5002 TO 04 FAX NOS.: 927 0608; 426 7214

ENGINEER:

ENGR. MANUEL V. PANIS
PROFESSIONAL ELECTRICAL ENGINEER

PRC NO.: 1210 VALIDITY: 10-13-2020
PTR No.: 6601230 DATE: 01-03-2019
TIN No.: 132-466-222 DATE ISSUED: QUEZON CITY

REPUBLIC ACT 9266

DRAWINGS AND SPECIFICATIONS AND OTHER CONTRACT DOCUMENTS DULY SIGNED, STAMPED OR SEALED, AS INSTRUMENTS OF SERVICE, ARE THE INTELLECTUAL PROPERTY AND DOCUMENT OF THE ARCHITECT, WHETHER THE OBJECT FOR WHICH THEY ARE MADE IS EXECUTED OR NOT. IT SHALL BE UNLAWFUL FOR ANY PERSON TO DUPLICATE OR TO MAKE COPIES OF SAID DOCUMENTS FOR USE IN THE REPETITION OF AND FOR OTHER PROJECTS OR BUILDINGS, WITHOUT THE WRITTEN CONSENT OF ARCHITECT OR AUTHOR OF SAID DOCUMENT.

PROJECT:

CONSULTING SERVICES FOR THE EXPANSION AND EXTENSION RENOVATION OF THE EXISTING TSD FOR THE MODULAR MULTI-INDUSTRY INNOVATION CENTER AND EXECUTIVE OFFICES

LOCATION: BICUTAN, TAGUIG

DESIGNED FOR:



RECOMMENDING APPROVAL:

REYNALDO L. ESGUERRA
Co-Chairman, Technical Advisory Committee

APPROVED BY:


ANNABELLE V. BRIONES, Ph.D.
OIC, Office of the Director
Head of Procuring Entity

SHEET CONTENTS:


UPGRADING OF LOWER GROUND FLOOR EQUIPMENTS POWER LAYOUT

SHEET NO. /

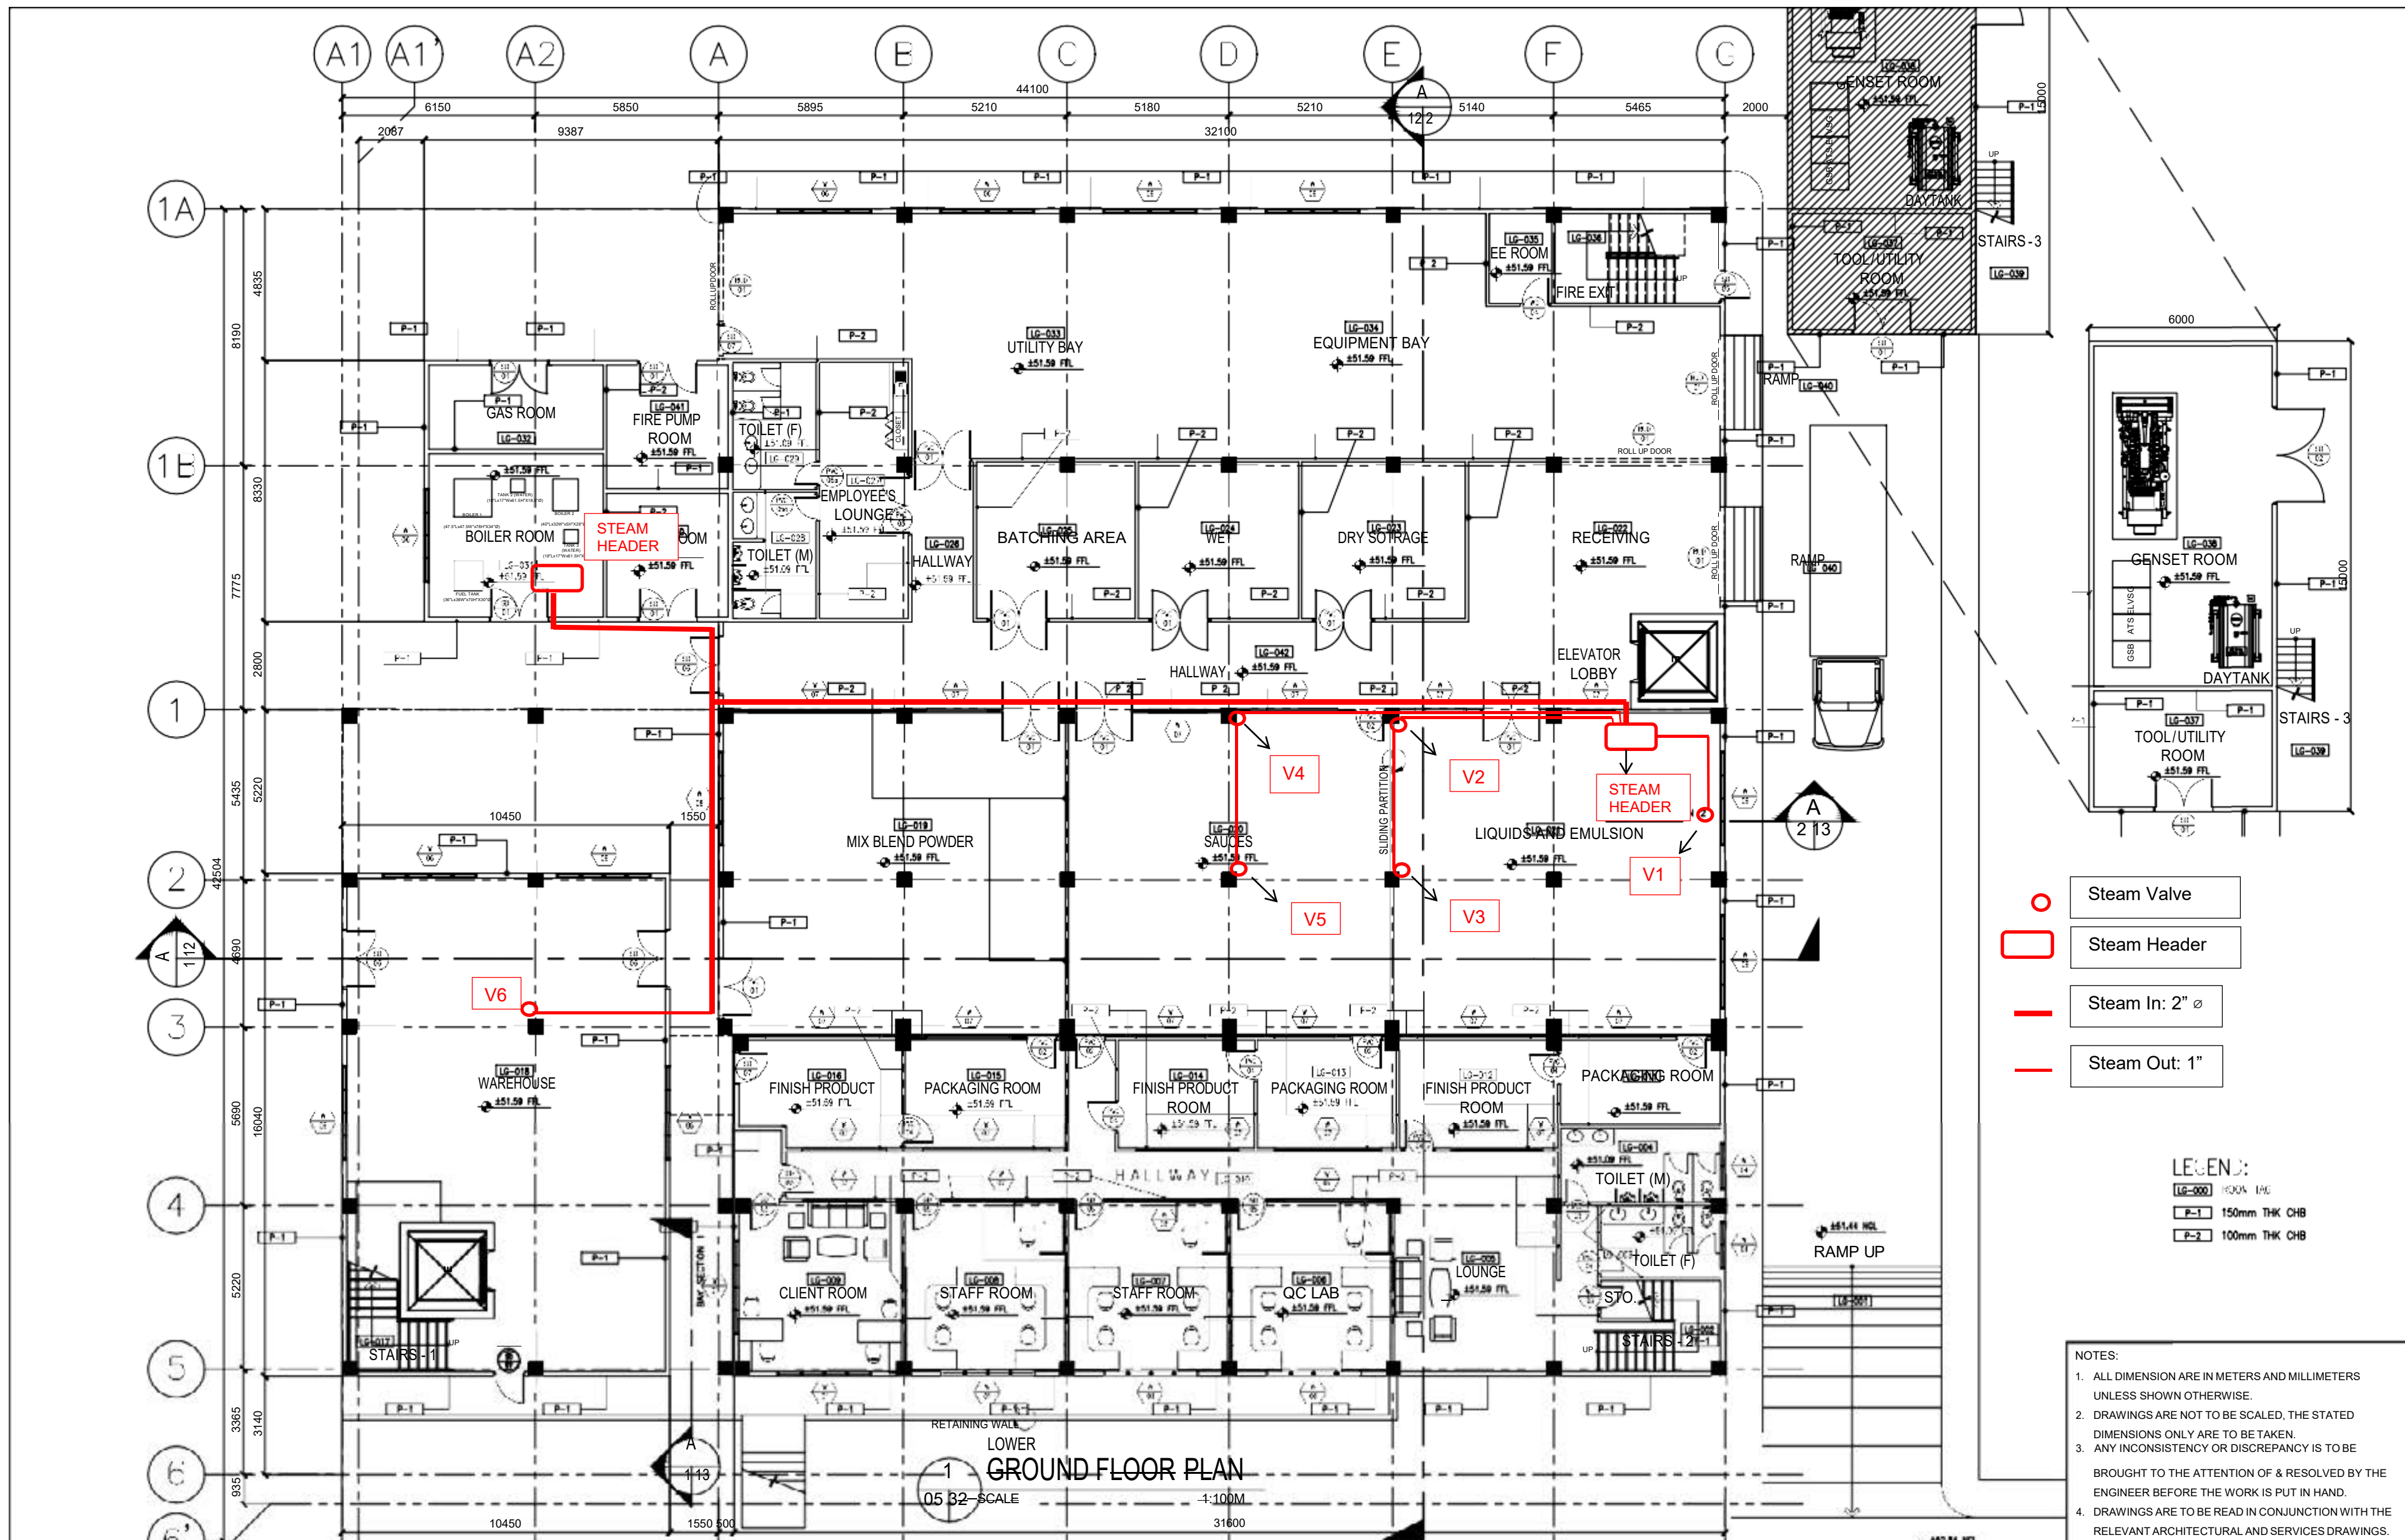E
1 / 3





 ENRIQUE O. OLANON & ASSOCIATES HENRY STEVE R. OLANON <i>enr</i> ASSOCIATE KIM V. OLANON <i>interior</i> DESIGNER ARCHITECTS INTERIORS CONSULTANTS	ARCHITECT: HENRY STEVE R. OLANON ARCHITECT IAPOA No.: 11494-163364-070416 REG No.: 17726 PTR No.: 4028542 REG DATE: 02-12-2003 REG VALID: 04-27-2018 TIN No.: 218-564-675 ISSUED: QUEZON CITY	REPUBLIC ACT 9266 DRAWINGS AND SPECIFICATIONS AND OTHER CONTRACT DOCUMENTS DULY SIGNED, STAMPED OR SEALED, AS INSTRUMENTS OF SERVICE, ARE THE INTELLECTUAL PROPERTY AND DOCUMENT OF THE ARCHITECT, WHETHER THE OBJECT FOR WHICH THEY ARE MADE IS EXECUTED OR NOT. IT SHALL BE UNLAWFUL FOR ANY PERSON TO DUPLICATE OR TO MAKE COPIES OF SAID DOCUMENTS FOR USE IN THE REPEITION OF AND FOR OTHER PROJECTS OR BUILDINGS, WHETHER EXECUTED PARTY OR IN WHOLE, WITHOUT THE WRITTEN CONSENT OF ARCHITECT OR AUTHOR OF SAID DOCUMENT.	PROJECT: CONSULTING SERVICES FOR THE EXPANSION AND EXTENSION RENOVATION OF THE EXISTING TSD FOR THE MODULAR MULTI-INDUSTRY INNOVATION CENTER AND EXECUTIVE OFFICES LOCATION: BICUTAN, TA	DESIGNED FOR:  DOST-ITDI	RECOMMENDING APPROVAL: ANNABELLE V. BRIONES, Ph.D. Chairman of TAC for Infrastructure, ITDI-DOST	APPROVED BY: MARIA PATRICIA V. AZANZA, Ph.D. Director, ITDI-DOST	SHEET CONTENTS: GROUND FLOOR PLAN	SHEET NO. / A 05/32
---	---	---	--	---	--	--	--	-------------------------------

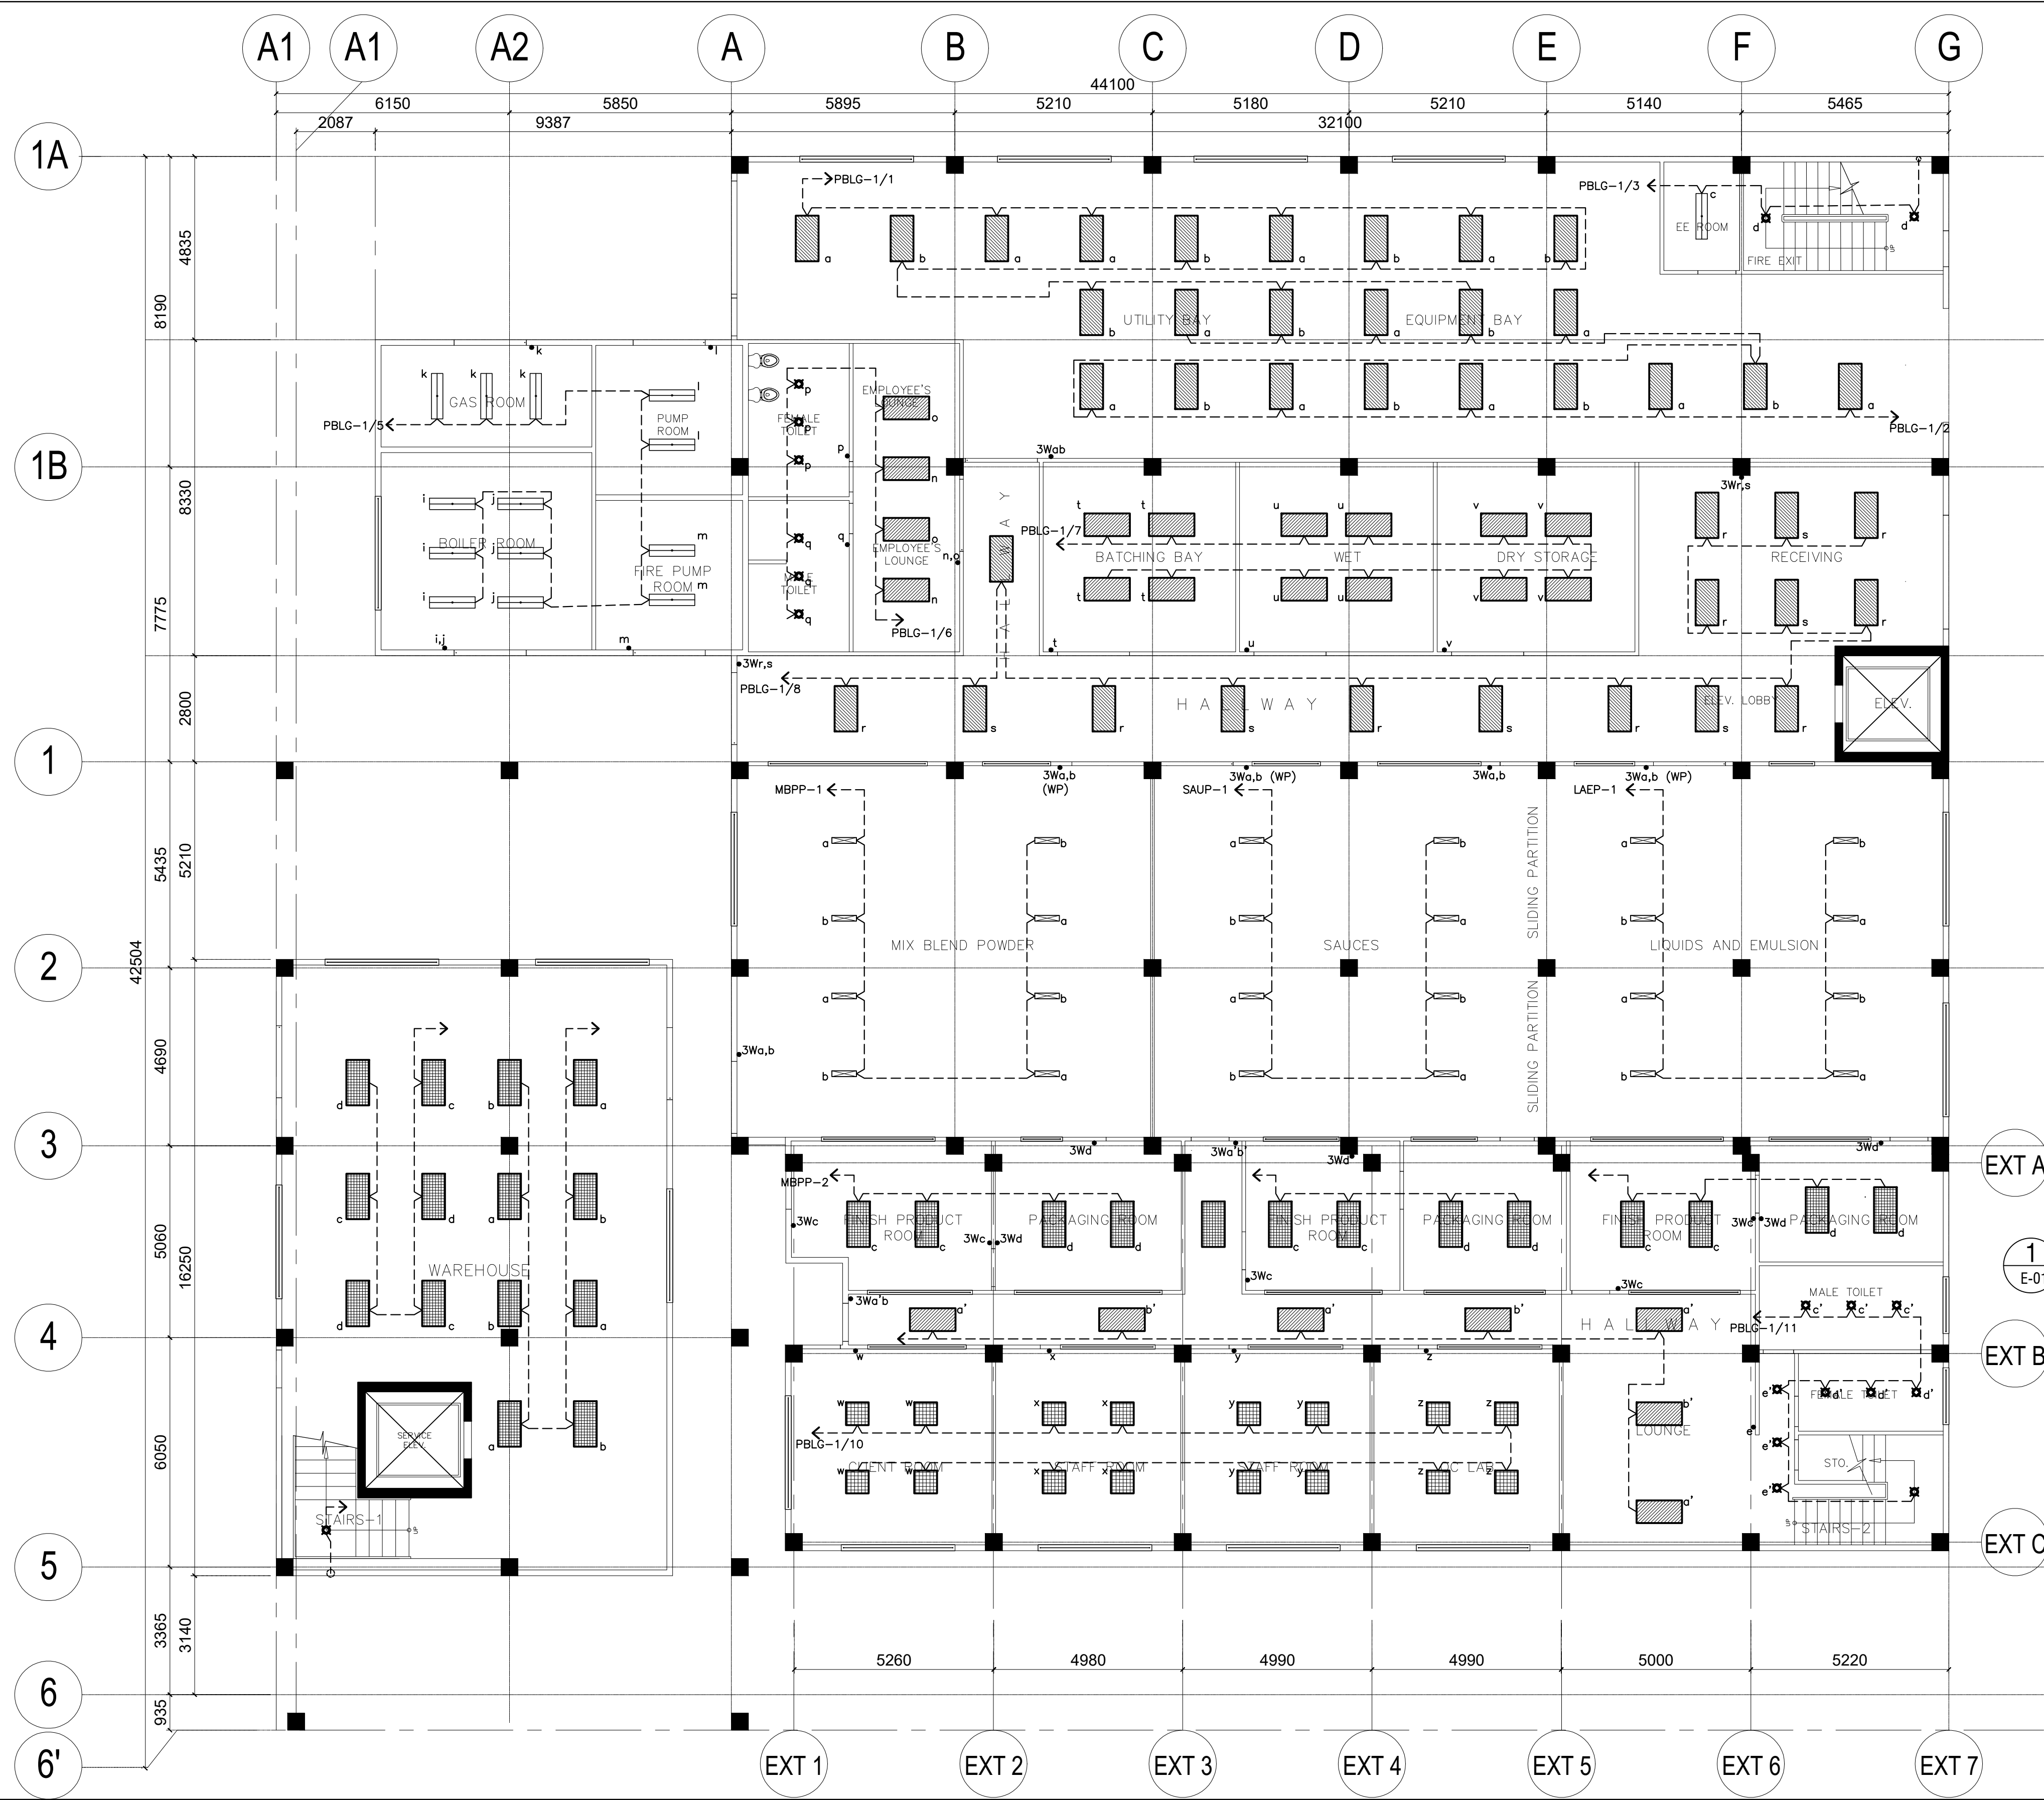


**LOWER GROUND FLOOR
LIGHTING LAYOUT**
1
E-01
SCALE 1:200M.

- LEGEND
- 60X120 TROFFER TYPE LUMINAIRE FLOURESCENT
 - 60X120 TROFFER TYPE LUMINAIRE W/ PRISMATIC DIFFUSER FLOURESCENT
 - DOWNLIGHT (COMPACT FLOURESCENT)
 - TROFFER TYPE LUMINAIRE FLOURESCENT
 - MOISTURE/DUSTPROOF LUMINAIRE LINEAR FLOURESCENT

CONTRACTOR	
	
ELECTRICAL ENGINEER	
ARMANDO S. CALAGUAS	
PRC REG. NO. 2375	DATE: 01 / 03 / 19
PR. 7323769	PLACE: QUEZON CITY
OWNER	
	
PROJECT NAME	
EXPANSION AND EXTENSION RENOVATION OF THE EXISTING TSD FOR THE MODULAR MULTI-INDUSTRY INNOVATION CENTER AND EXECUTIVE OFFICES LOCATION: BICUTAN, TAGUIG	
APPROVED	
ANNABELLE V. BRIONES OIC-OFFICE OF THE DIRECTOR	
CONCURRED	
SHEET CONTENTS	
LOWER GROUND FLOORPLAN LIGHTING LAYOUT	
SHEET NUMBER	
E	01
AS-BUILT	

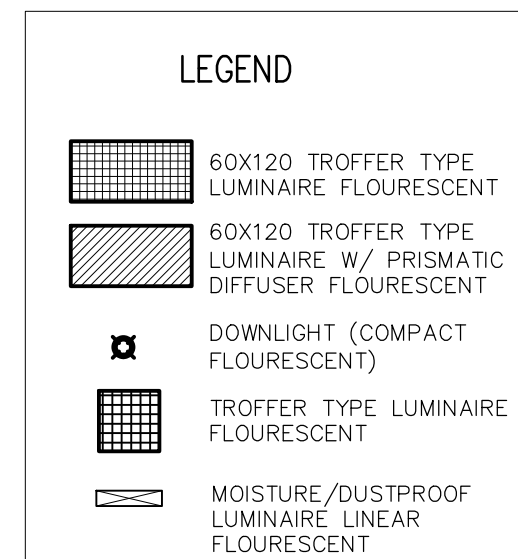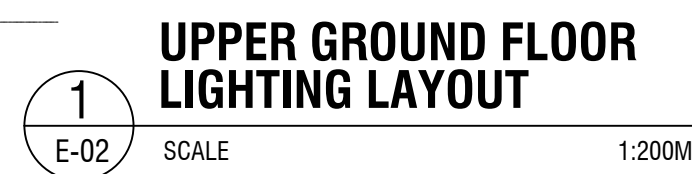


CONTRACTOR	
 OCM STEEL CORPORATION NO. 34 MONTECITO CIRCLE, MARIKINA, LAKI DRIVE, PARRANG, QUEZON CITY TEL. 7874, 882-4201 / 882-6206 FAX NO. 787-2722	
ELECTRICAL ENGINEER	
ARMANDO S. CALAGUAS	
PRC. REG. NO.: 2375 PTR. 7323769 TIN: 146-594-412	DATE: 01 / 03 / 19 PLACE: QUEZON CITY
OWNER	
 DOST-ITDI	
PROJECT NAME	
EXPANSION AND EXTENSION RENOVATION OF THE EXISTING TSD FOR THE MODULAR MULTI-INDUSTRY INNOVATION CENTER AND EXECUTIVE OFFICES LOCATION: BICUTAN, TAGUIG	
APPROVED	
ANNABELLE V. BRIONES OIC-OFFICE OF THE DIRECTOR	
CONCURRED	
SHEET CONTENTS	
UPPER GROUND FLOORPLAN LIGHTING LAYOUT	
SHEET NUMBER	
E	02
AS-BUILT	

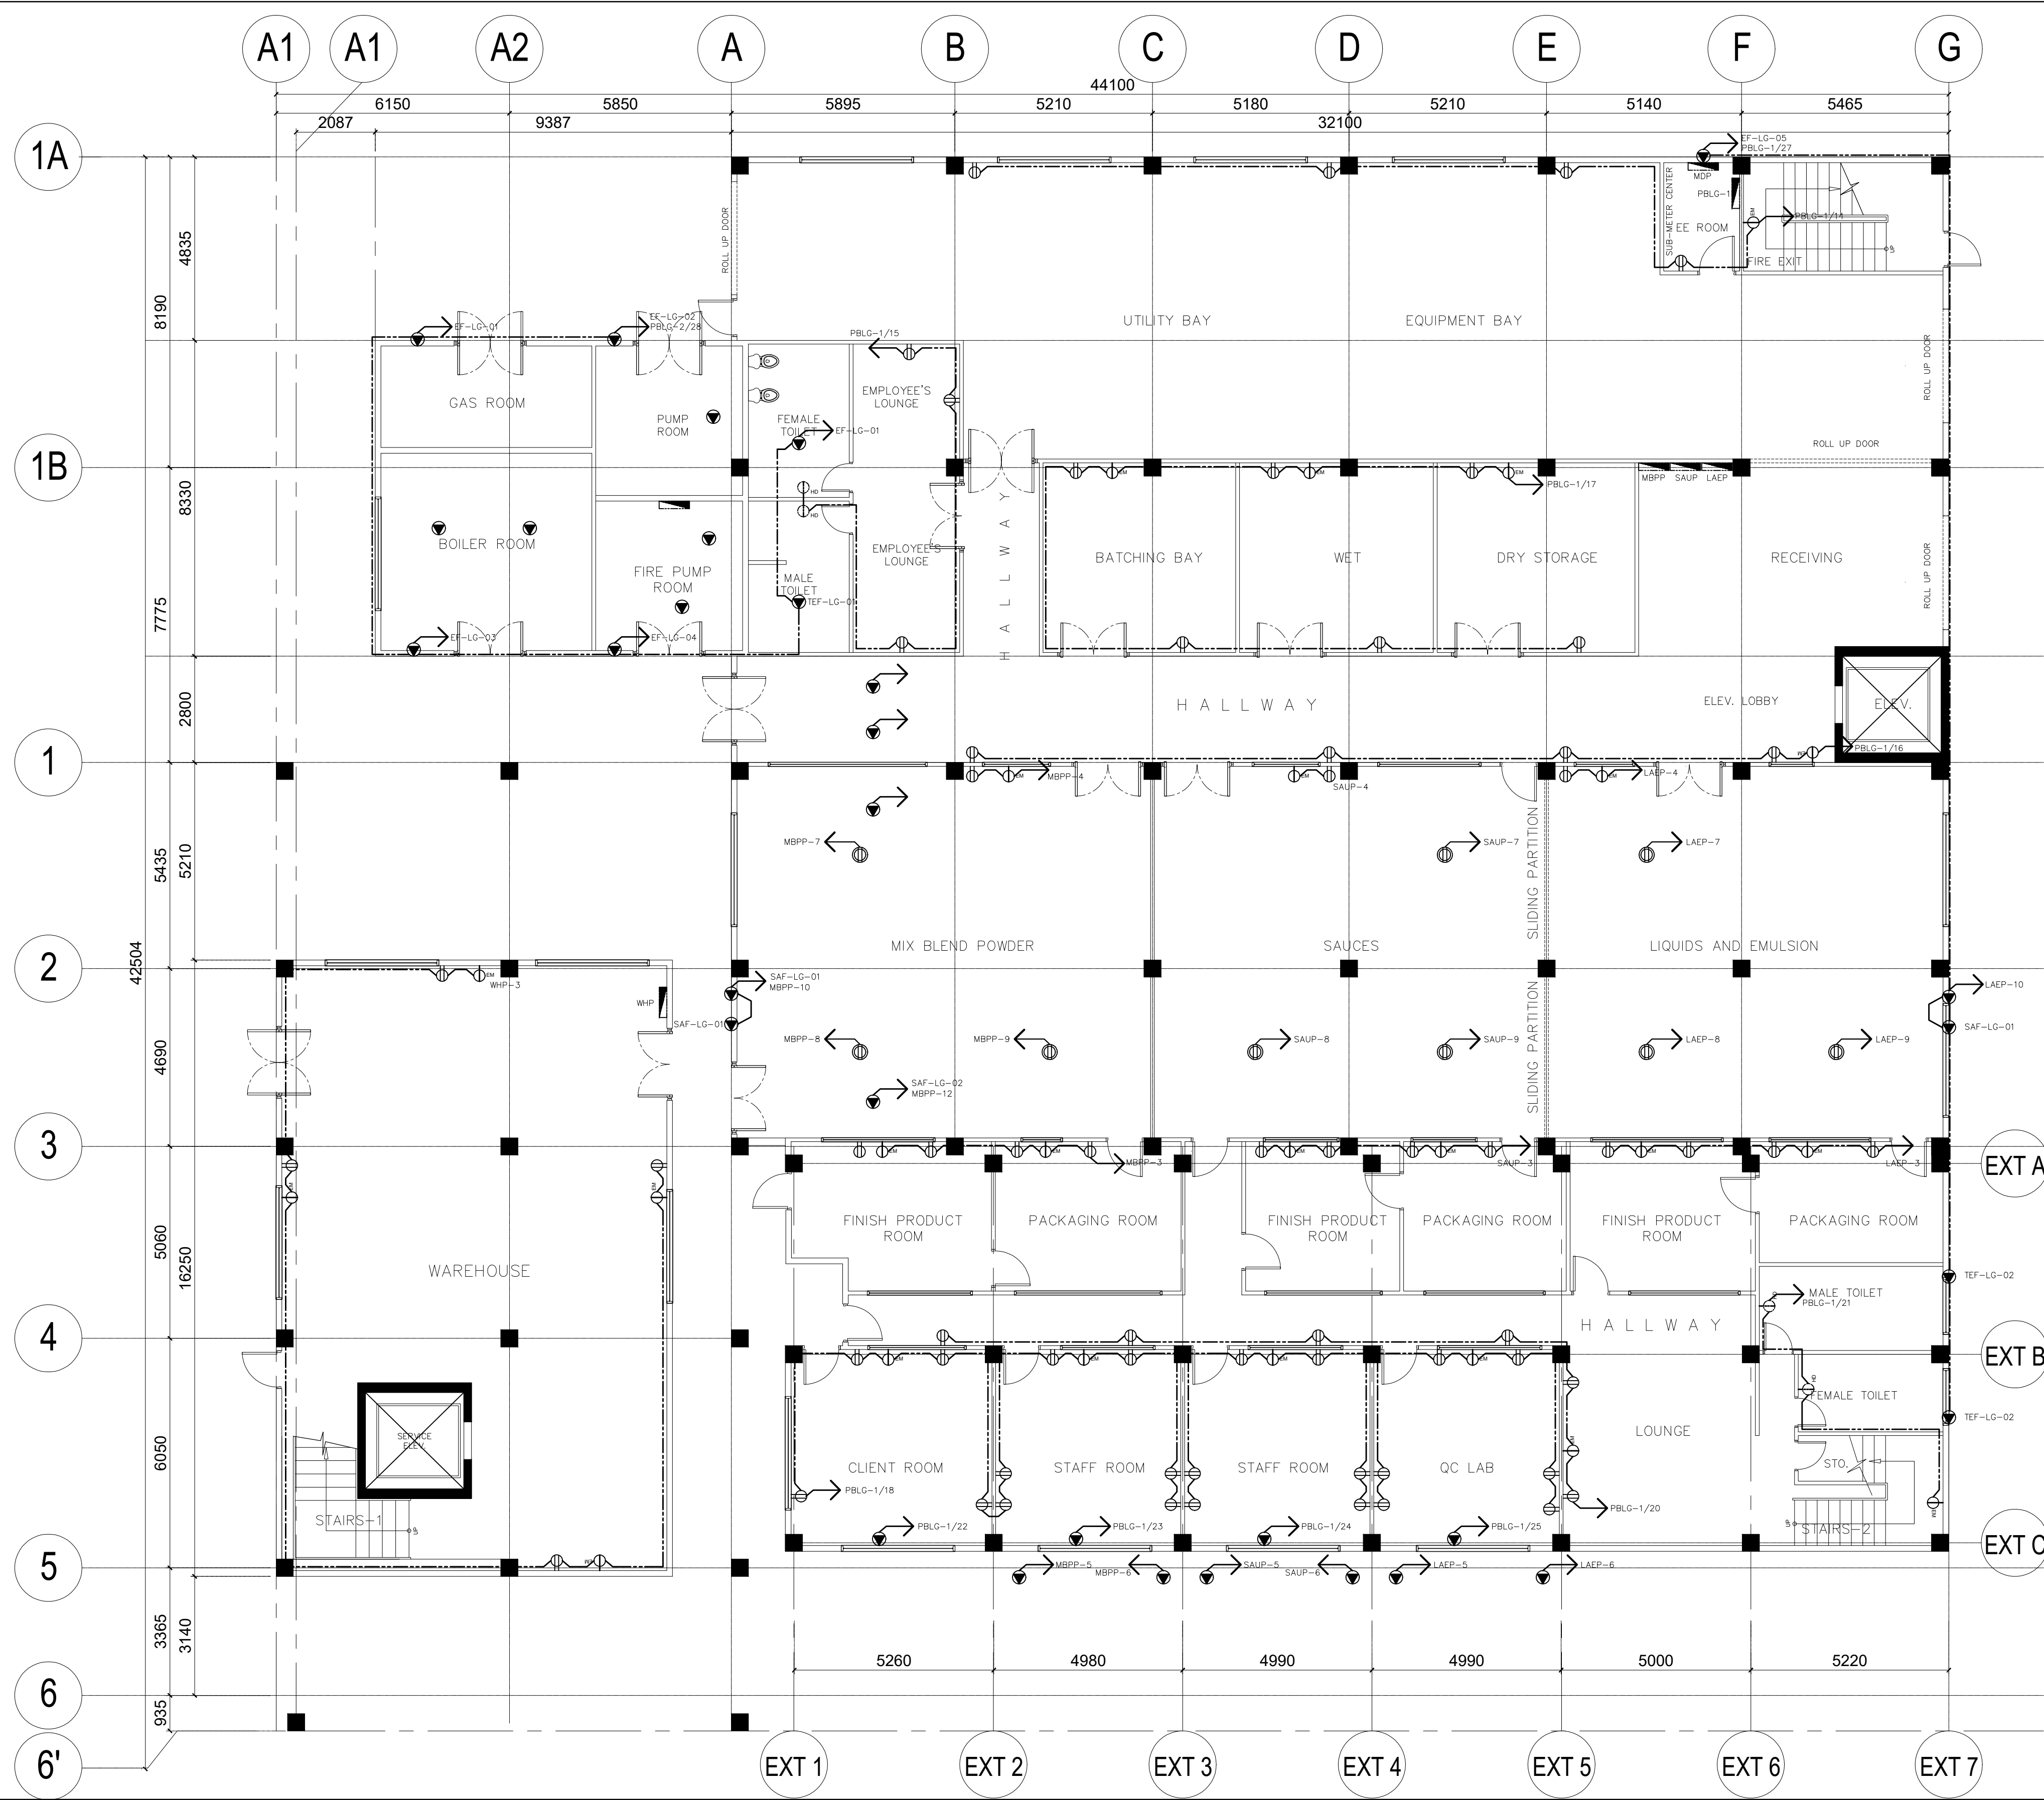


1
E-03
**LOWER GROUND FLOOR
POWER LAYOUT**
SCALE 1:200M.

CONTRACTOR	
	
ELECTRICAL ENGINEER	
ARMANDO S. CALAGUAS	
PRC. REG. NO. 2375	DATE: 01 / 03 / 19
PR. 7323769	PL. 146-594-412
OWNER	
	
PROJECT NAME	
EXPANSION AND EXTENSION RENOVATION OF THE EXISTING TSD FOR THE MODULAR MULTI-INDUSTRY INNOVATION CENTER AND EXECUTIVE OFFICES LOCATION: BICUTAN, TAGUIG	
APPROVED	
ANNABELLE V. BRIONES OIC-OFFICE OF THE DIRECTOR	
CONCURRED	
SHEET CONTENTS	
LOWER GROUND FLOORPLAN POWER LAYOUT	
SHEET NUMBER	
E	03
AS-BUILT	

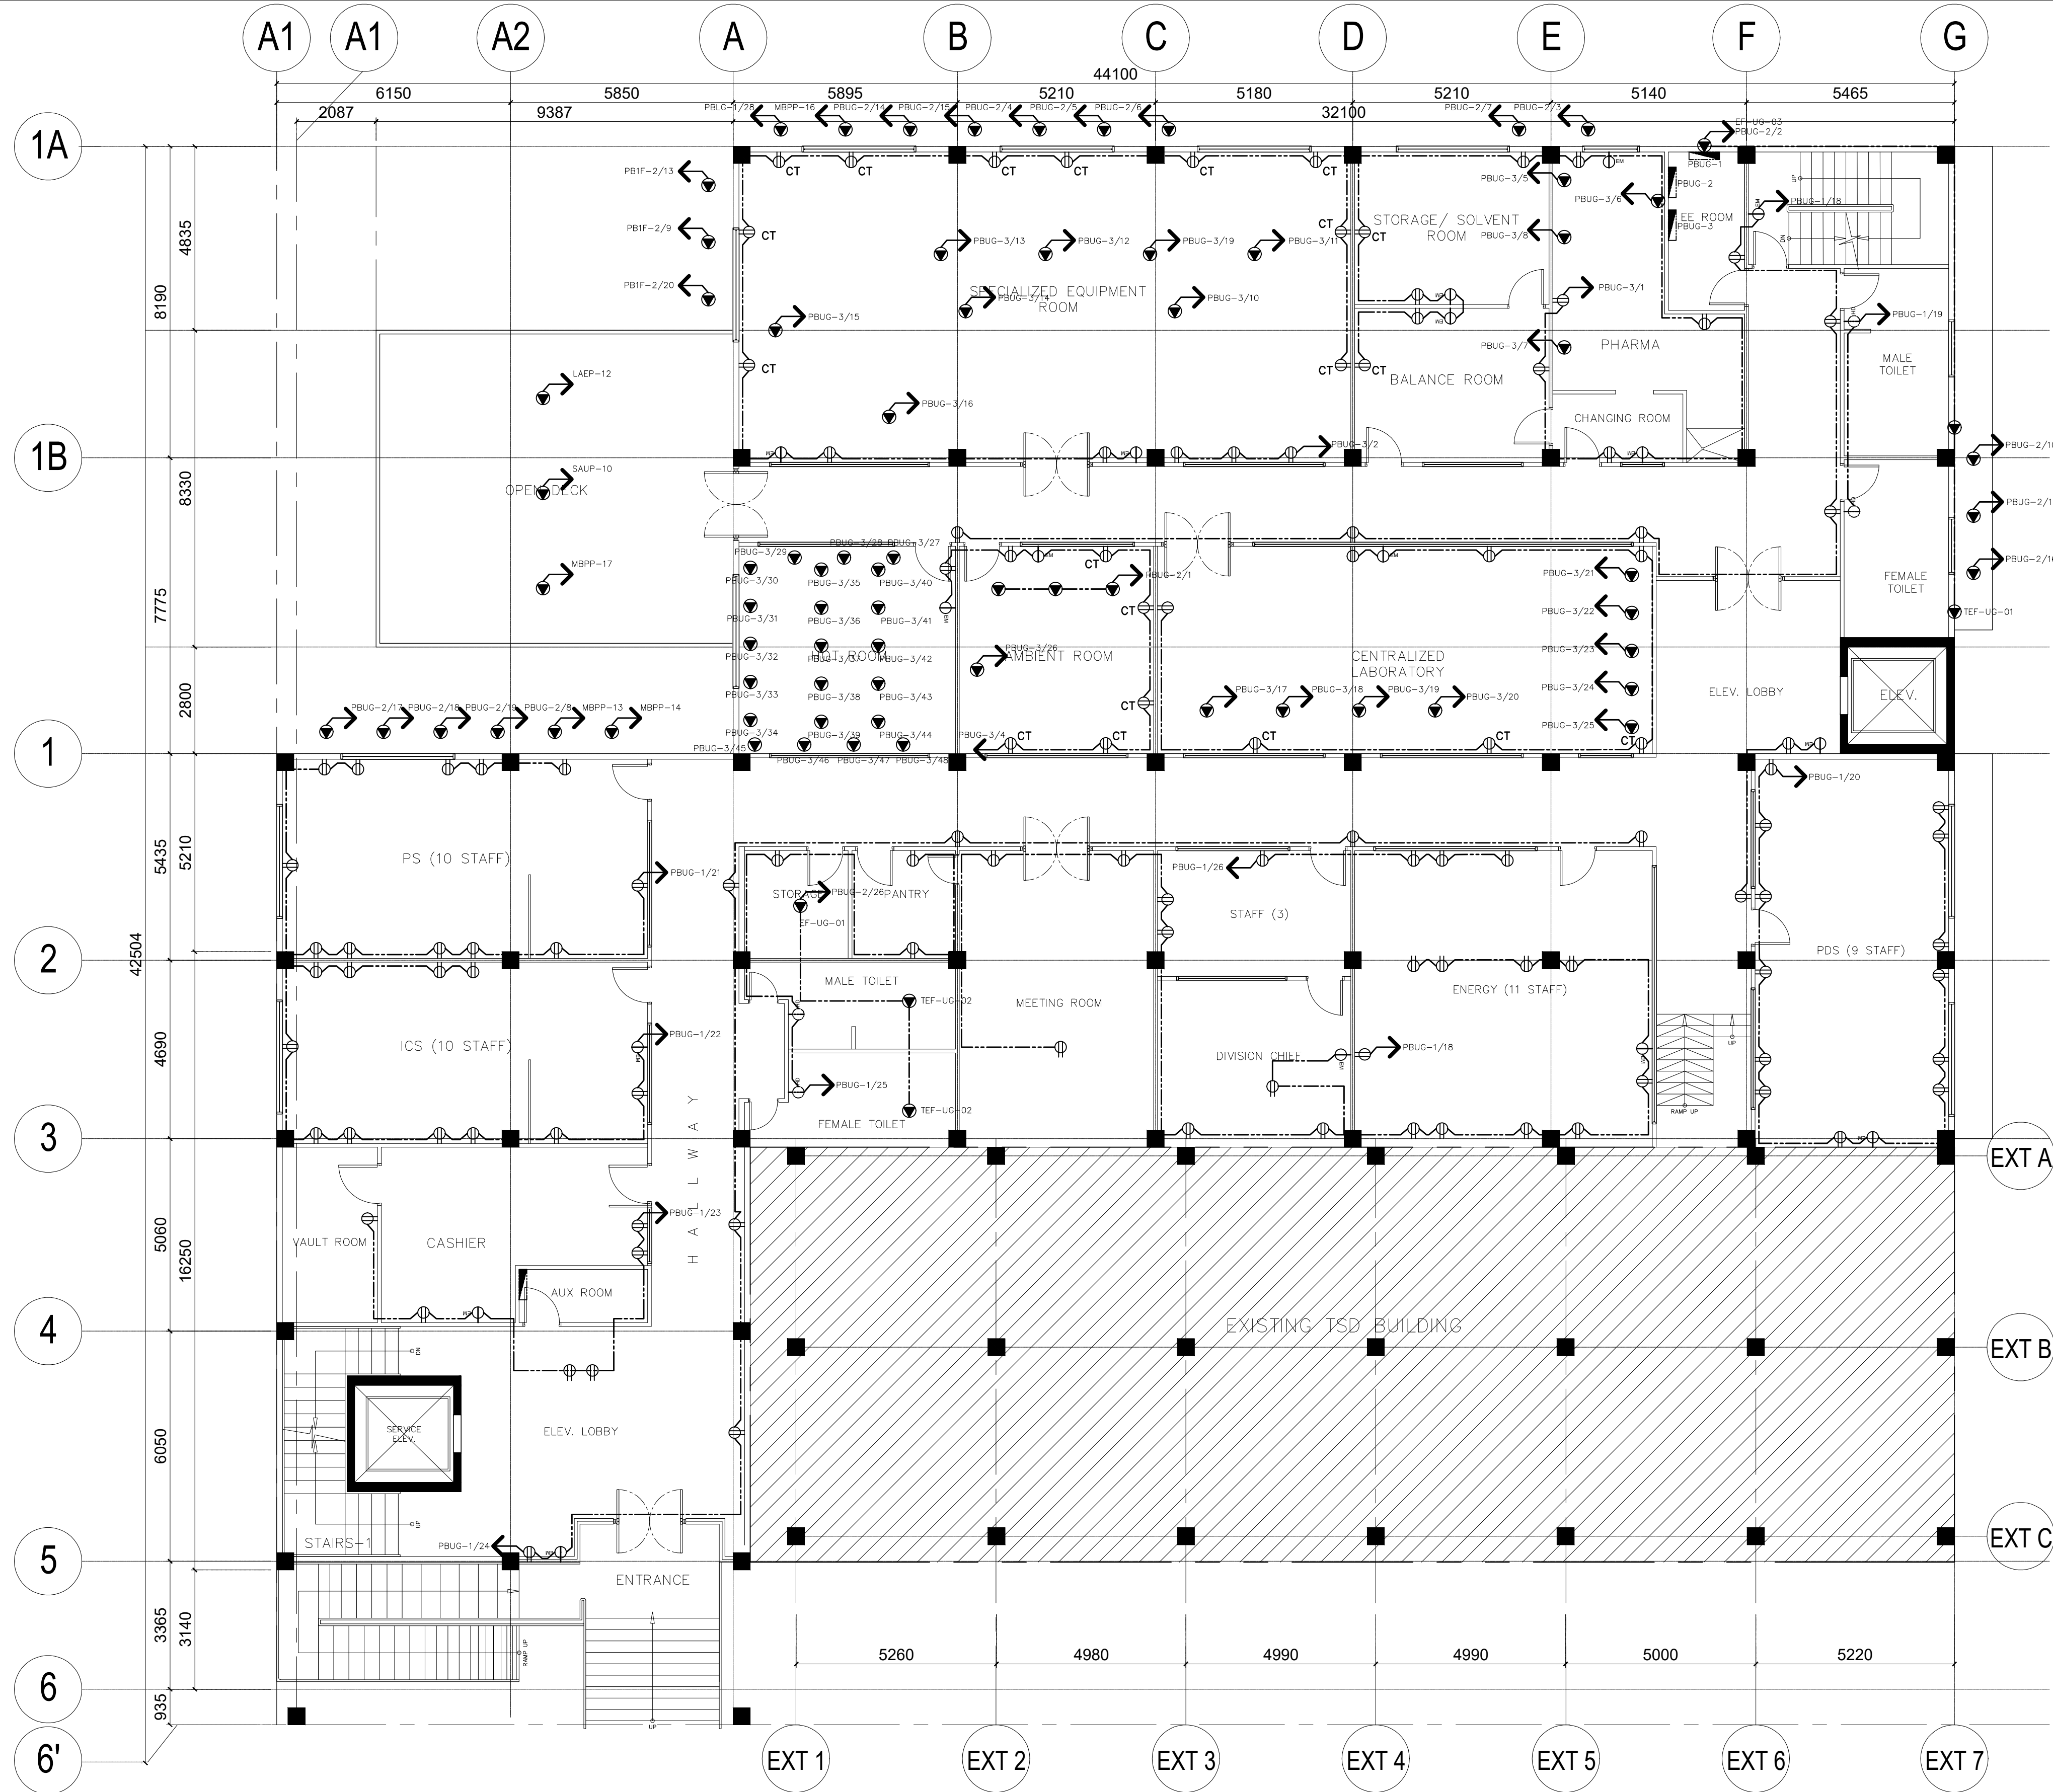

1
E-04
**UPPER GROUND FLOOR
POWER LAYOUT**
SCALE 1:200M.

CONTRACTOR	
	
ELECTRICAL ENGINEER	
ARMANDO S. CALAGUAS	
PRC REG. NO. 2375 FIR 7323769 TIN 146-594-412	DATE: 01 / 03 / 19 PLACE: QUEZON CITY
OWNER	
	
PROJECT NAME	
EXPANSION AND EXTENSION RENOVATION OF THE EXISTING TSD FOR THE MODULAR MULTI-INDUSTRY INNOVATION CENTER AND EXECUTIVE OFFICES LOCATION: BICUTAN, TAGUIG	
APPROVED	
ANNABELLE V. BRIONES OIC-OFFICE OF THE DIRECTOR	
CONCURRED	
SHEET CONTENTS	
UPPER GROUND FLOORPLAN POWER LAYOUT	
SHEET NUMBER	
E	04
AS-BUILT	

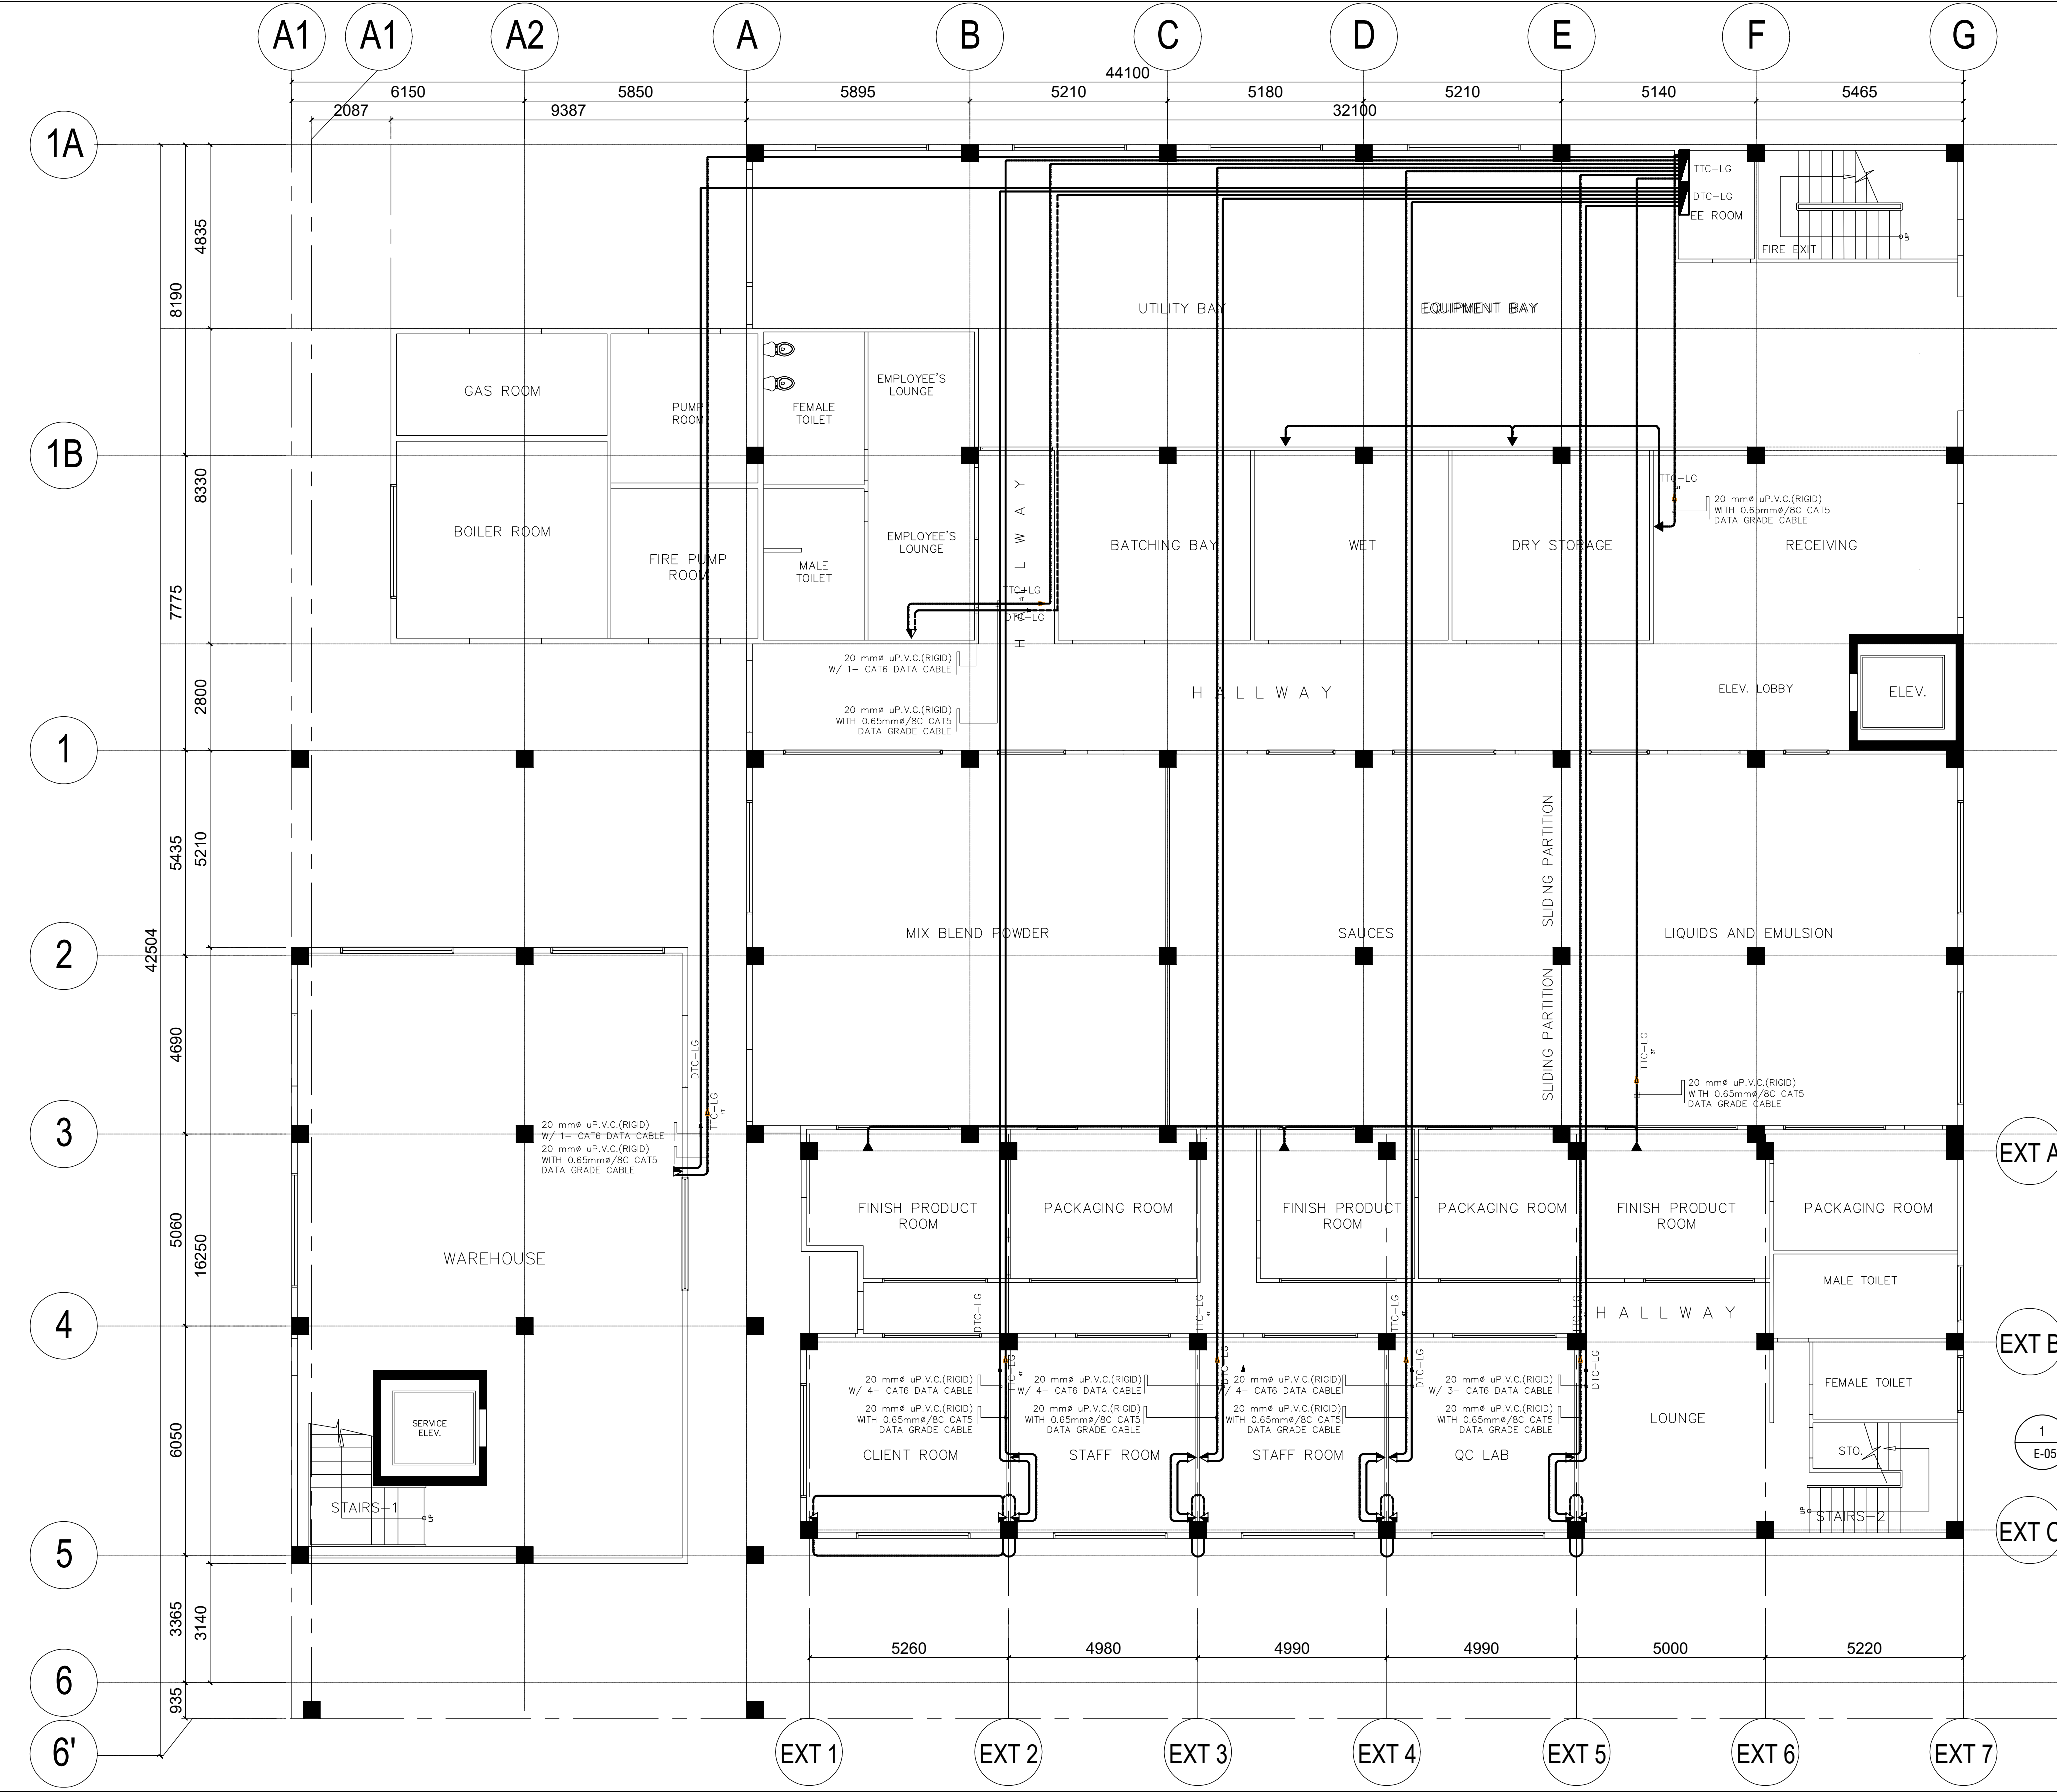

LOWER GROUND FLOOR PLAN
DATA & TELEPHONE LAYOUT


1
E-05

SCALE 1:200M.

LEGEND

- TELEPHONE CONNECTION
- DATA CONNECTION
- TEL & DATA OUTLET
- TELEPHONE OUTLET

CONTRACTOR	
 OCM STEEL CORPORATION PH. 437-00000 / FAX. 437-00000 / TEL. 437-00000 / FAX. 437-00000	
ENGINEER / ARCHITECT	
ARMANDO S. CALAGUAS	
PRC. REG. NO. 2375	DATE: 01 / 03 / 19
PR. 7323/69	PLACE: QUEZON CITY
OWNER	
 DOST-ITDI	
PROJECT NAME	
EXPANSION AND EXTENSION RENOVATION OF THE EXISTING TSD FOR THE MODULAR MULTI-INDUSTRY INNOVATION CENTER AND EXECUTIVE OFFICES LOCATION: BICUTAN, TAGUIG	
APPROVED	
ANNABELLE V. BRIONES OIC-OFFICE OF THE DIRECTOR	
CONCURRED	
SHEET CONTENTS	
LOWER GROUND DATA & TELEPHONE LAYOUT	
SHEET NUMBER	
E	05
AS-BUILT	

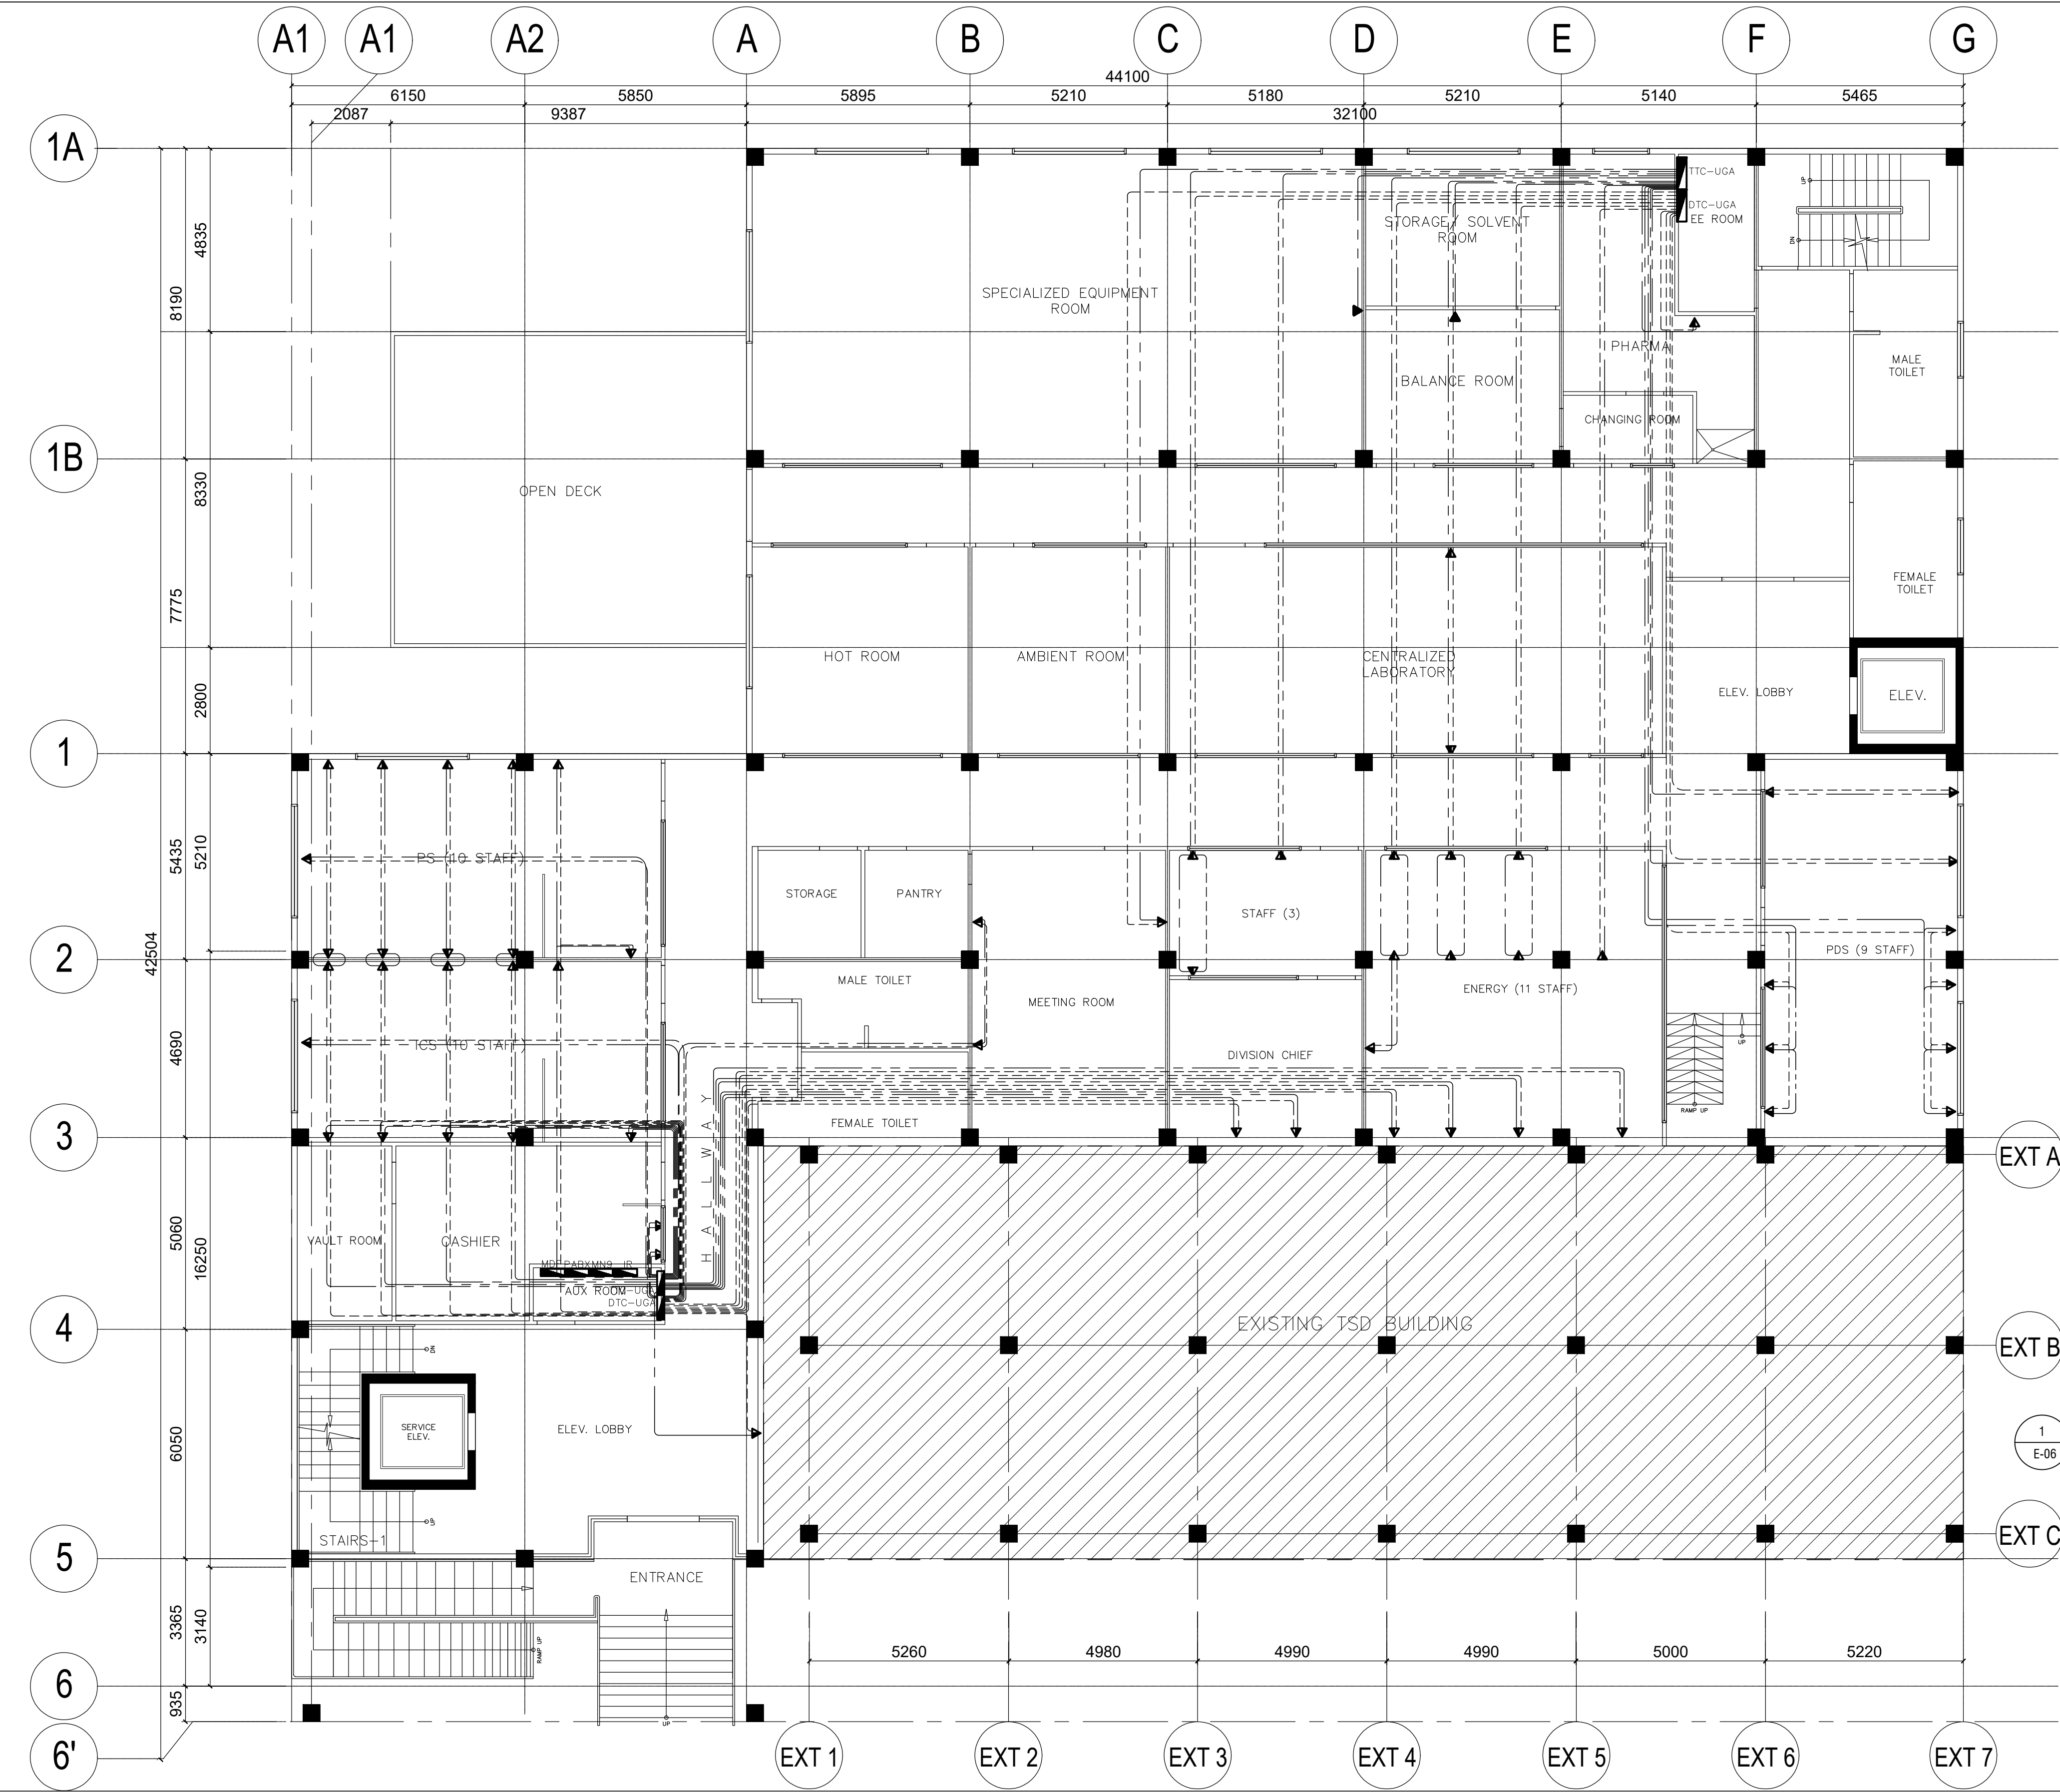


UPPER GROUND FLOOR PLAN
DATA & TELEPHONE LAYOUT
SCALE 1:200M.

LEGEND

- TELEPHONE CONNECTION DATA CONNECTION
- TEL & DATA OUTLET
- TELEPHONE OUTLET

CONTRACTOR	
ENGINEER/ ARCHITECT	
ARMANDO S. CALAGUAS	
PRC REG. NO. 2375	DATE: 01 / 03 / 19
PR. 7323/69	PLACE: QUEZON CITY
OWNER	
PROJECT NAME	
EXPANSION AND EXTENSION RENOVATION OF THE EXISTING TSD FOR THE MODULAR MULTI-INDUSTRY INNOVATION CENTER AND EXECUTIVE OFFICES LOCATION: BICUTAN, TAGUIG	
APPROVED	
ANNABELLE V. BRIONES OIC-OFFICE OF THE DIRECTOR	
CONCURRED	
SHEET CONTENTS	
UPPER GROUND DATA & TELEPHONE LAYOUT	
SHEET NUMBER	
E	06
AS-BUILT	

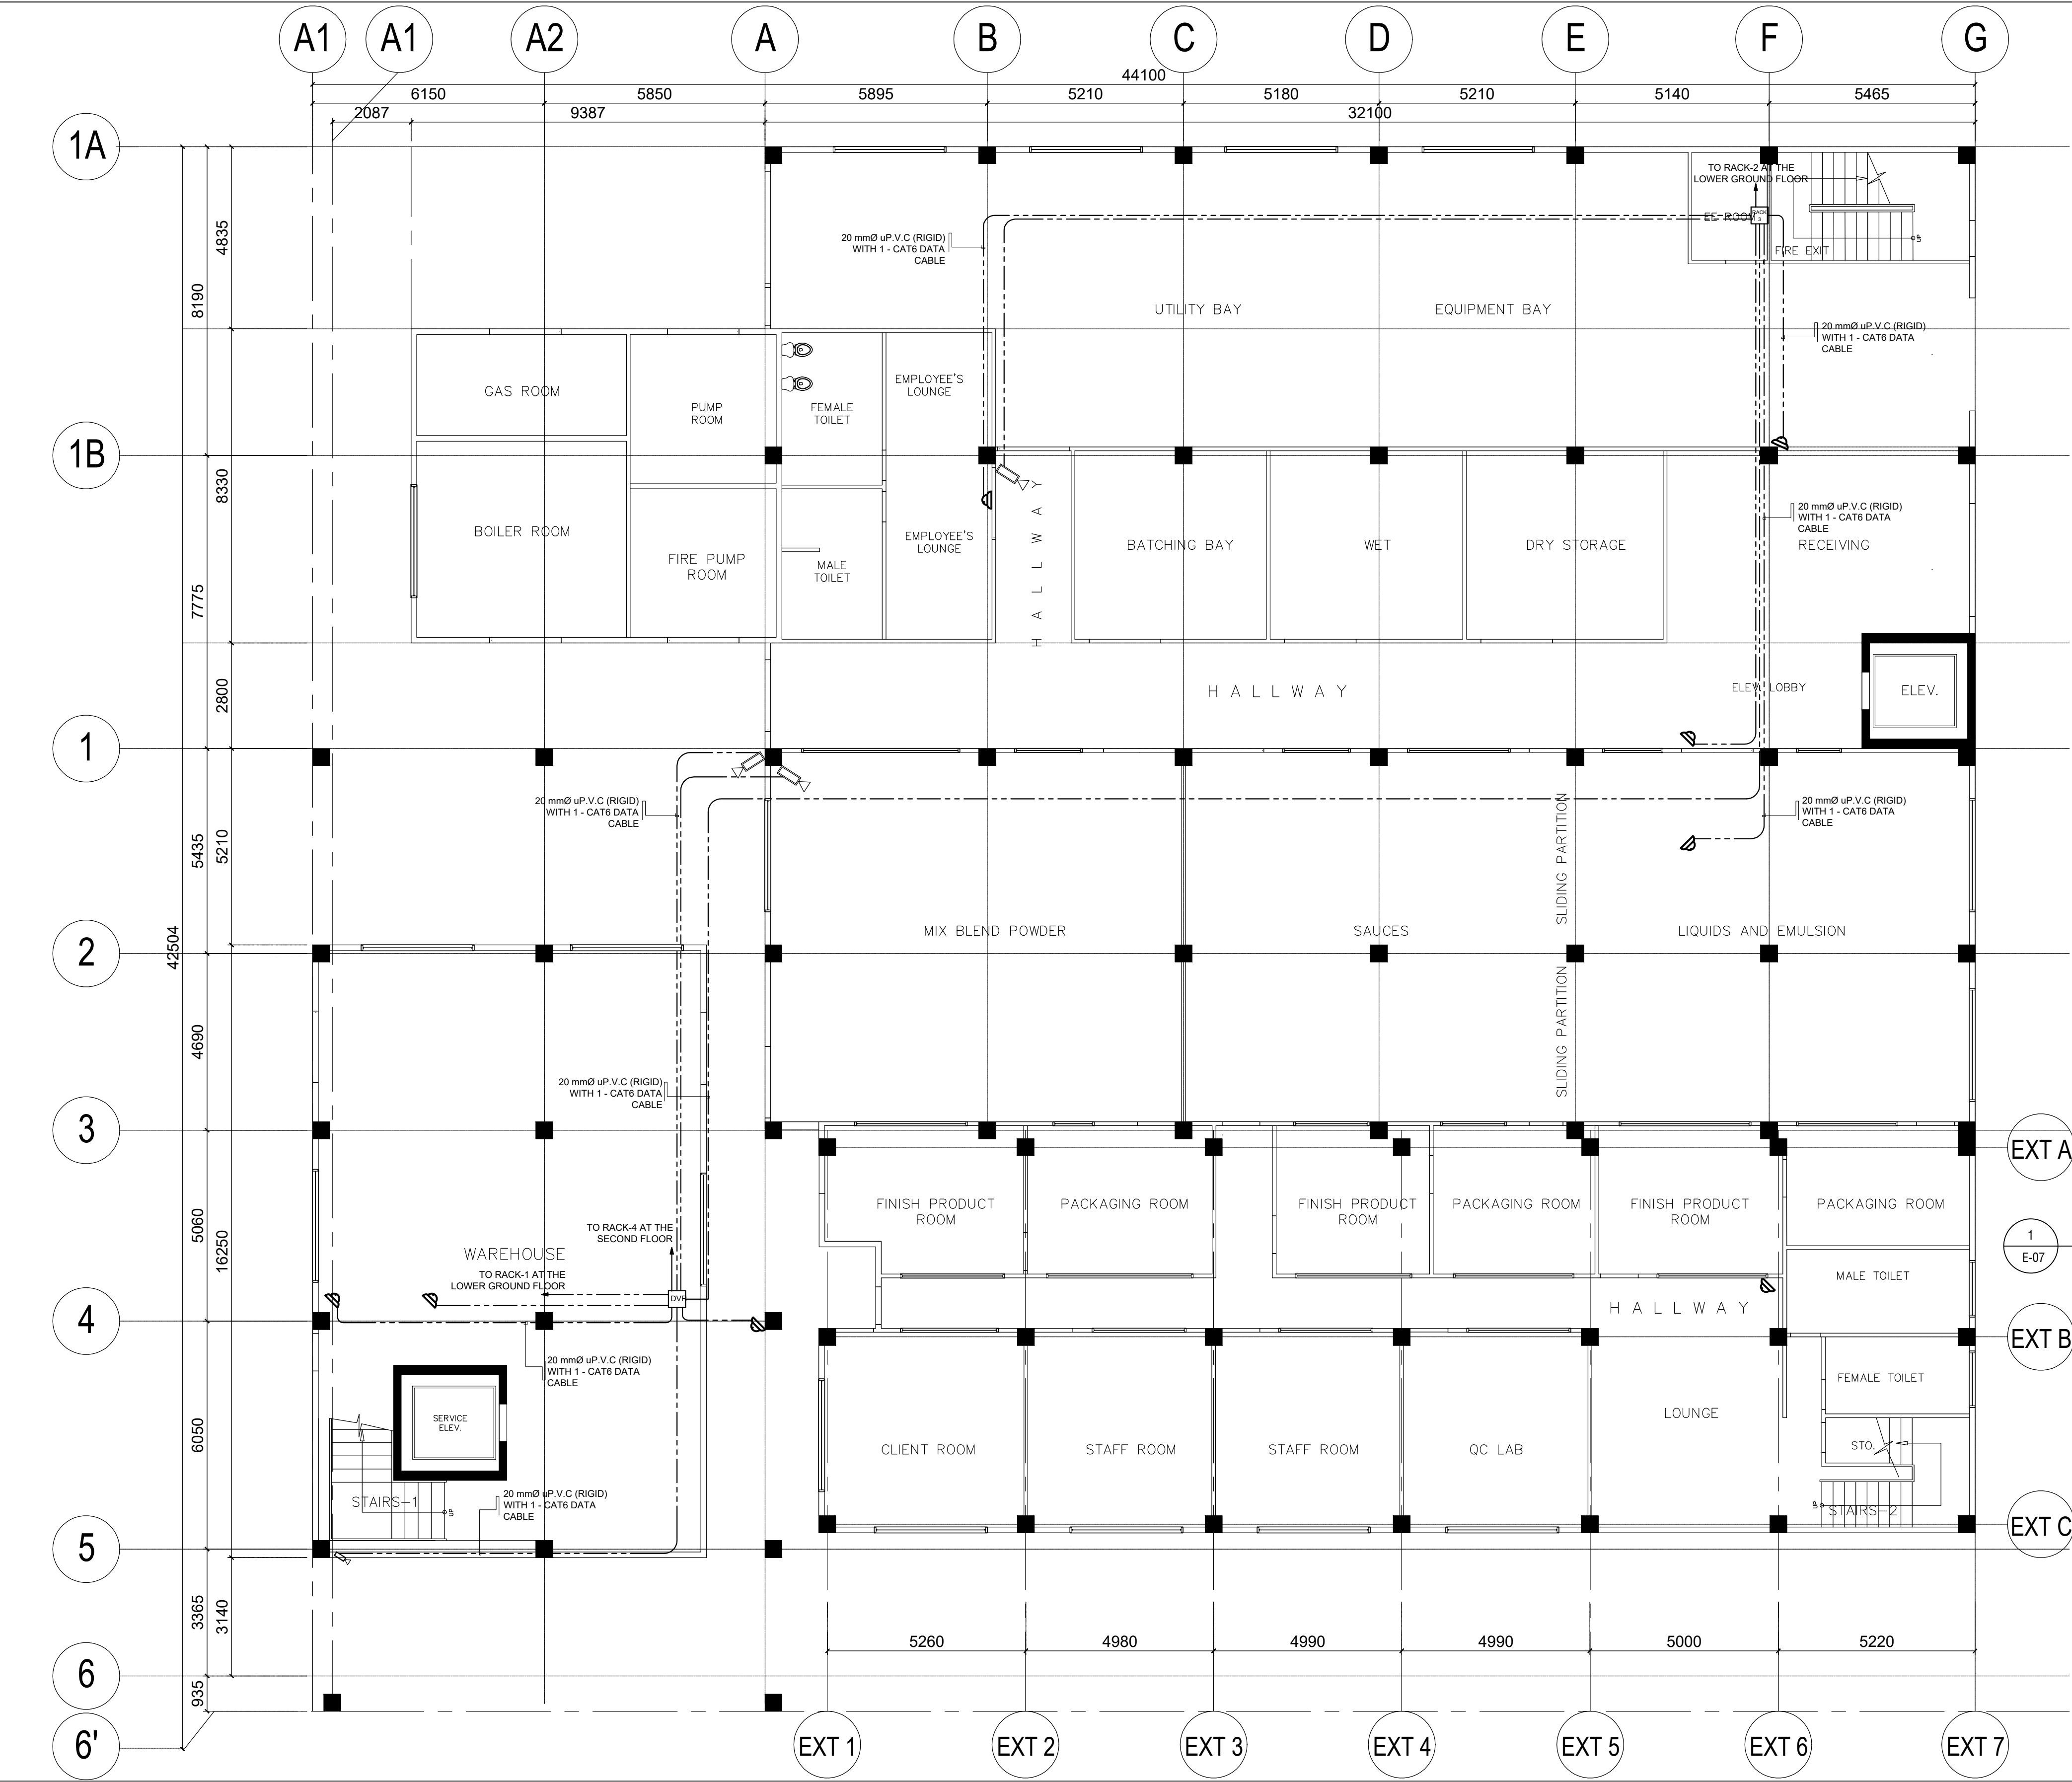


LOWER GROUND FLOOR PLAN
CCTV LAYOUT

LEGEND

WALL MOUNTED CAMERA

DOVE TYPE CAMERA

CONTRACTOR	
	
ENGINEER / ARCHITECT	
ARMANDO S. CALAGUAS	
PRC REG. NO. 2375	DATE: 01 / 03 / 19
PR. 7323/69	PLACE: QUEZON CITY
OWNER	
	
PROJECT NAME	
EXPANSION AND EXTENSION RENOVATION OF THE EXISTING TSD FOR THE MODULAR MULTI-INDUSTRY INNOVATION CENTER AND EXECUTIVE OFFICES	
LOCATION: BICUTAN, TAGUIG	
APPROVED	
ANNABELLE V. BRIONES OIC-OFFICE OF THE DIRECTOR	
CONCURRED	
SHEET CONTENTS	
LOWER GROUND FLOOR CCTV LAYOUT	
SHEET NUMBER	
E	07
AS-BUILT	

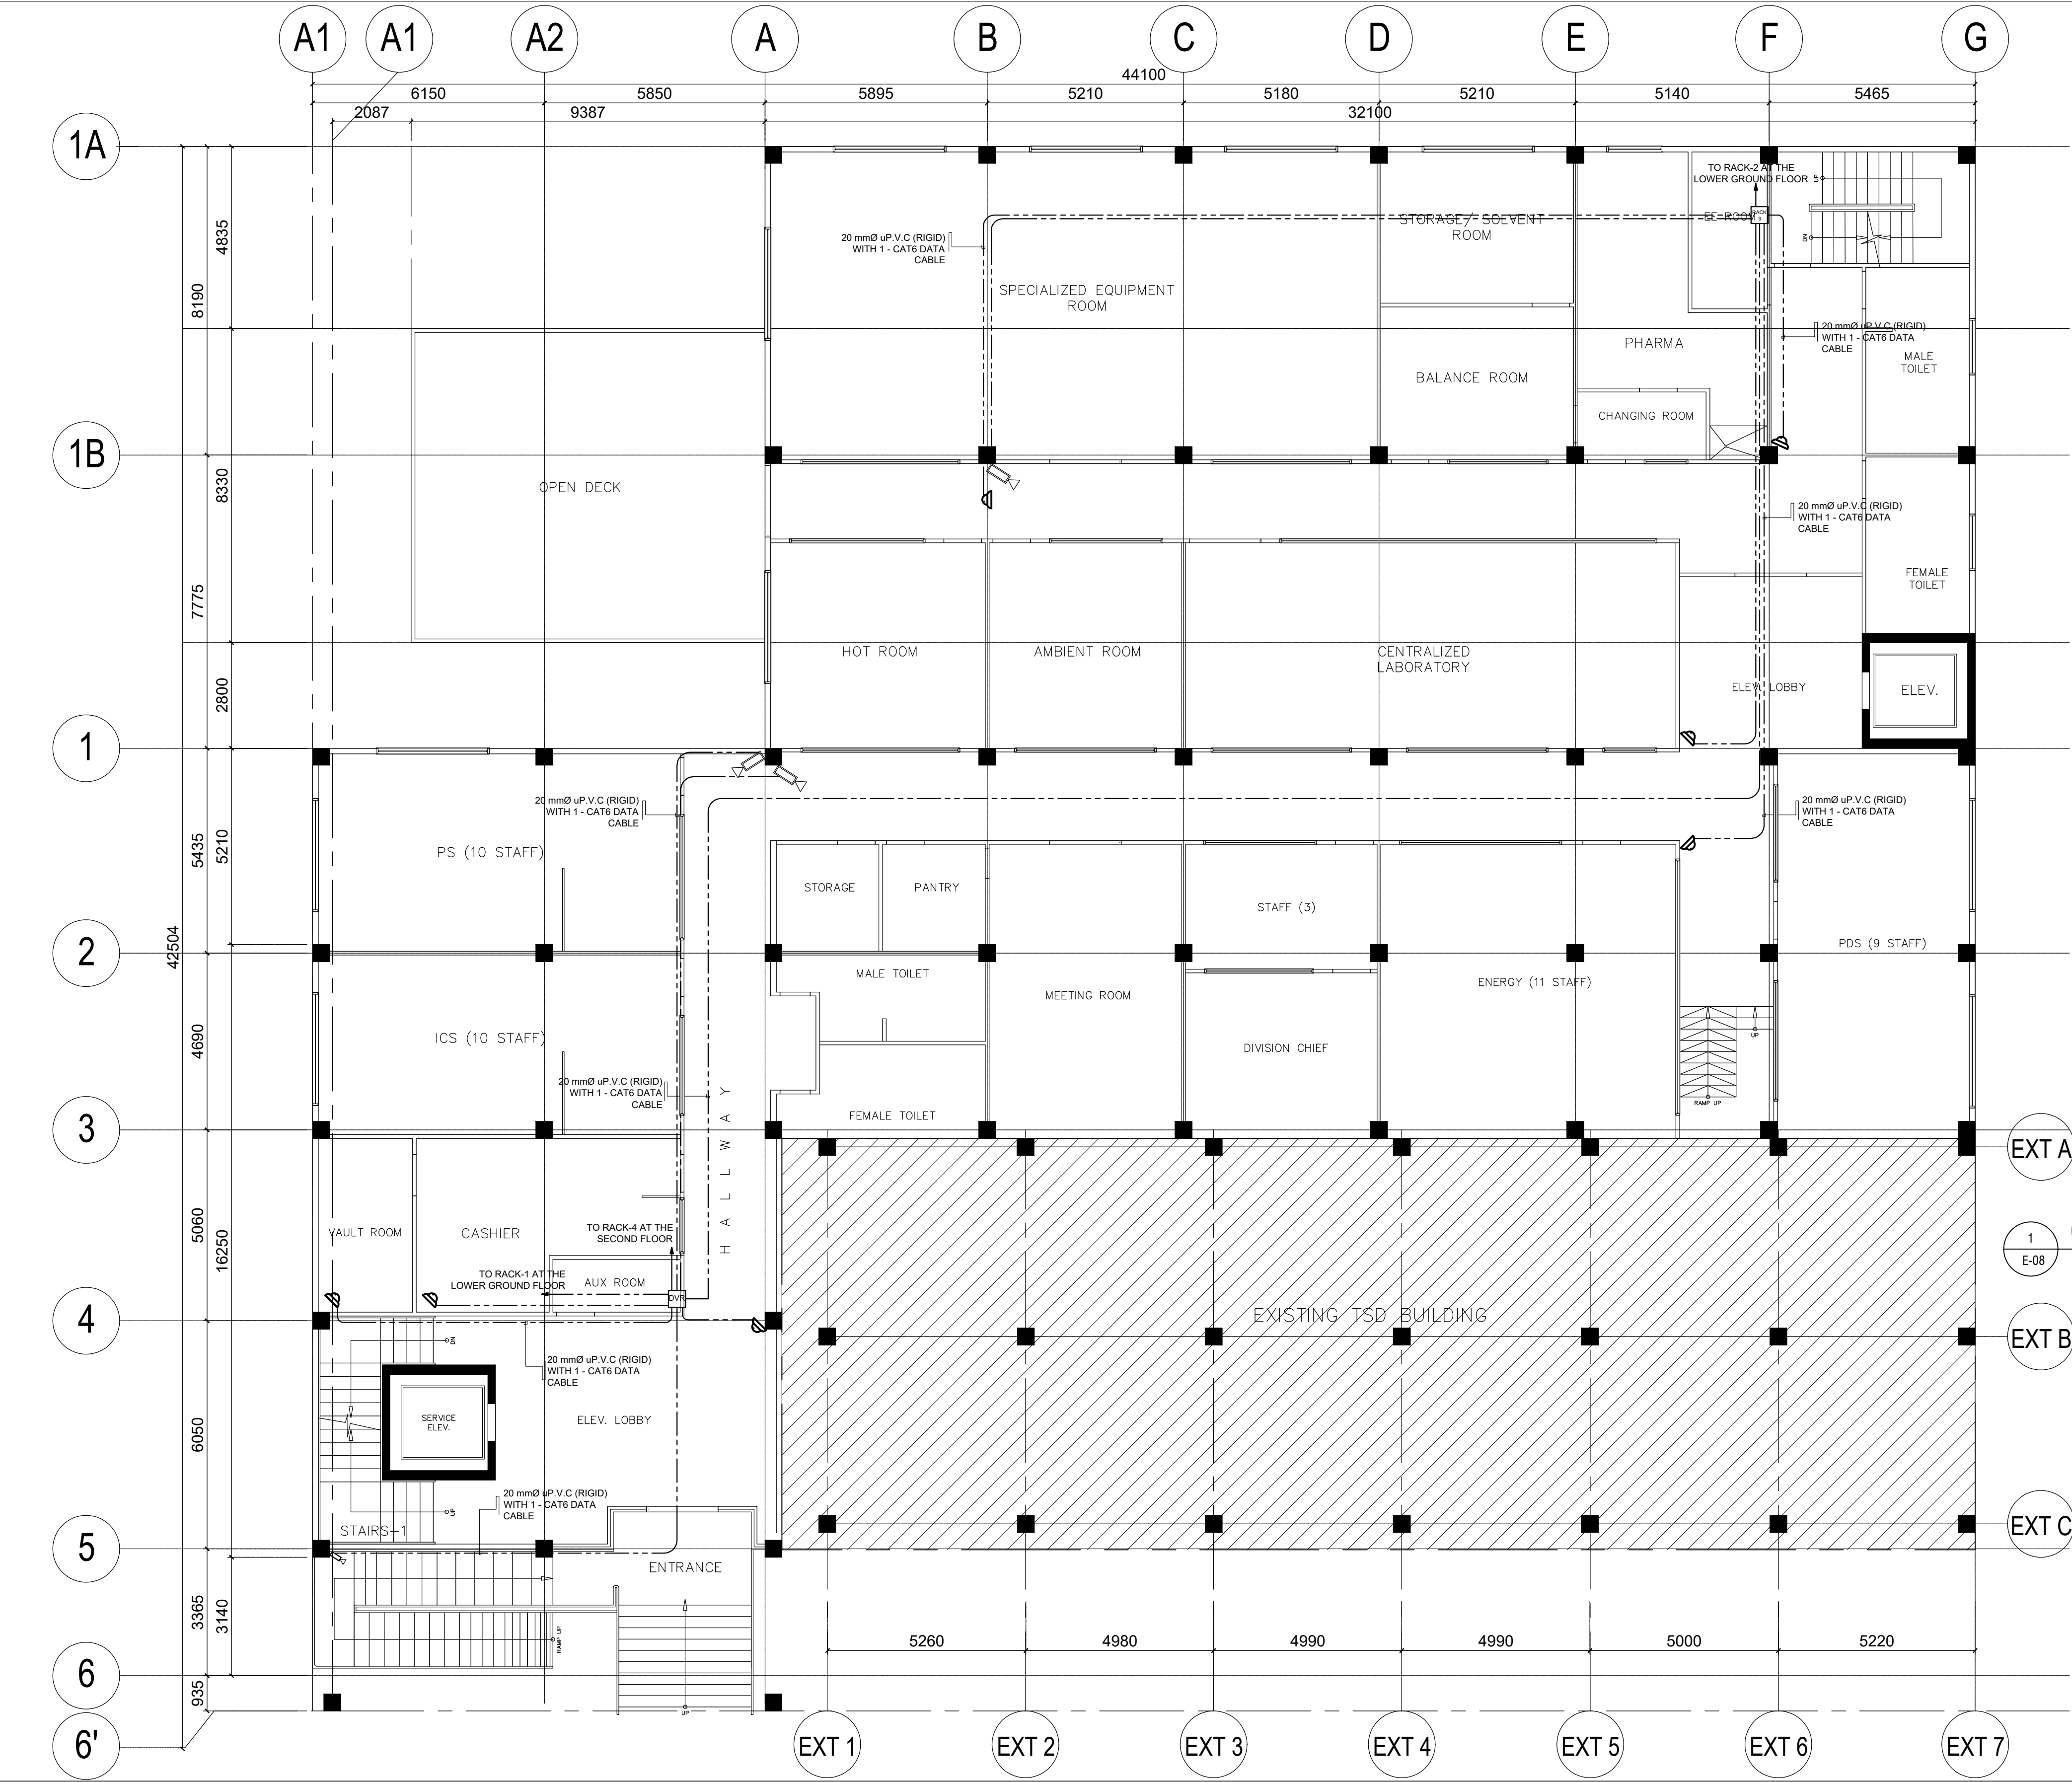

1
E-08
SCALE 1:200M.


UPPER GROUND FLOOR PLAN
CCTV LAYOUT

LEGEND

WALL MOUNTED CAMERA

DOME TYPE CAMERA

CONTRACTOR	
OCM STEEL CORPORATION ALL INQUIRIES AND ORDERS: 0917 888 8888 • 0917 888 8888 • 0917 888 8888	
ENGINEER / ARCHITECT	
ARMANDO S. CALAGUAS	
PRC REG. NO. 2375	DATE: 01 / 03 / 19
PR. 7323/69	PLACE: QUEZON CITY
OWNER	
DOST-ITDI	
PROJECT NAME	
EXPANSION AND EXTENSION RENOVATION OF THE EXISTING TSD FOR THE MODULAR MULTI-INDUSTRY INNOVATION CENTER AND EXECUTIVE OFFICES LOCATION: BICUTAN, TAGUIG	
APPROVED	
ANNABELLE V. BRIONES OIC-OFFICE OF THE DIRECTOR	
CONCURRED	
SHEET CONTENTS	
UPPER GROUND FLOOR CCTV LAYOUT	
SHEET NUMBER	
E	08
AS-BUILT	

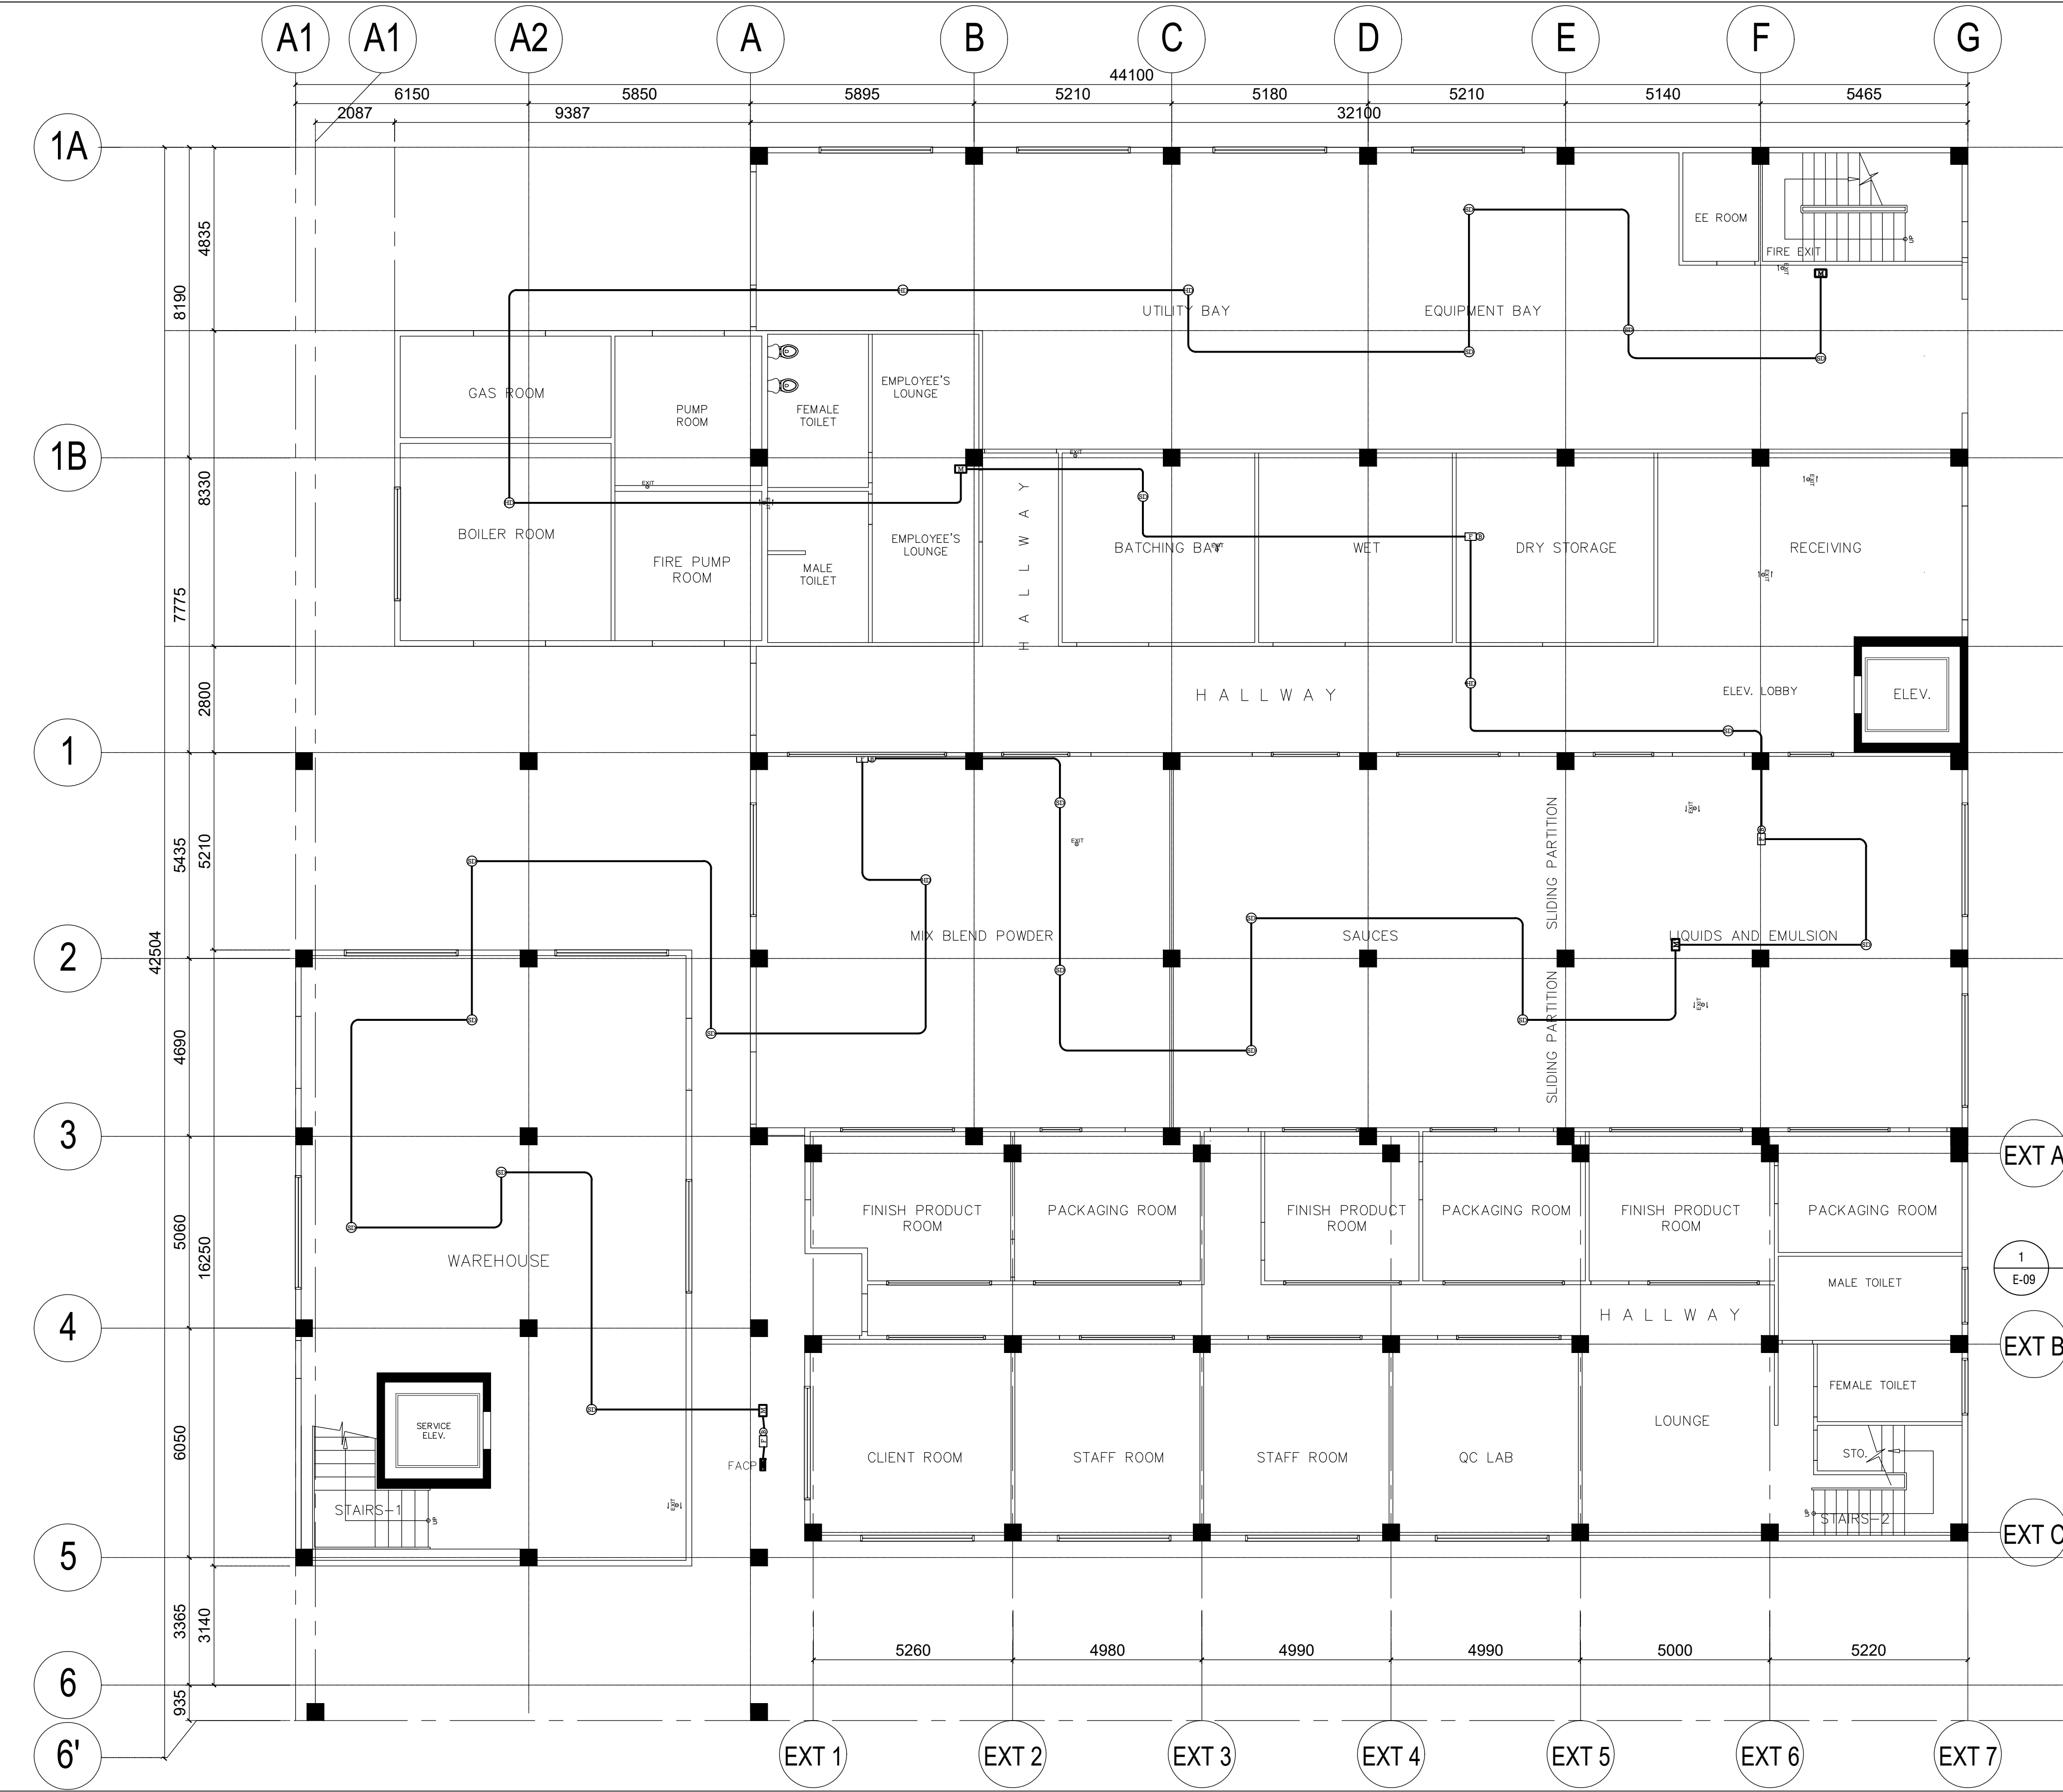


**LOWER GROUND FLOOR PLAN
SMOKE/HEAT DETECTOR LAYOUT**

1
E-09 SCALE 1:200M.

LEGEND	
	MANUAL PULL STATION
	FIRE ALARM BELL
	HEAT DETECTOR
	SMOKE DETECTOR
	DOUBLE SIDED DIRECTIONAL EXIT SIGN
	ONE DIRECTIONAL EXIT SIGN
	FIXED MOUNTED EXIT SIGN

CONTRACTOR	
O C M STEEL CORPORATION ALL INQUIRIES AND ORDERS: 0917 888 8888 / 0917 888 8889 / 0917 888 8890 / 0917 888 8891 / 0917 888 8892 / 0917 888 8893 / 0917 888 8894 / 0917 888 8895 / 0917 888 8896 / 0917 888 8897 / 0917 888 8898 / 0917 888 8899	
ENGINEER / ARCHITECT	
ARMANDO S. CALAGUAS	
PRC. REG. NO. 2375	DATE: 01 / 03 / 19
PR. 7323/69	PLACE: QUEZON CITY
OWNER	
DOST-ITDI	
PROJECT NAME	
EXPANSION AND EXTENSION RENOVATION OF THE EXISTING TSD FOR THE MODULAR MULTI-INDUSTRY INNOVATION CENTER AND EXECUTIVE OFFICES LOCATION: BICUTAN, TAGUIG	
APPROVED	
ANNABELLE V. BRIONES OIC-OFFICE OF THE DIRECTOR	
CONCURRED	
SHEET CONTENTS	
LOWER GROUND FLOOR SMOKE/HEAT DETECTOR LAYOUT	
SHEET NUMBER	
E	09
AS-BUILT	

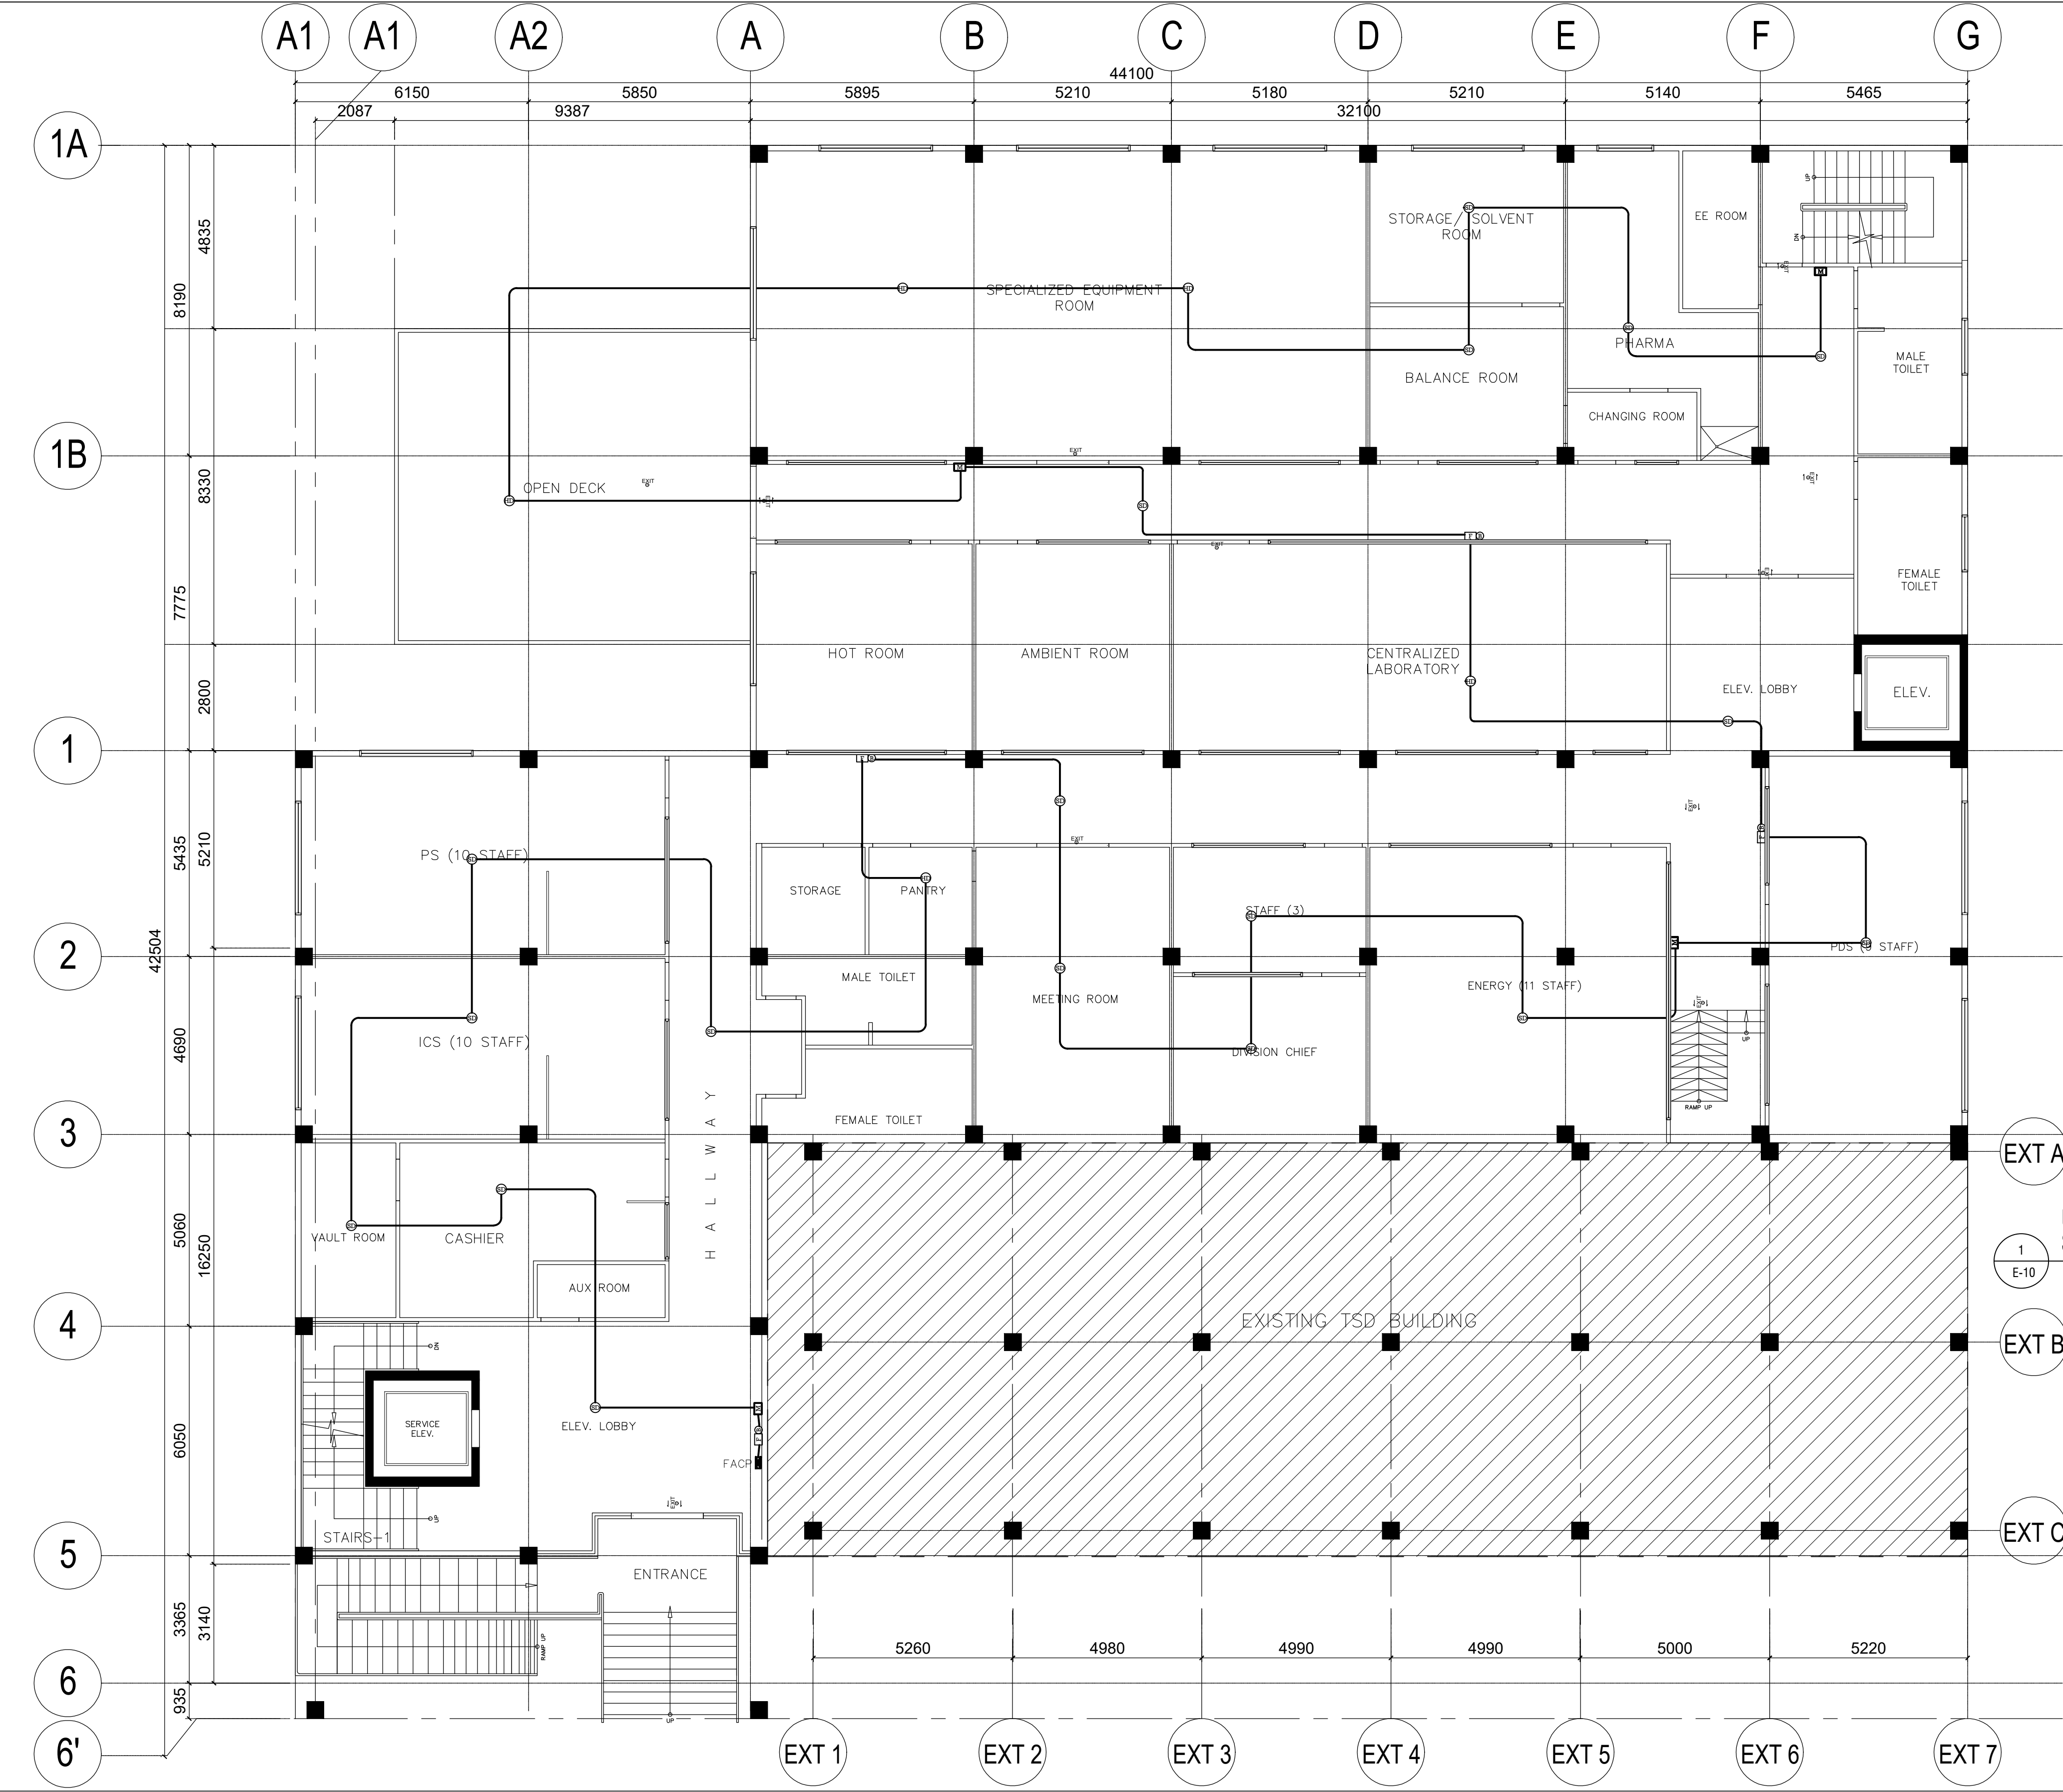

**UPPER GROUND FLOOR PLAN
SMOKE/HEAT DETECTOR LAYOUT**
1
E-10 SCALE 1:200M.

LEGEND	
	MANUAL PULL STATION
	FIRE ALARM BELL
	HEAT DETECTOR
	SMOKE DETECTOR
	DOUBLE SIDED DIRECTIONAL EXIT SIGN
	ONE DIRECTIONAL EXIT SIGN
	FIXED MOUNTED EXIT SIGN

CONTRACTOR

OCM STEEL CORPORATION
100-A, INDUSTRIAL ZONE, CALABANG, Bataan City, Bataan, Philippines
TEL. NO. 481-8181 / 481-8182 FAX NO. 837-2724

ENGINEER/ ARCHITECT

ARMANDO S. CALAGUAS

PRC REG. NO. 2375
P.R. 7323/69

DATE: 01 / 03 / 19
PLACE: QUEZON CITY

OWNER

DOST-ITDI

PROJECT NAME

EXPANSION AND EXTENSION
RENOVATION OF THE EXISTING TSD
FOR THE MODULAR MULTI-INDUSTRY
INNOVATION CENTER AND
EXECUTIVE OFFICES

LOCATION: BICUTAN, TAGUIG

APPROVED

ANNABELLE V. BRIONES
OIC-OFFICE OF THE DIRECTOR

CONCURRED

SHEET CONTENTS

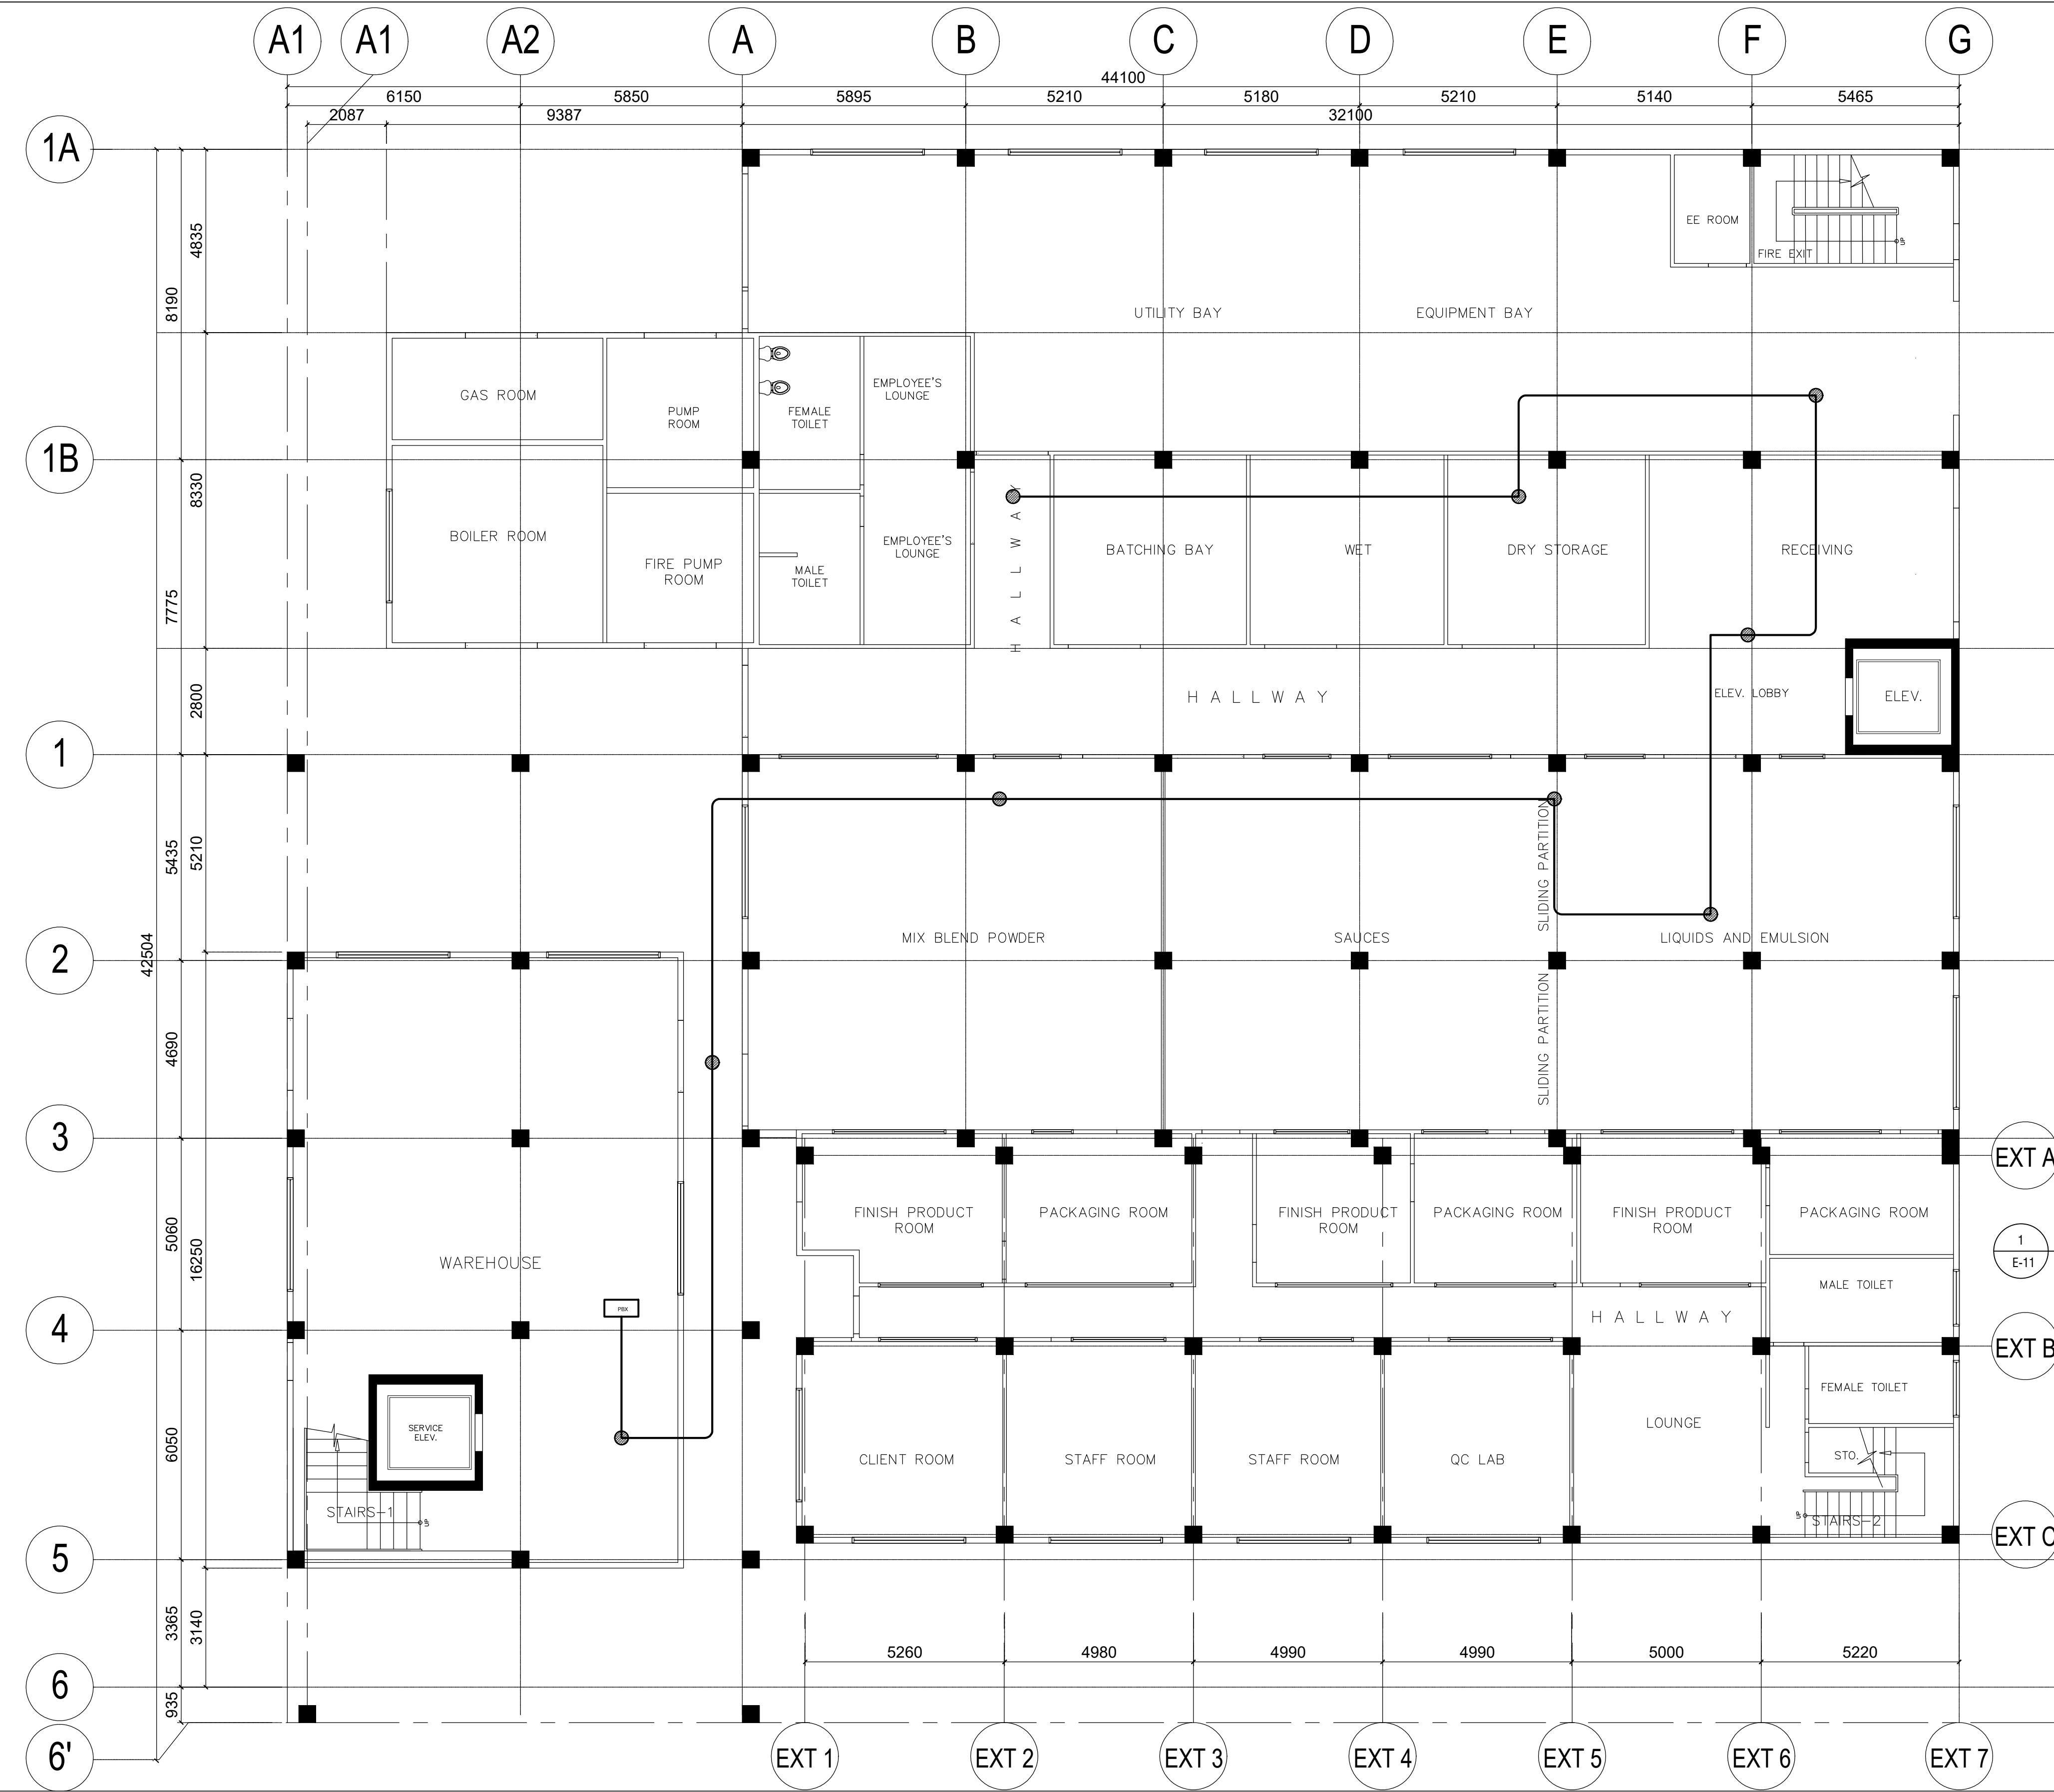
UPPER GROUND FLOOR
SMOKE/HEAT DETECTOR
LAYOUT

SHEET NUMBER

E

10


AS-BUILT



**LOWER GROUND FLOOR PLAN
PUBLIC ADDRESS LAYOUT**
SCALE 1:200M.

LEGEND
● SPEAKER


CONTRACTOR	
	
ENGINEER/ ARCHITECT	
ARMANDO S. CALAGUAS	
PRC REG. NO. 2375	DATE: 01 / 03 / 19
PR. 7323/69	PLACE: QUEZON CITY
OWNER	
	
PROJECT NAME	
EXPANSION AND EXTENSION RENOVATION OF THE EXISTING TSD FOR THE MODULAR MULTI-INDUSTRY INNOVATION CENTER AND EXECUTIVE OFFICES LOCATION: BICUTAN, TAGUIG	
APPROVED	
ANNABELLE V. BRIONES OIC-OFFICE OF THE DIRECTOR	
CONCURRED	
SHEET CONTENTS	
LOWER GROUND FLOOR PUBLIC ADDRESS LAYOUT	
SHEET NUMBER	
E	11
AS-BUILT	

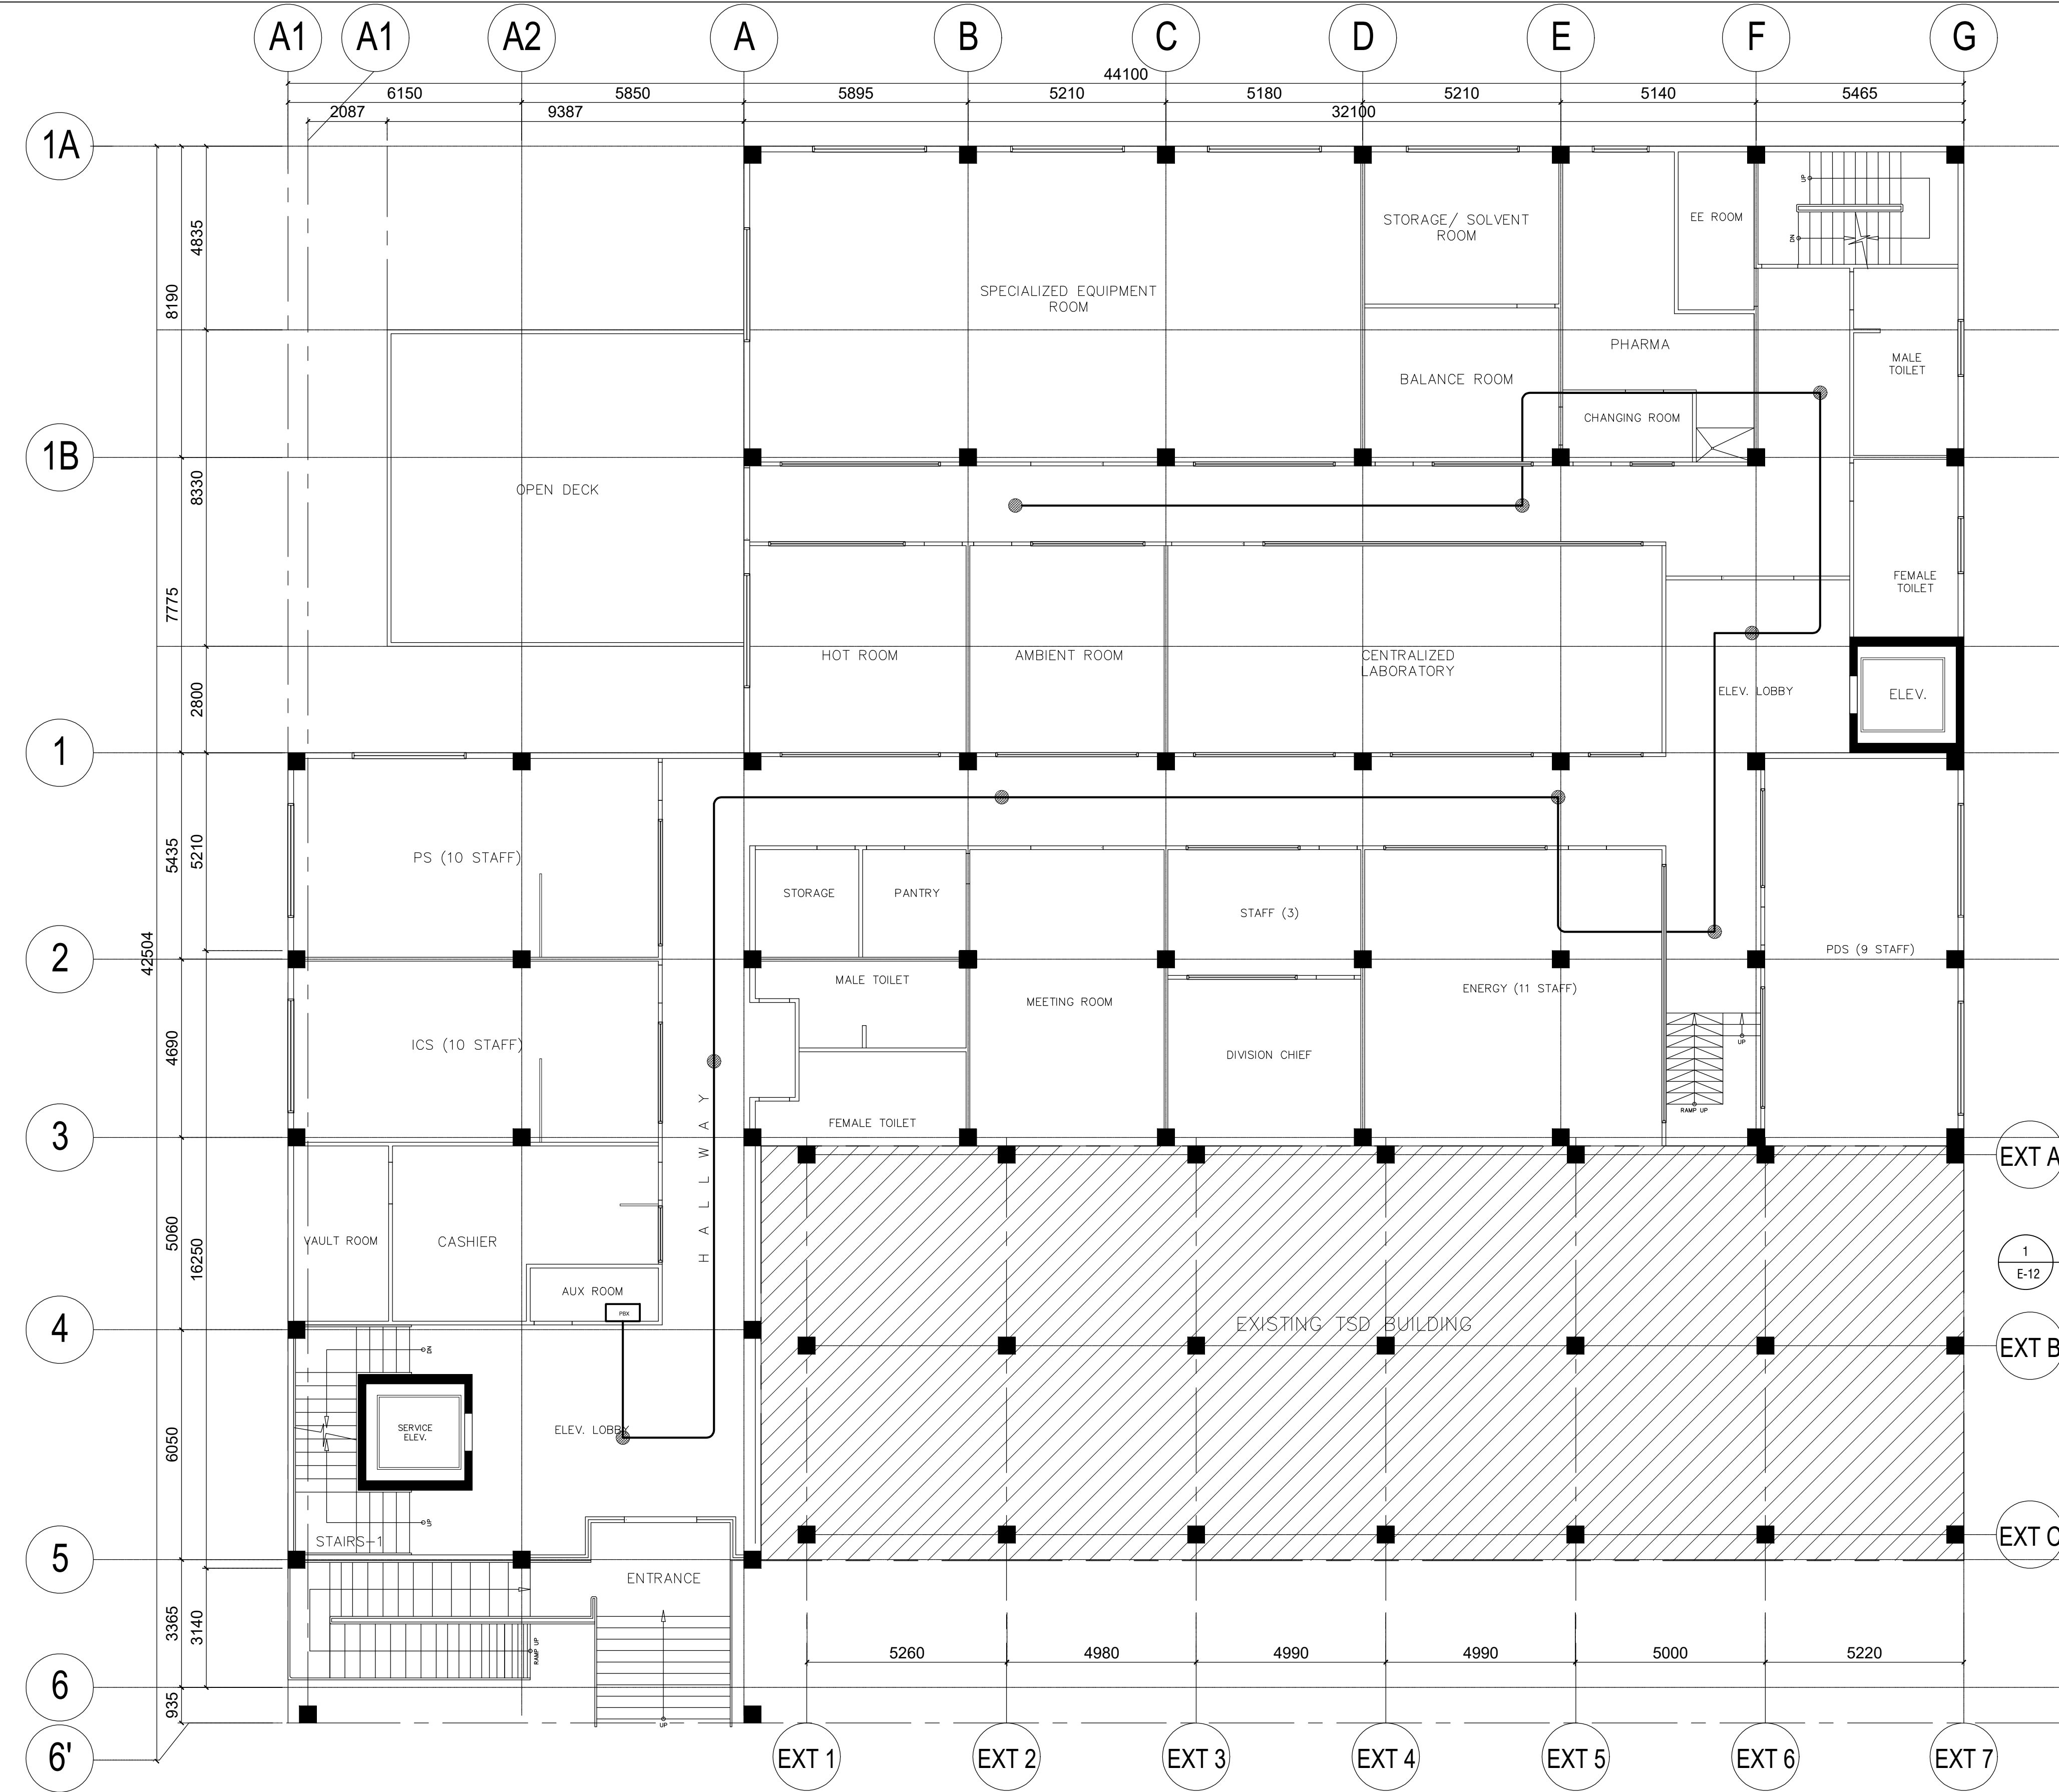



**UPPER GROUND FLOOR PLAN
PUBLIC ADDRESS LAYOUT**
SCALE 1:200M.

LEGEND
● SPEAKER


CONTRACTOR	
	
ENGINEER/ ARCHITECT	
ARMANDO S. CALAGUAS	
PRC REG. NO. 2375	DATE: 01 / 03 / 19
PR. 7323/69	PLACE: QUEZON CITY
OWNER	
	
PROJECT NAME	
EXPANSION AND EXTENSION RENOVATION OF THE EXISTING TSD FOR THE MODULAR MULTI-INDUSTRY INNOVATION CENTER AND EXECUTIVE OFFICES LOCATION: BICUTAN, TAGUIG	
APPROVED	
ANNABELLE V. BRIONES OIC-OFFICE OF THE DIRECTOR	
CONCURRED	
SHEET CONTENTS	
UPPER GROUND FLOOR PUBLIC ADDRESS LAYOUT	
SHEET NUMBER	
E	12
AS-BUILT	

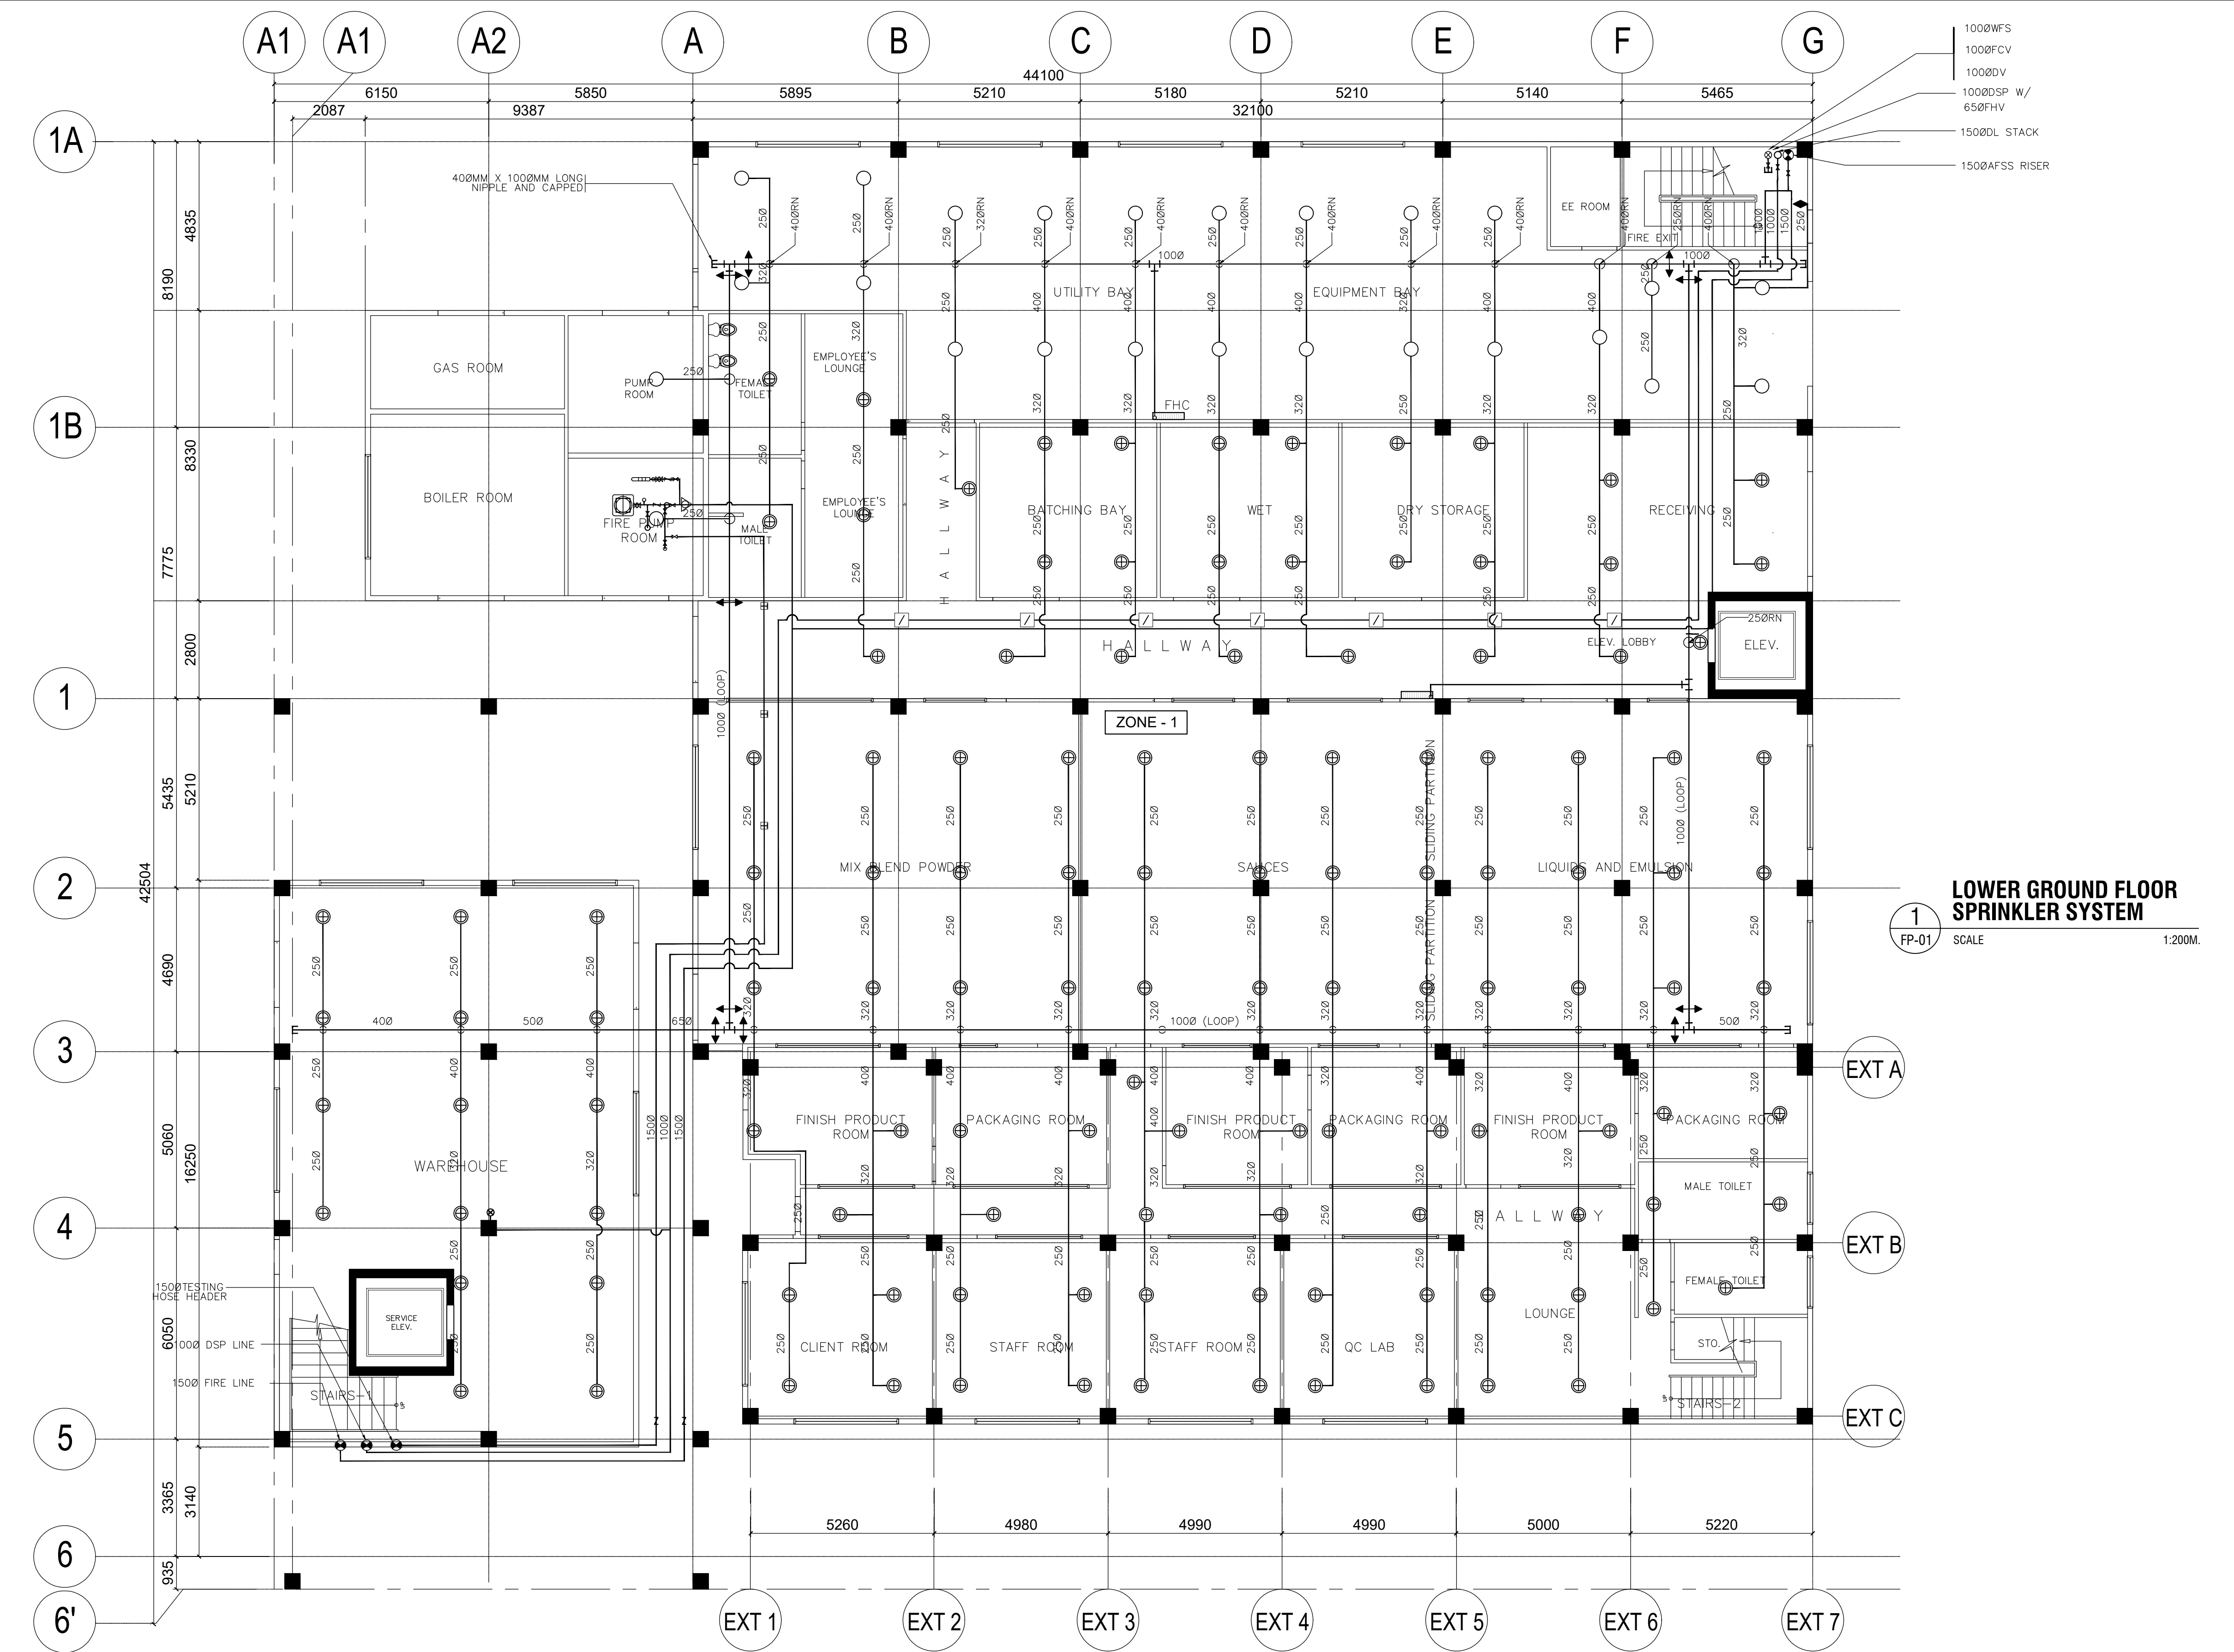

 CONTRACTOR	
 O C M STEEL CORPORATION AN IRVING-CLOUD COMPANY	
ENGINEER/ ARCHITECT	
 RONNEL D. CASTILLO	
PRC REG. NO. 4362	DATE: 01 / 03 / 19
PR. 7333760	PLACE: MAKATI CITY
OWNER	
 DOST-ITDI	
PROJECT NAME	
EXPANSION AND EXTENSION RENOVATION OF THE EXISTING TSD FOR THE MODULAR MULTI-INDUSTRY INNOVATION CENTER AND EXECUTIVE OFFICES LOCATION: BICUTAN, TAGUIG	
APPROVED	
 ANNABELLE V. BRIONES OIC-OFFICE OF THE DIRECTOR	
CONCURRED	
SHEET CONTENTS	
LOWER GROUND FLOOR SPRINKLER SYSTEM	
SHEET NUMBER	
FP	01
AS-BUILT	

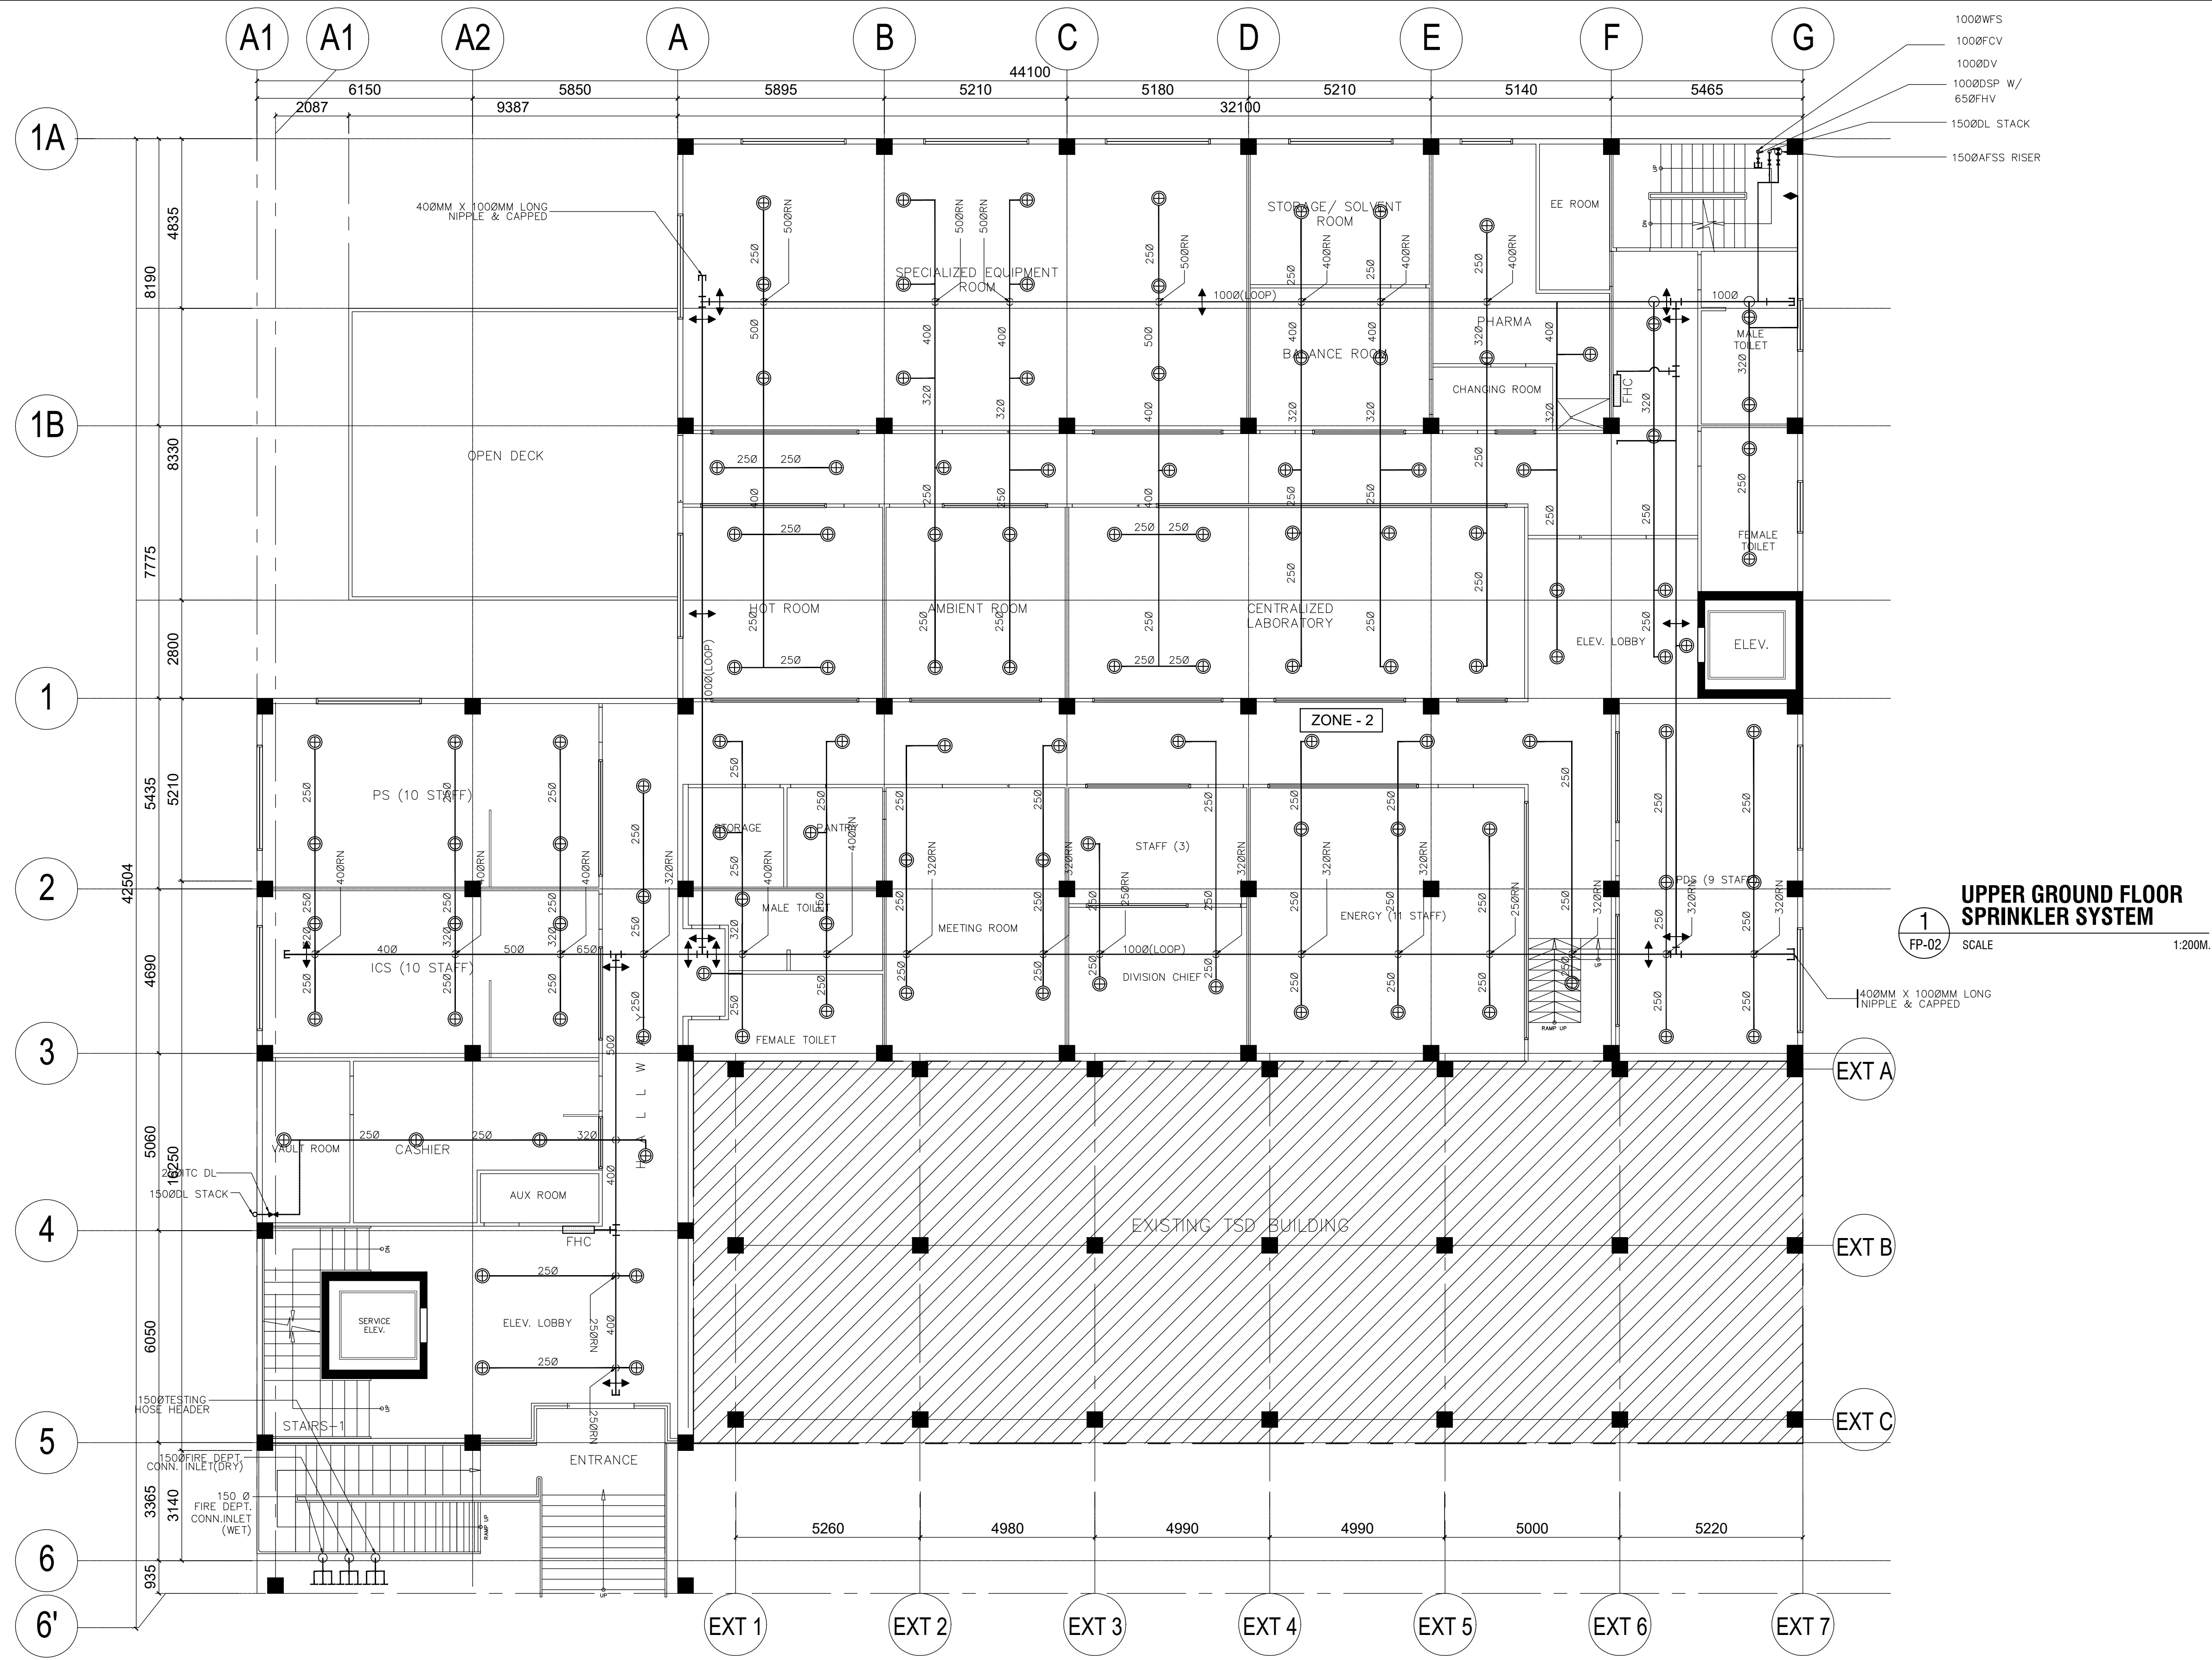


CONTRACTOR	
 OCM STEEL CORPORATION INC. A MEMBER OF THE OCM GROUP TEL. NO. 465-4386 • FAX NO. 837-2724	
ENGINEER/ ARCHITECT	
RONNEL D. CASTILLO	
PRC REG. NO. 4362	DATE: 01 / 03 / 19
PR. 7333760	PLACE: MAKATI CITY
TEL. 224-251-685	
OWNER	
 DOST-ITDI	
PROJECT NAME	
EXPANSION AND EXTENSION RENOVATION OF THE EXISTING TSD FOR THE MODULAR MULTI-INDUSTRY INNOVATION CENTER AND EXECUTIVE OFFICES LOCATION: BICUTAN, TAGUIG	
APPROVED	
ANNABELLE V. BRIONES OIC-OFFICE OF THE DIRECTOR	
CONCURRED	
SHEET CONTENTS	
UPPER GROUND FLOOR SPRINKLER SYSTEM	
SHEET NUMBER	
FP	02
AS-BUILT	

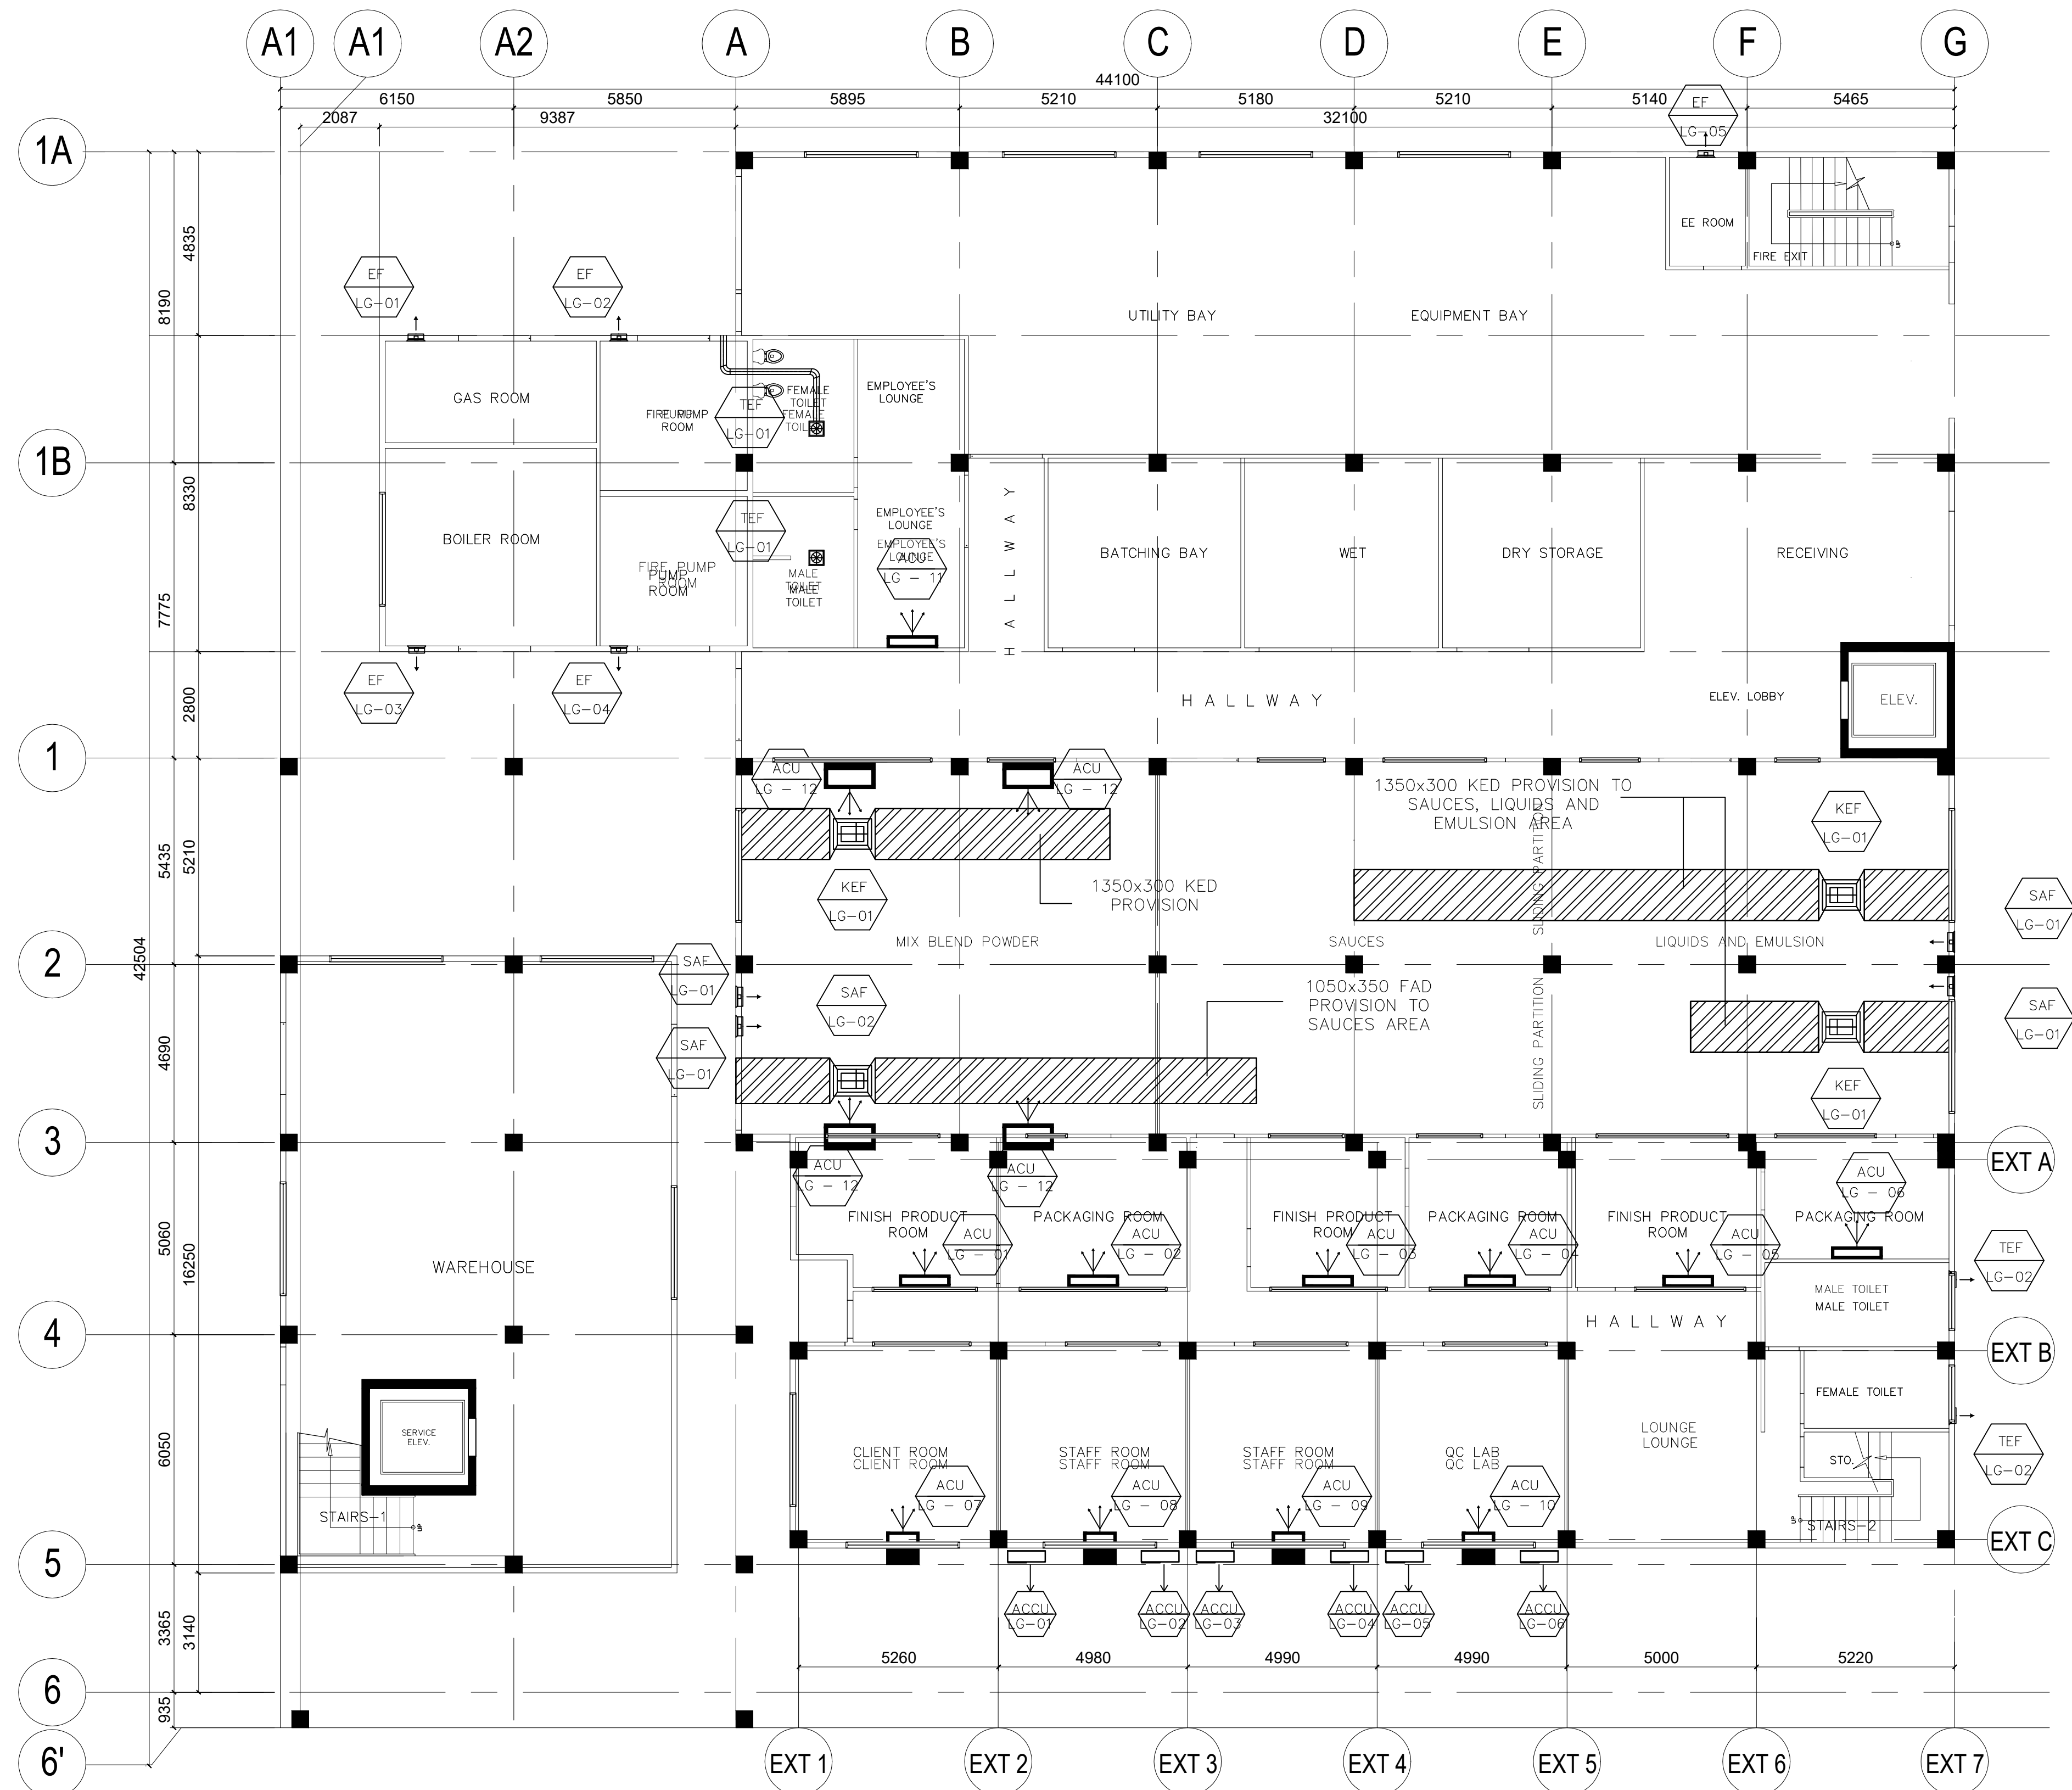

**LOWER GROUND FLOOR
AIR-CONDITIONING LAYOUT**
01
M-01 SCALE 1:200M.


CONTRACTOR	
 OCM STEEL CORPORATION INCORPORATED IN THE PHILIPPINES • 100% PHILIPPINE OWNED • 100% LOCAL CONTENT TEL. NO. 465-4396 • 465-4398 FAX NO. 937-2724	
ENGINEER	
RONNEL D. CASTILLO	
PROJECT NAME	
EXPANSION AND EXTENSION RENOVATION OF THE EXISTING TSD FOR THE MODULAR MULTI-INDUSTRY INNOVATION CENTER AND EXECUTIVE OFFICES LOCATION: BICUTAN, TAGUIG	
APPROVED	
ANNABELLE V. BRIONES OIC-OFFICE OF THE DIRECTOR	
CONCURRED	
SHEET CONTENTS	
UPPER GROUND FLOOR AIR-CONDITIONING LAYOUT	
SHEET NUMBER	
M	01
AS-BUILT	

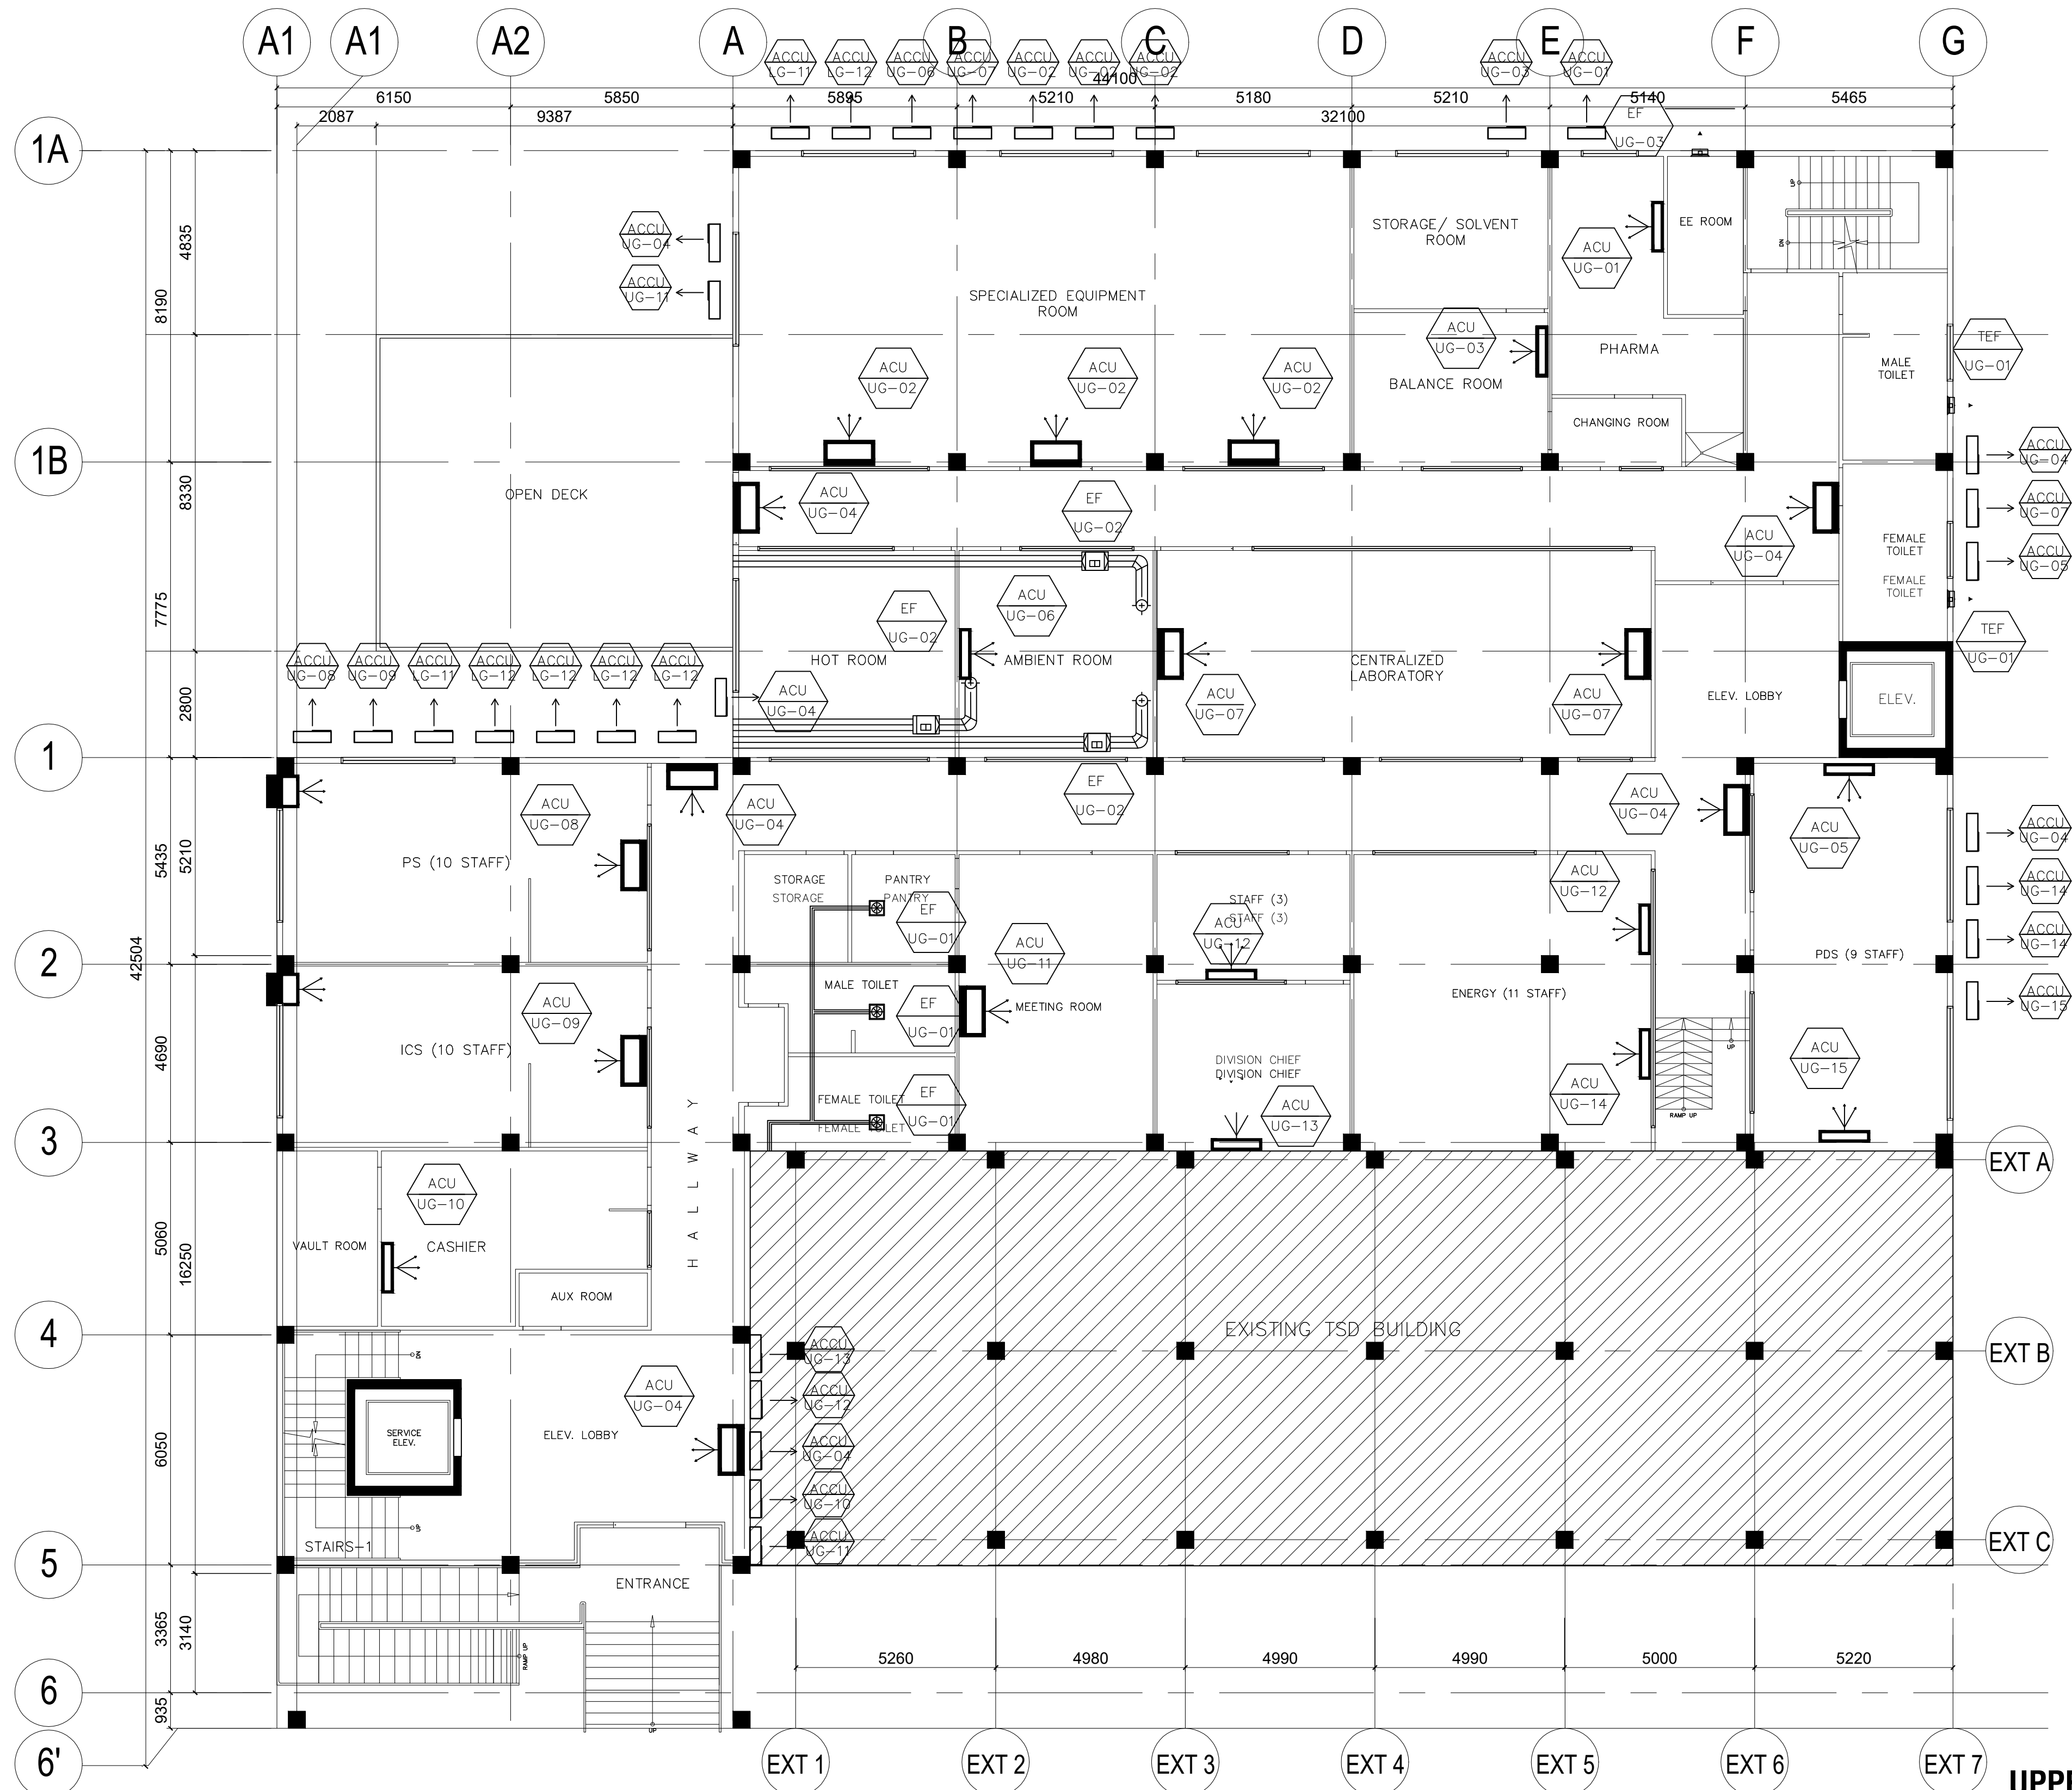

UPPER GROUND FLOOR
AIR-CONDITIONING LAYOUT

01
M-02 SCALE 1:200M.

CONTRACTOR	
 OCM STEEL CORPORATION 110-A, INDUSTRIAL ZONE, BAYAN LEPAS, P.O. BOX 100, BAYAN LEPAS, PENANG 11000 MALAYSIA TEL. NO. 465-4386 / 465-4388 FAX NO. 937-2724	
ENGINEER	
RONNEL D. CASTILLO	
PROJECT NAME	
EXPANSION AND EXTENSION RENOVATION OF THE EXISTING TSD FOR THE MODULAR MULTI-INDUSTRY INNOVATION CENTER AND EXECUTIVE OFFICES LOCATION: BICUTAN, TAGUIG	
APPROVED	
ANNABELLE V. BRIONES OIC-OFFICE OF THE DIRECTOR	
CONCURRED	
SHEET CONTENTS	
UPPER GROUND FLOOR AIR-CONDITIONING LAYOUT	
SHEET NUMBER	
M	02
AS-BUILT	

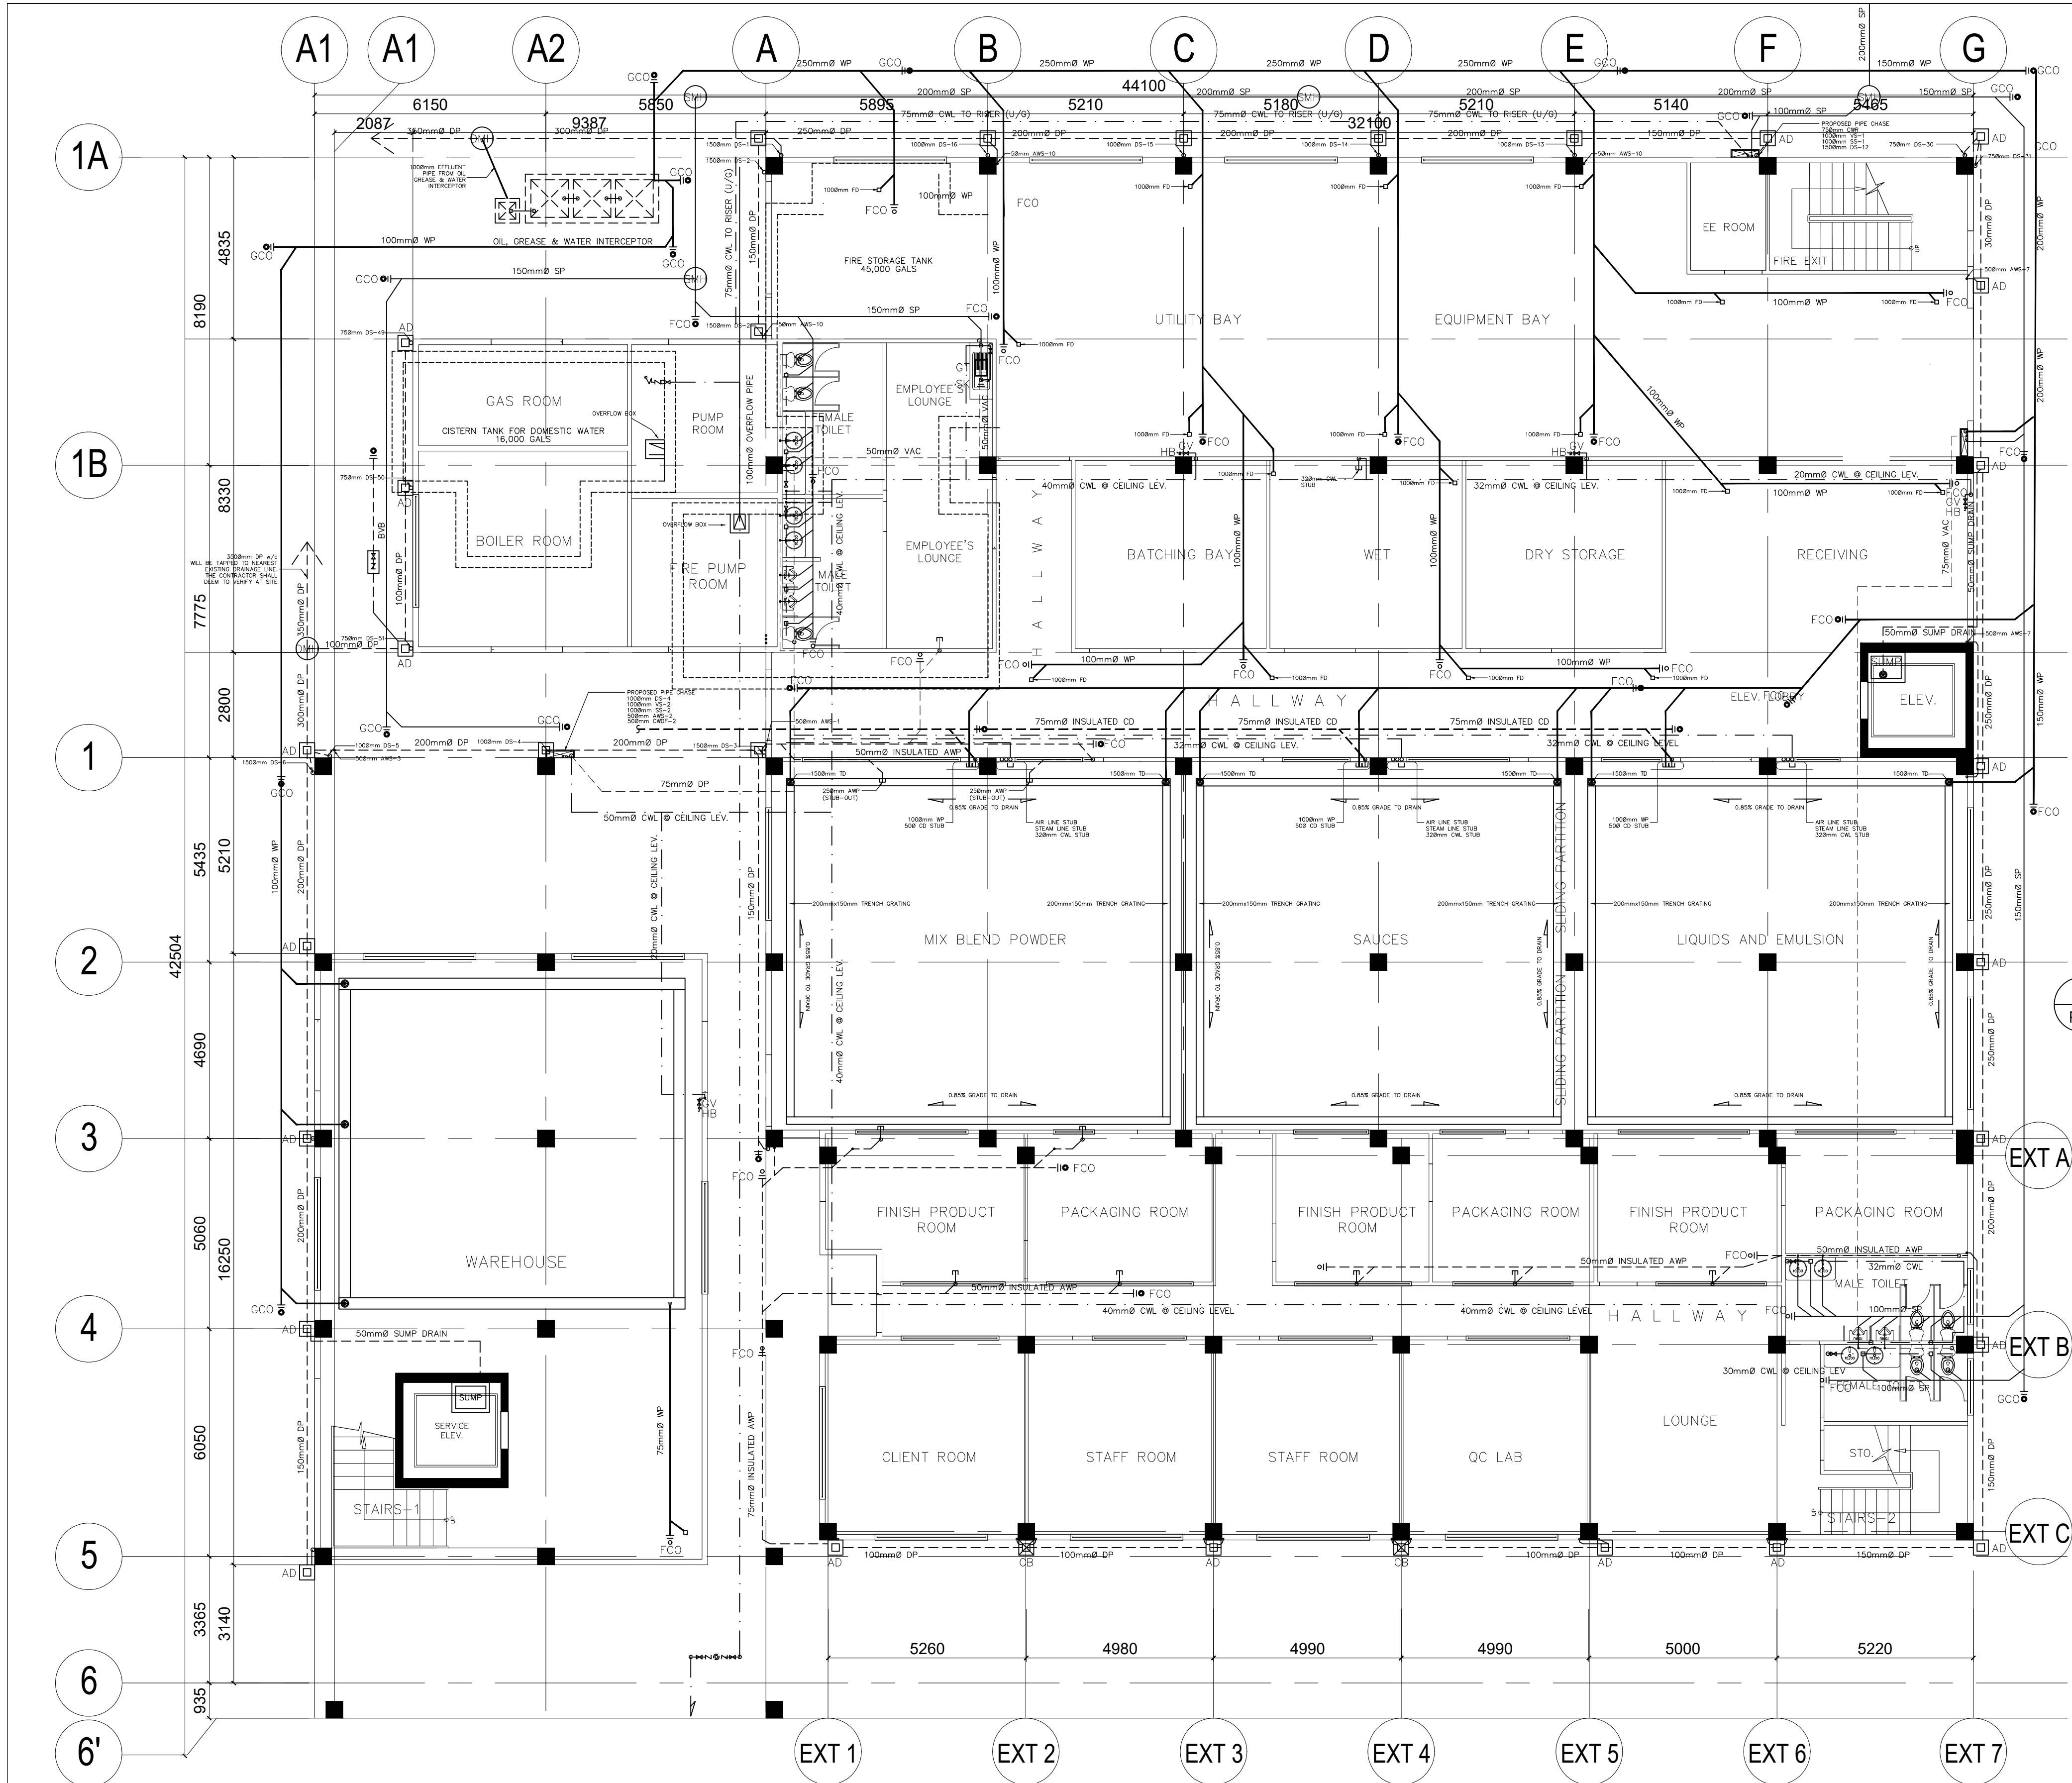


**LOWER GROUND FLOOR
SANITARY & PLUMBING**
1
P-01 SCALE 1:200M.

CONTRACTOR	
	
ENGINEER/ ARCHITECT	
ROGER M. BAUTISTA	
PRC REG. NO. 3761 FIR. 11262525 TJN. 122-584-360	DATE: 01 / 03 / 19 PLACE: RIZAL
OWNER	
	
PROJECT NAME	
EXPANSION AND EXTENSION RENOVATION OF THE EXISTING TSD FOR THE MODULAR MULTI-INDUSTRY INNOVATION CENTER AND EXECUTIVE OFFICES LOCATION: BICUTAN, TAGUIG	
APPROVED	
ANNABELLE V. BRIONES OIC-OFFICE OF THE DIRECTOR	
CONCURRED	
SHEET CONTENTS	
LOWER GROUND FLOORPLAN SANITARY & PLUMBING LAYOUT	
SHEET NUMBER	
P	01
AS-BUILT	



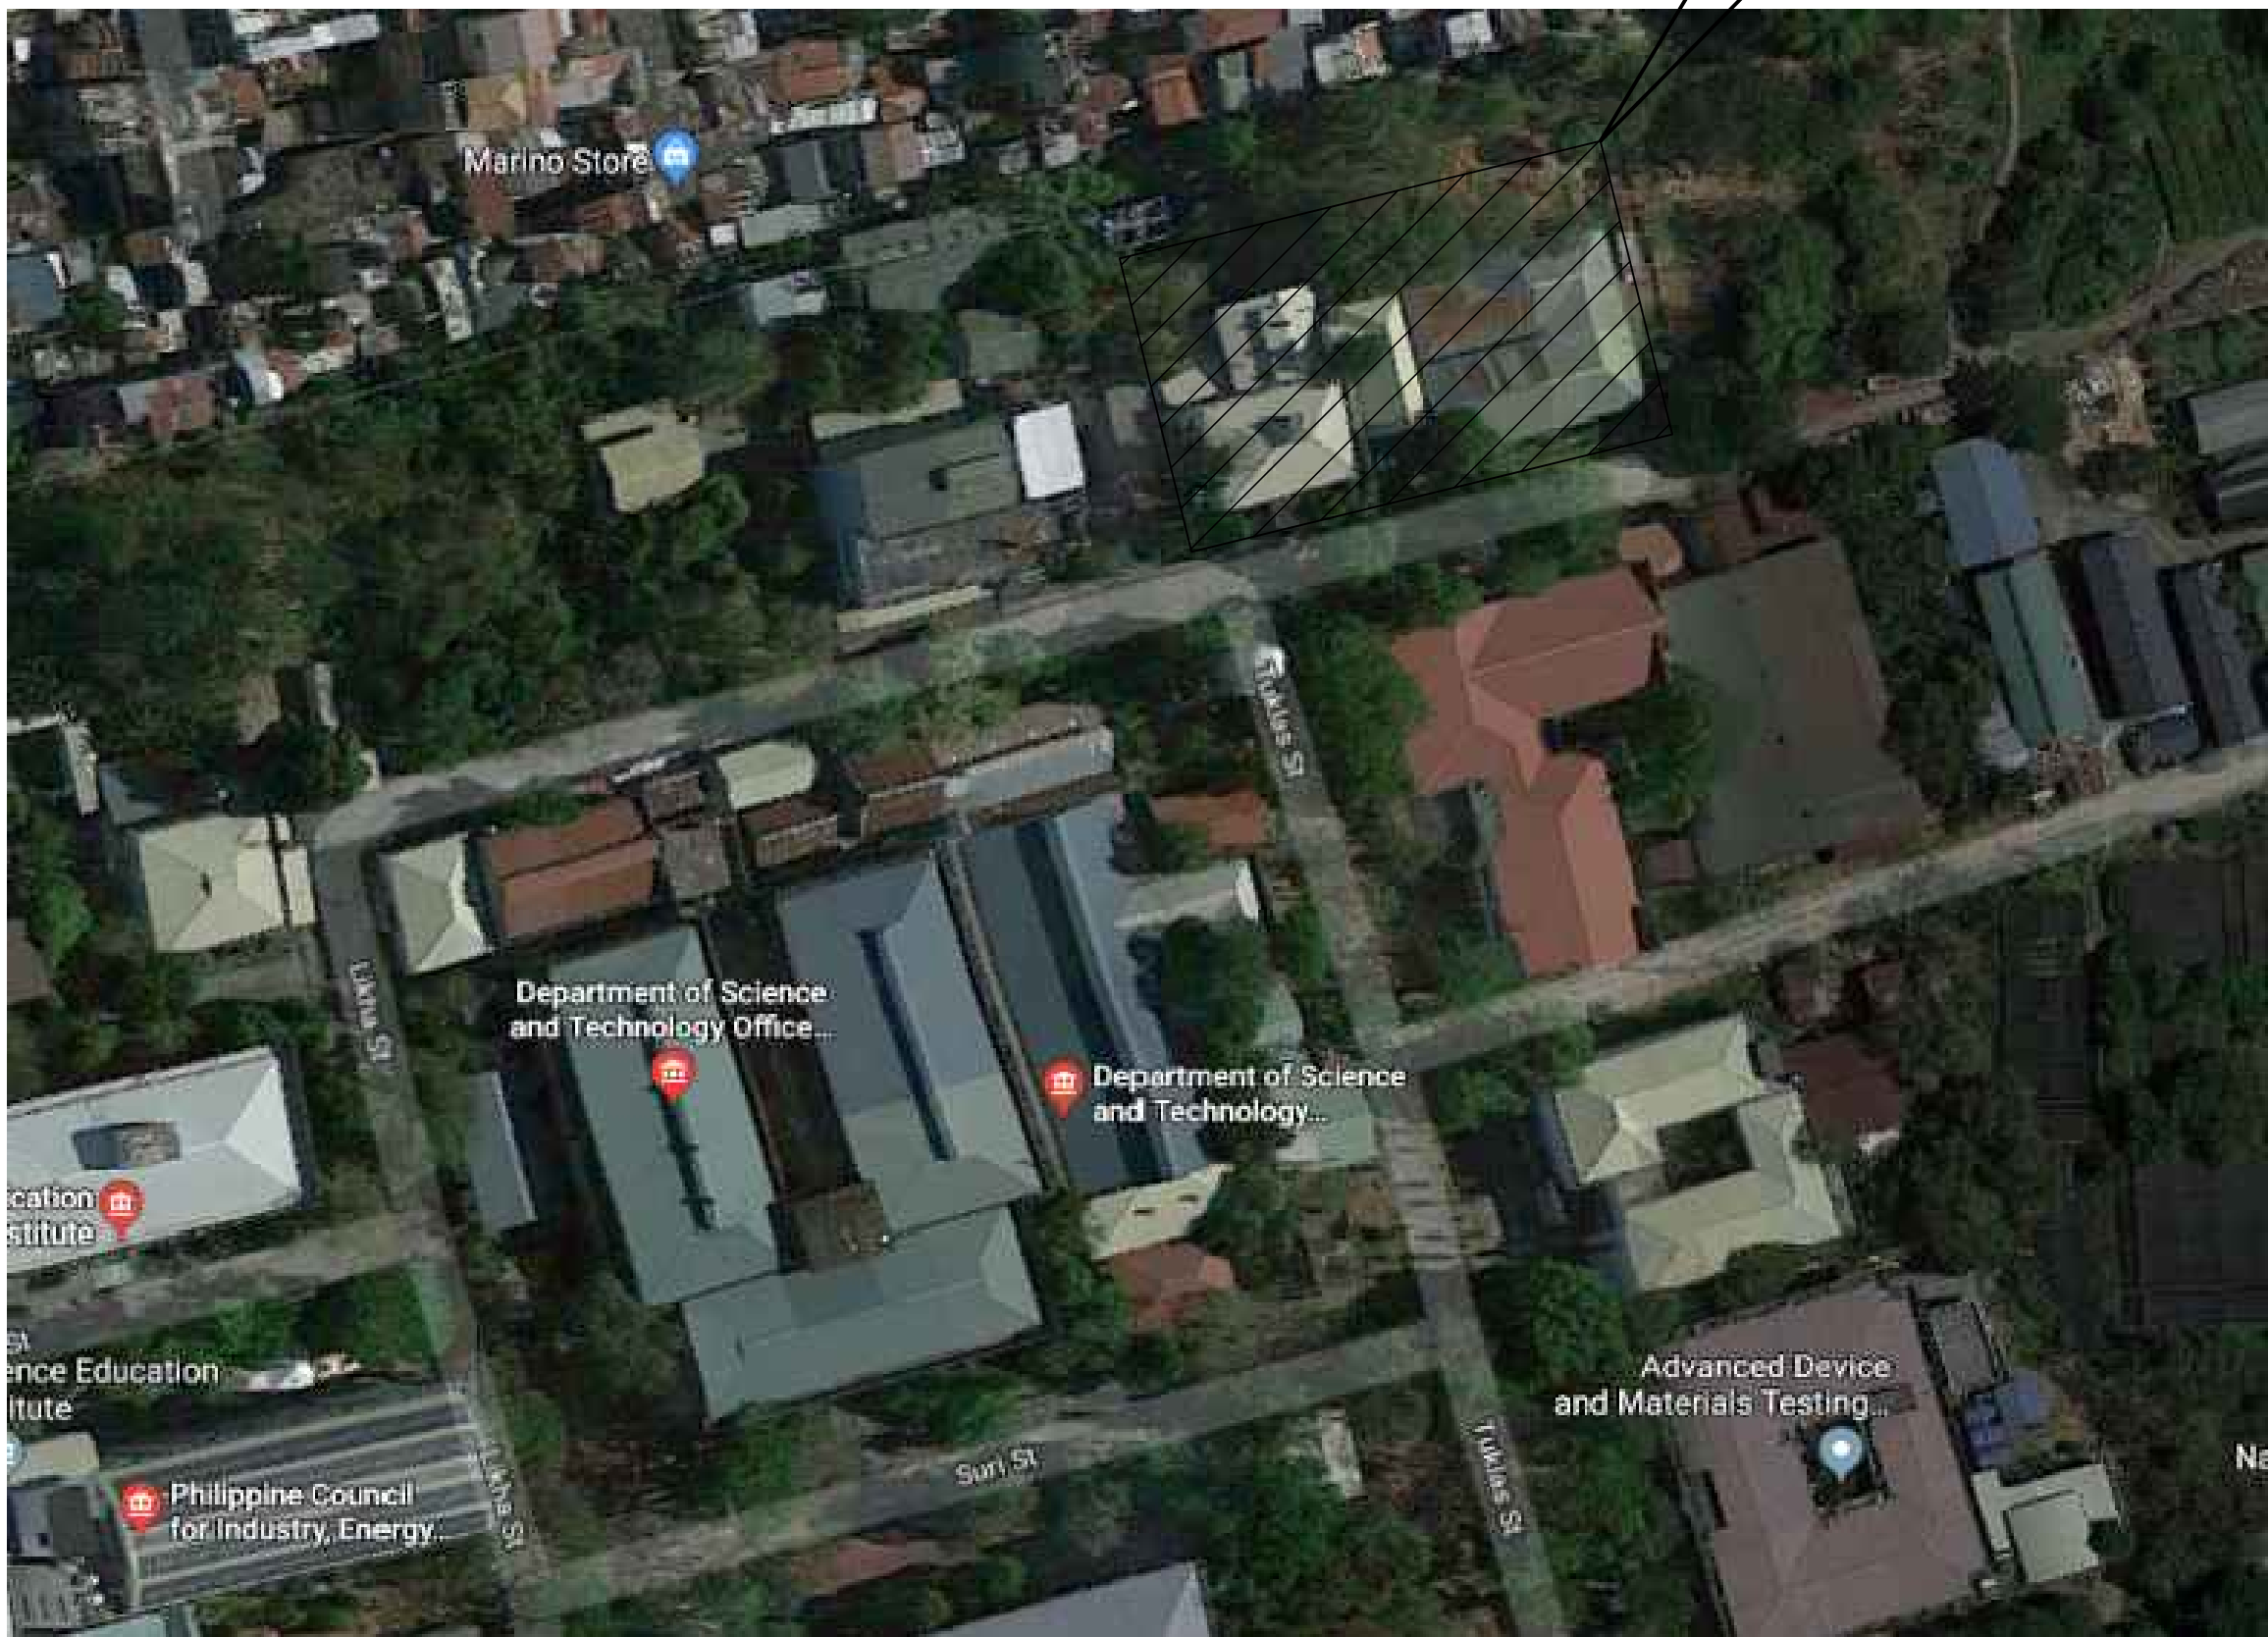THE SITE



01 PROPOSED EXTERIOR PERSPECTIVE
A-01 SCALE NTS

02 VICINITY MAP
A-01 SCALE NTS

DEPARTMENT OF PUBLIC WORKS
AND HIGHWAYS

OFFICE OF THE BUILDING OFFICIAL

CONTRACTOR

O C M STEEL CORPORATION
NO. 24 WOODLARK LANE, WOODLARK, NEW TOWN, PAMPANGA, GUANZAPIL CITY
TEL. NO. 462-6381 / 462-6382 FAX NO. 937-2724

OWNER

DOST-ITDI

PROJECT NAME

EXPANSION AND EXTENSION
RENOVATION OF THE EXISTING TSD
FOR THE MODULAR MULTI-INDUSTRY
INNOVATION CENTER AND
EXECUTIVE OFFICES

LOCATION: BICUTAN, TAGUIG

APPROVED


ANNABELLE V. BRIONES
OIC-OFFICE OF THE DIRECTOR

SHEET NUMBER


A

01

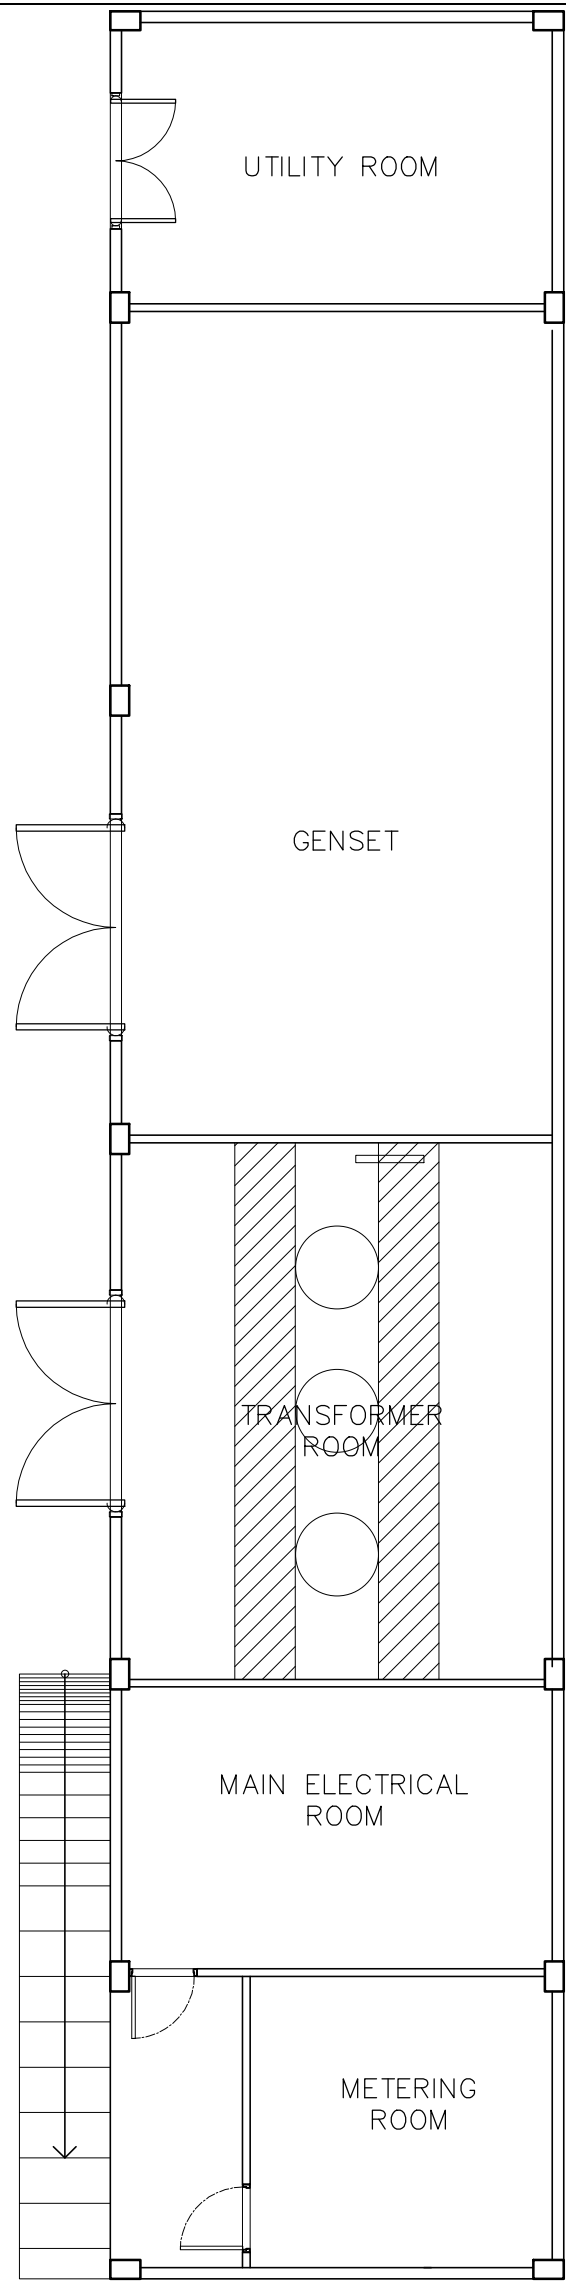AS-BUILT



AS-BUILT

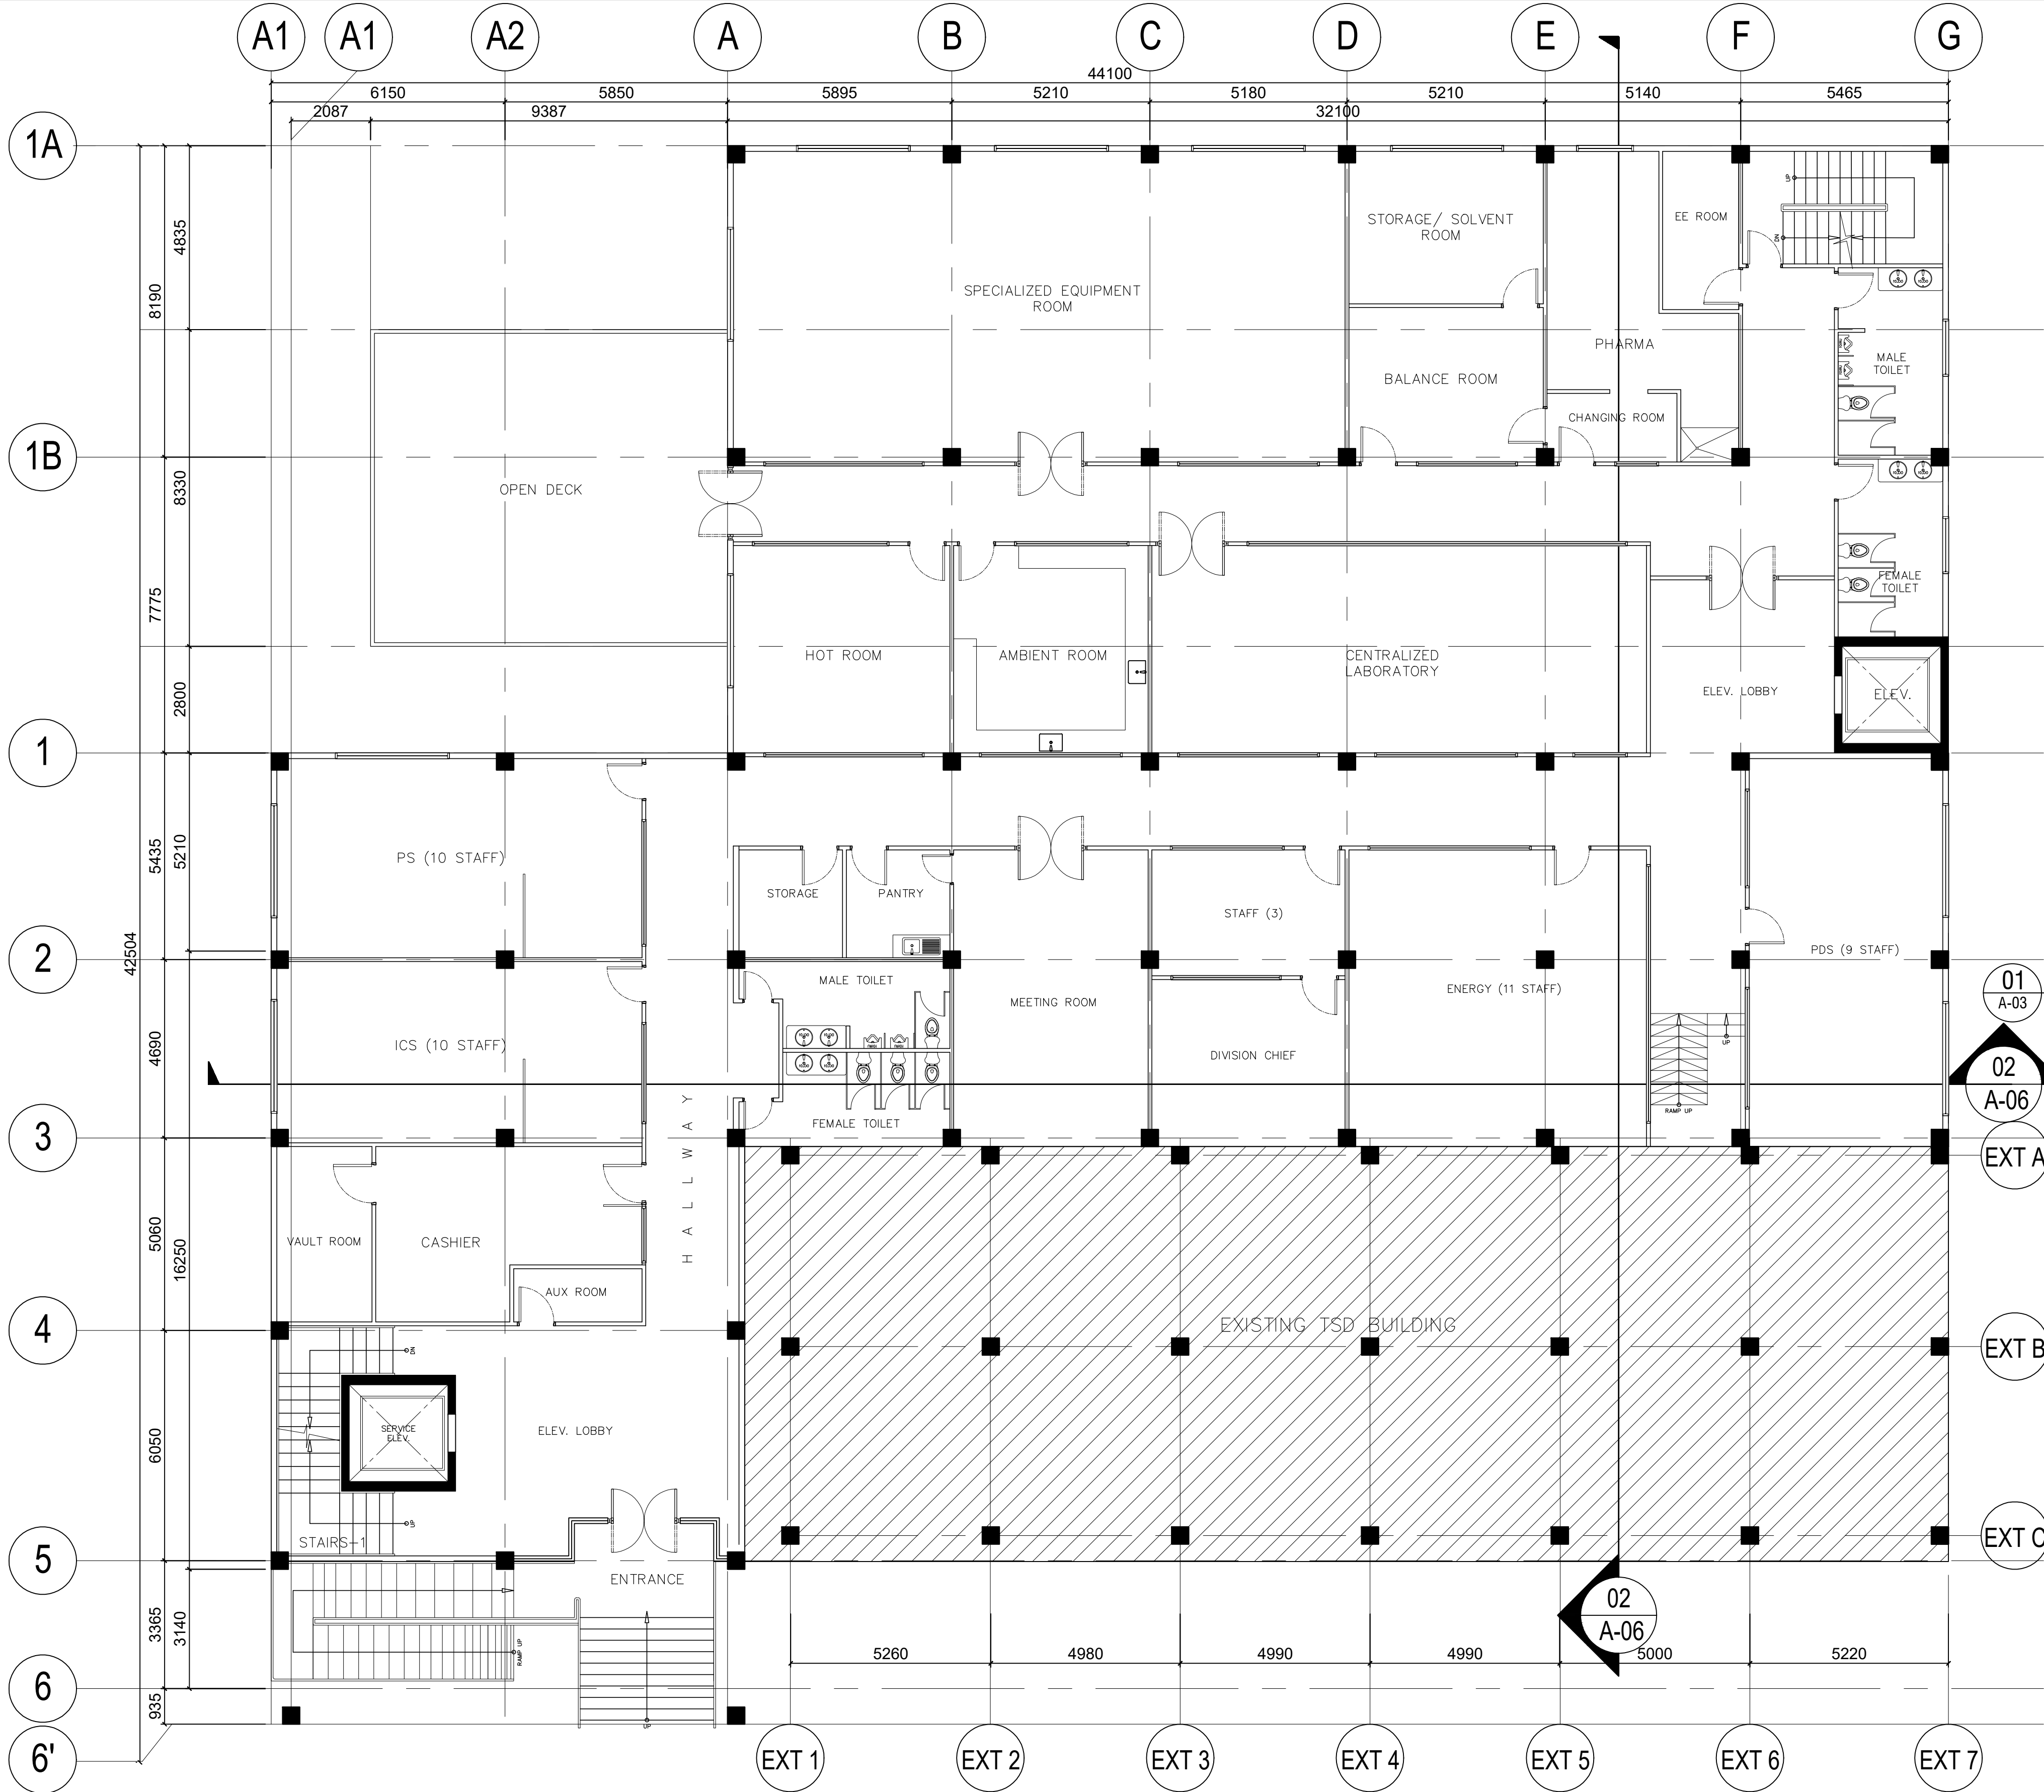

01
A-03
UPPER GROUND FLOOR PLAN
SCALE 1:200M.


02
A-06

EXT A

EXT B


EXT C

CONTRACTOR	
	
CIVIL ENGINEER	
EMMANUEL D. AGDA	
PRC REG. NO. 0114252 P.R. 7377945 T.N. 400-460-256	DATE: 01 / 09 / 19 PLACE: QUEZON CITY
OWNER	
	
PROJECT NAME	
EXPANSION AND EXTENSION RENOVATION OF THE EXISTING TSD FOR THE MODULAR MULTI-INDUSTRY INNOVATION CENTER AND EXECUTIVE OFFICES LOCATION: BICUTAN, TAGUIG	
APPROVED	
ANNABELLE V. BRIONES OIC-OFFICE OF THE DIRECTOR	
CONCURRED	
SHEET CONTENTS	
UPPER GROUND FLOORPLAN	
SHEET NUMBER	
A	03
AS-BUILT	

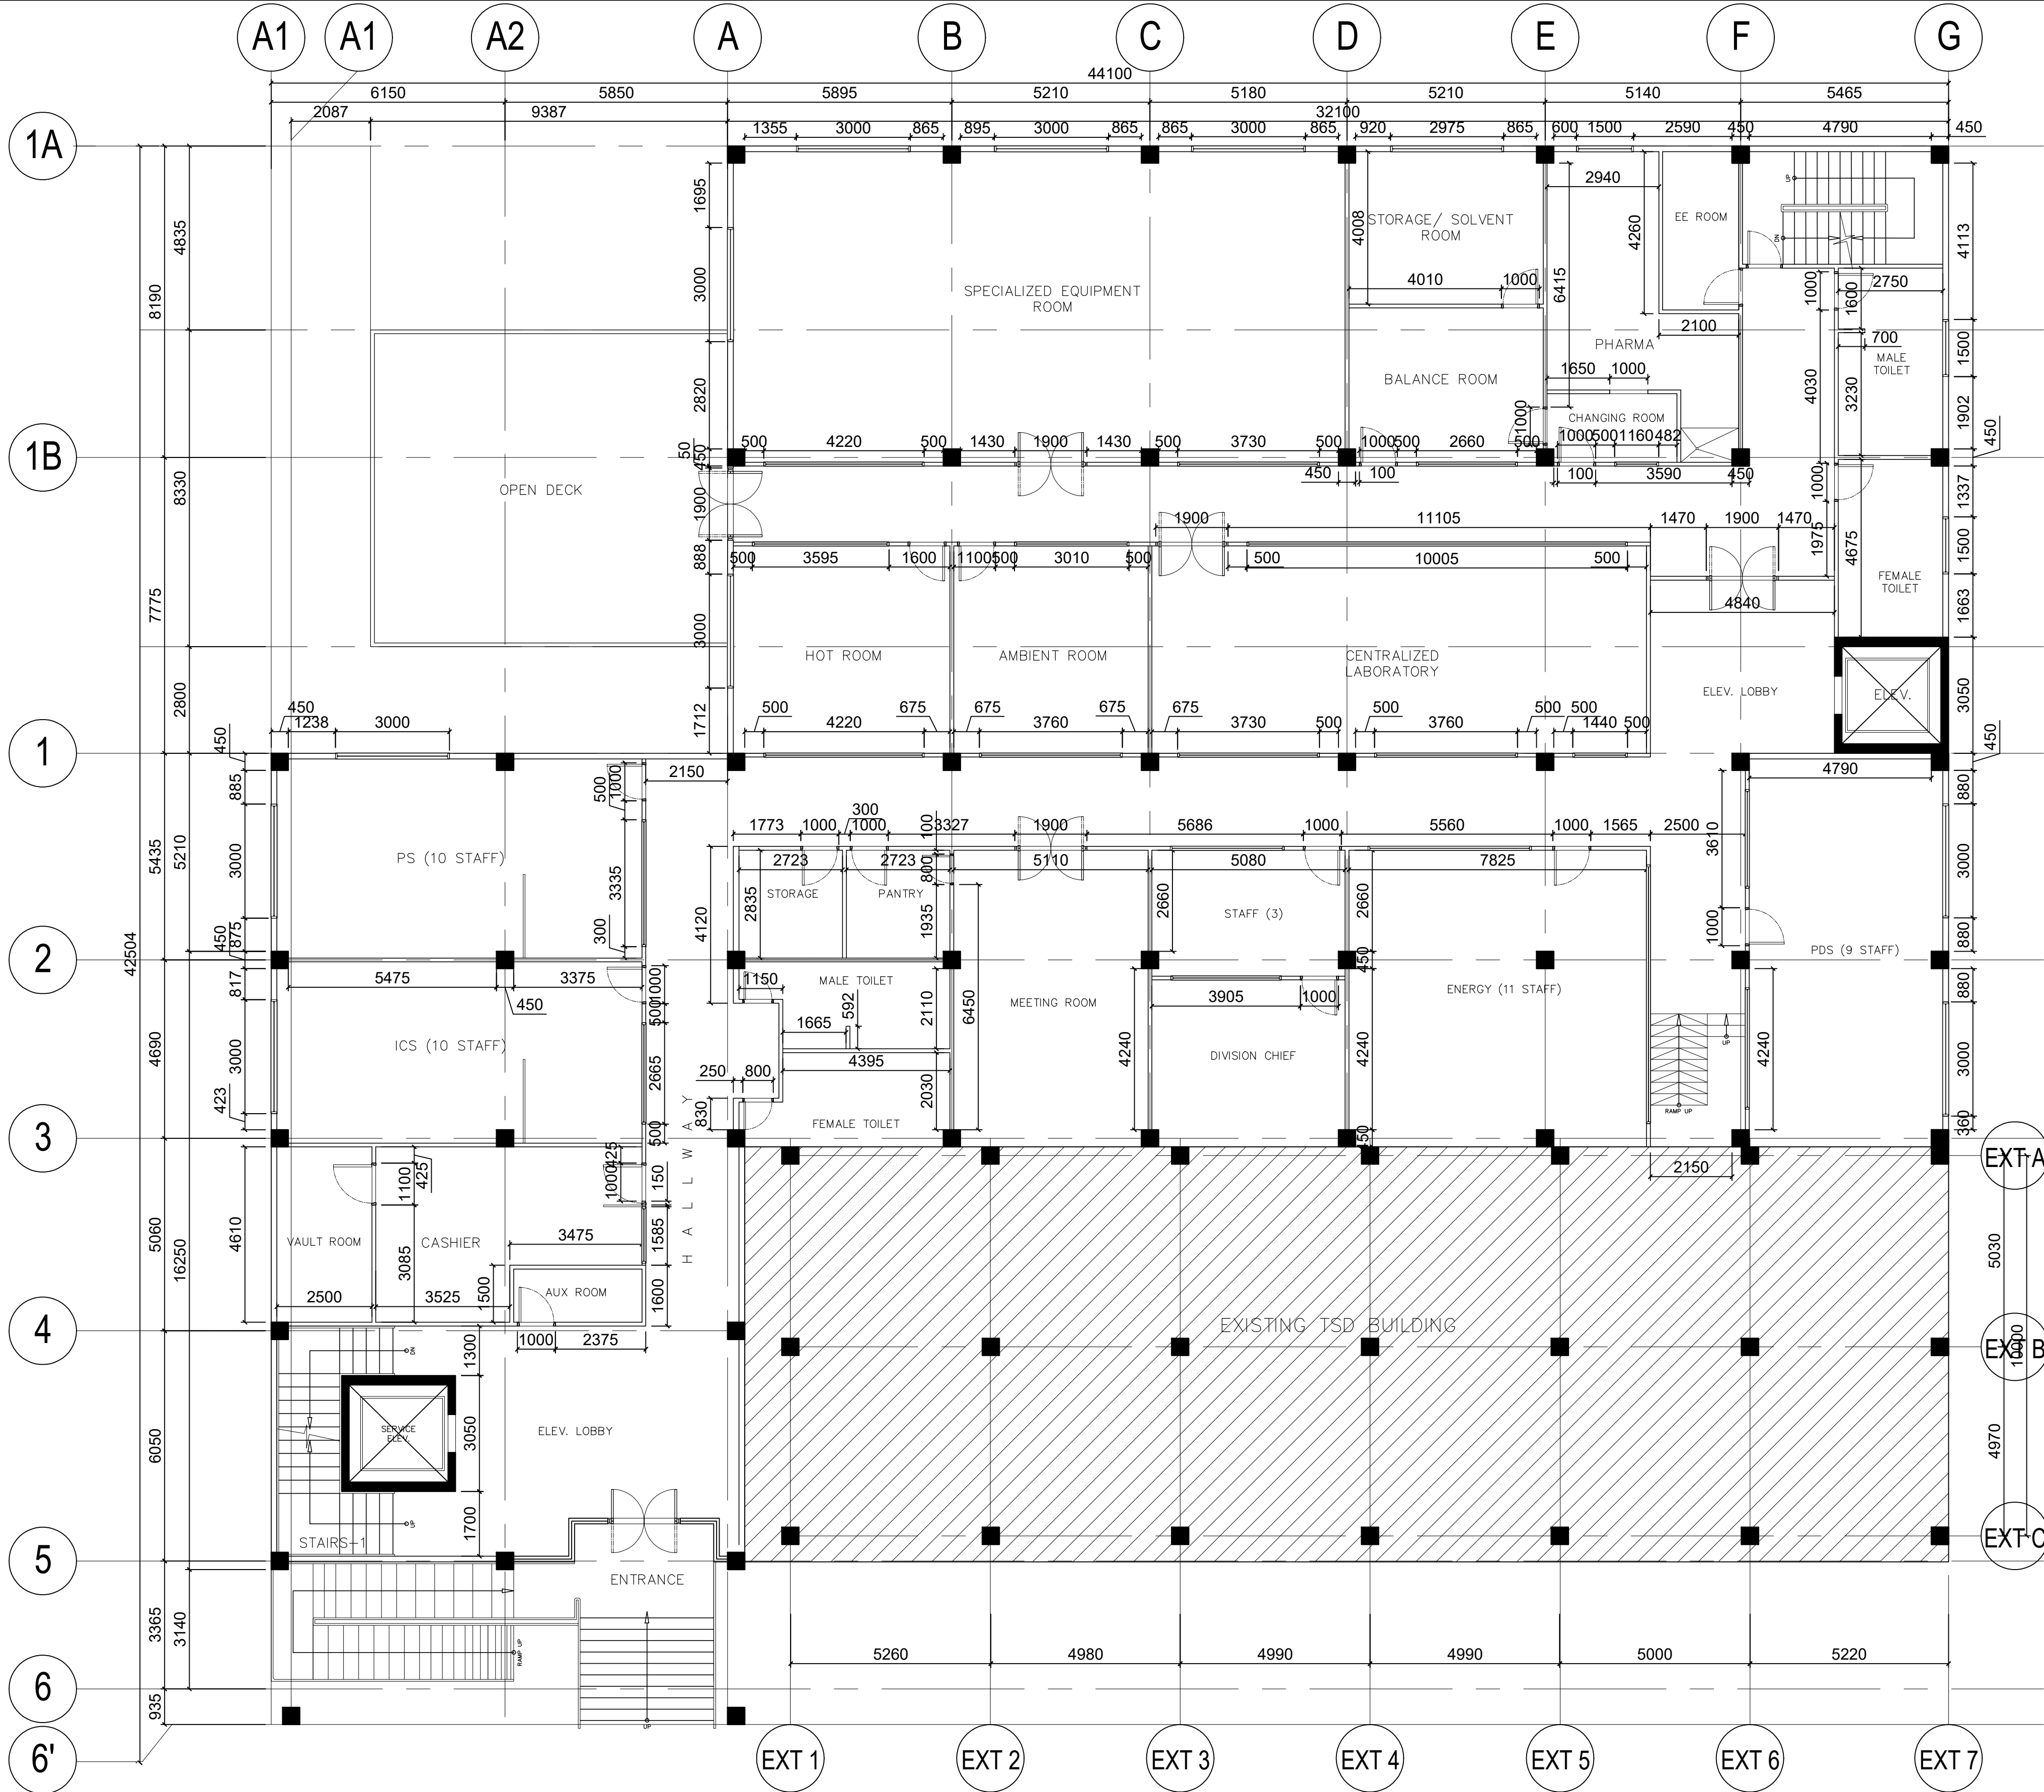


01
A-05
UPPER GROUND
WALL SETTING OUT
SCALE 1:200M.

CONTRACTOR	
	
CIVIL ENGINEER	
EMMANUEL D. AGDA	
PRC REG. NO. 0114252	DATE: 01 / 09 / 19
P.R. 7377945	PLACE: QUEZON CITY
OWNER	
	
PROJECT NAME	
EXPANSION AND EXTENSION RENOVATION OF THE EXISTING TSD FOR THE MODULAR MULTI-INDUSTRY INNOVATION CENTER AND EXECUTIVE OFFICES LOCATION: BICUTAN, TAGUIG	
APPROVED	
ANNABELLE V. BRIONES OIC-OFFICE OF THE DIRECTOR	
CONCURRED	
SHEET CONTENTS	
UPPER GROUND WALL SETTING OUT	
SHEET NUMBER	
A	05
AS-BUILT	














































































































































































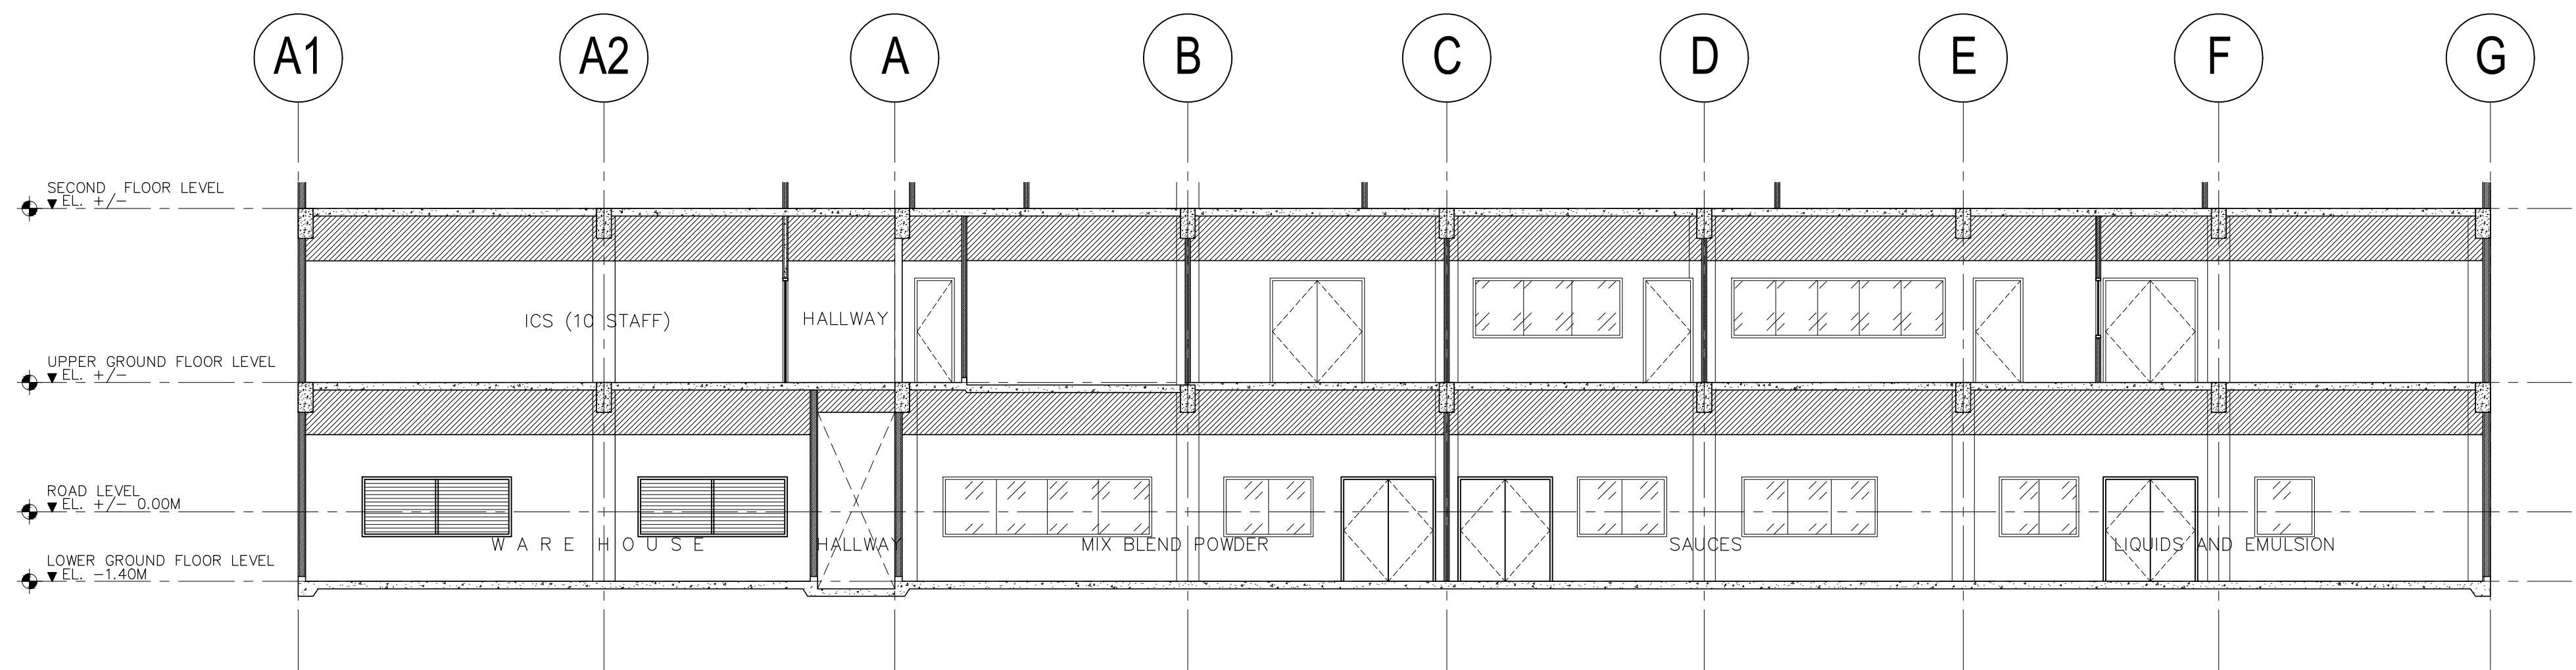



02 CROSS-SECTION
A-06 SCALE 1:200M.

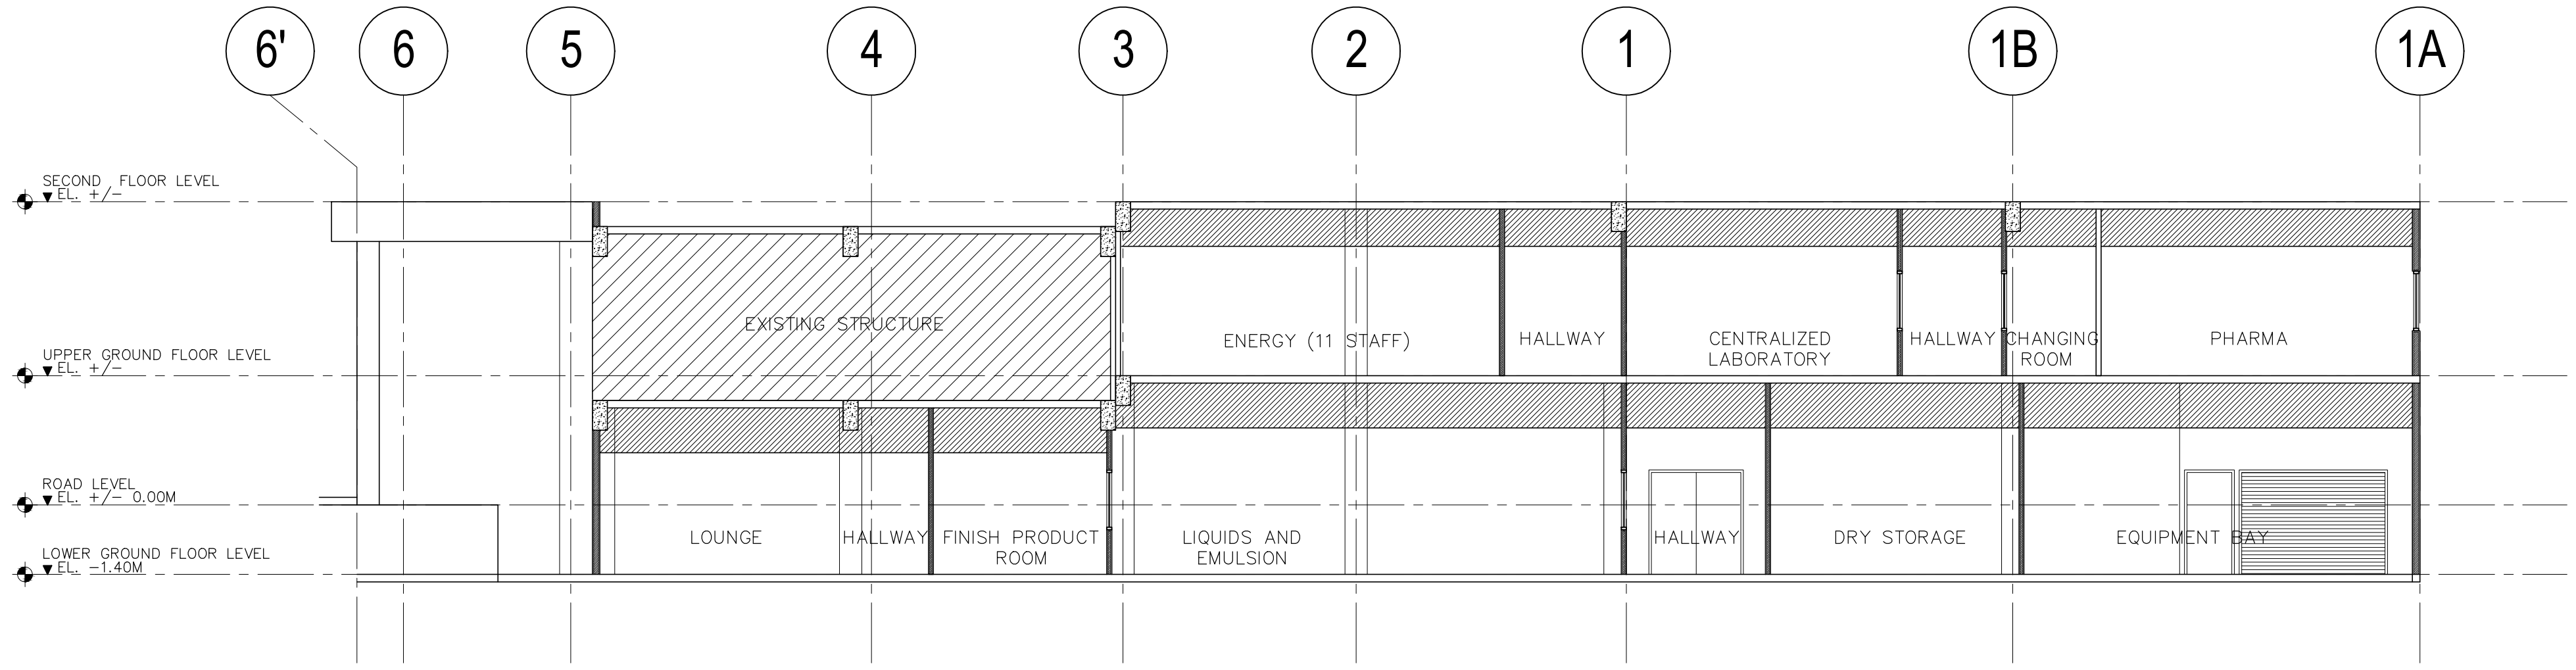


01 LONGITUDINAL SECTION
A-06 SCALE 1:200M.

CONTRACTOR	
	
ENGINEER/ ARCHITECT	
EMMANUEL D. AGDA	
PRC REG. NO. 0114252 DATE: 01 / 09 / 19	
FIR. 7577945	
TEL. 400-460-256 PLACE: QUEZON CITY	
OWNER	
	
PROJECT NAME	
EXPANSION AND EXTENSION RENOVATION OF THE EXISTING TSD FOR THE MODULAR MULTI-INDUSTRY INNOVATION CENTER AND EXECUTIVE OFFICES LOCATION: BICUTAN, TAGUIG	
APPROVED	
ANNABELLE V. BRIONES OIC-OFFICE OF THE DIRECTOR	
CONCURRED	
SHEET CONTENTS	
CROSS SECTION LONGITUDINAL SECTION	
SHEET NUMBER	
A	06
AS-BUILT	

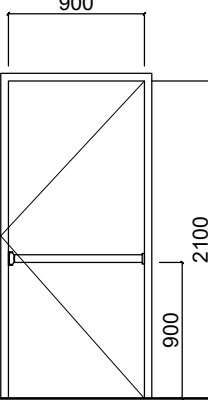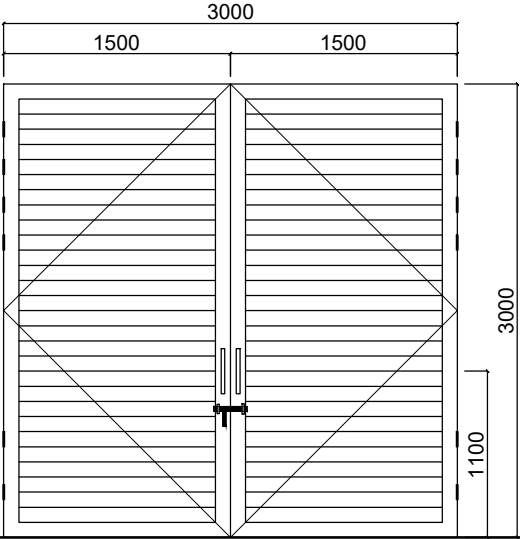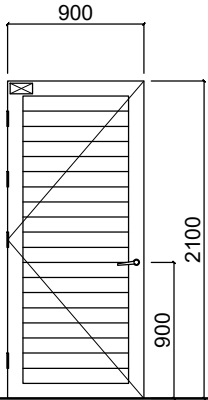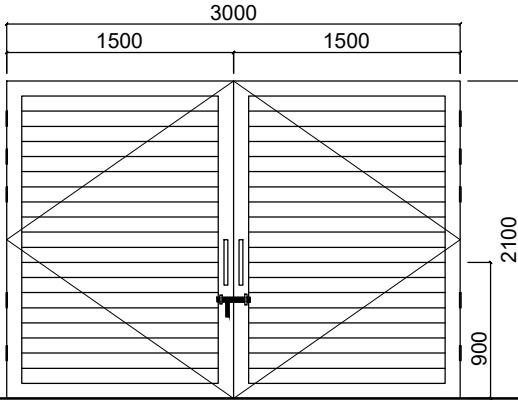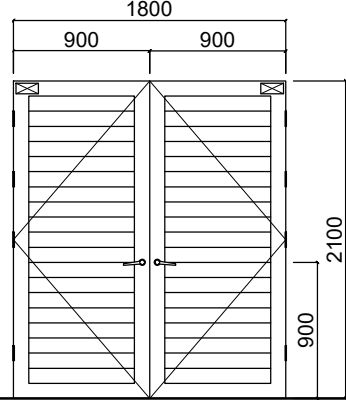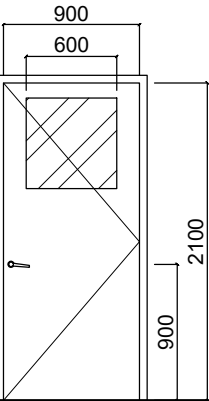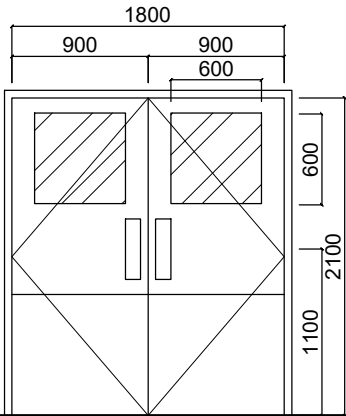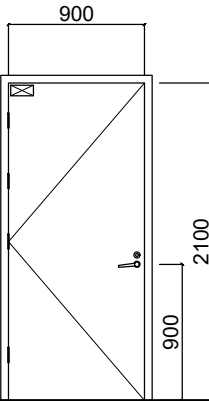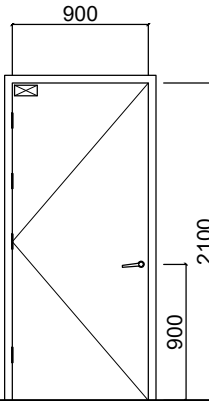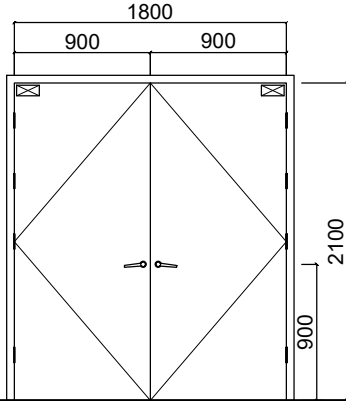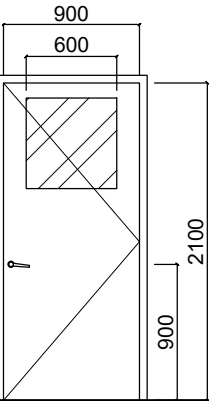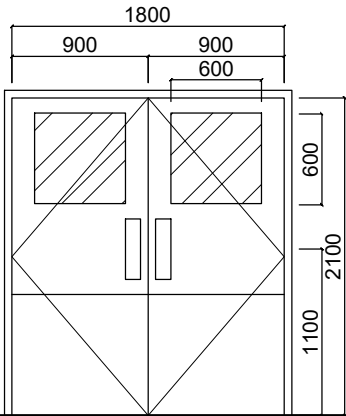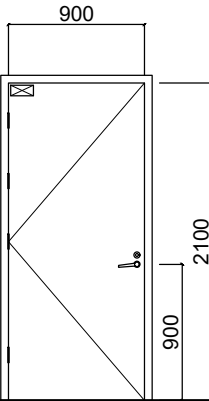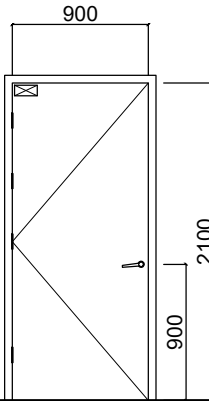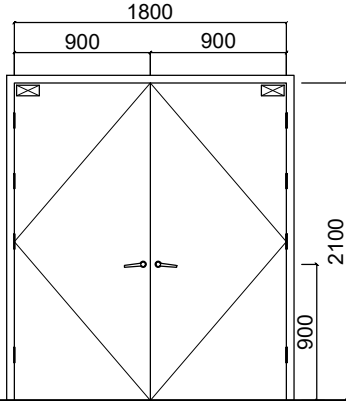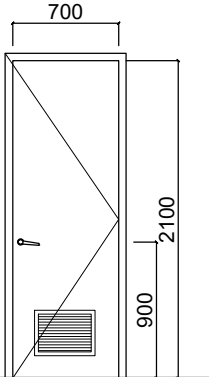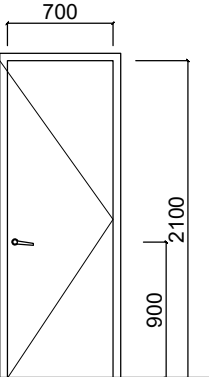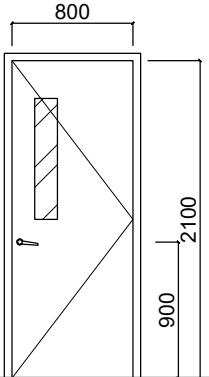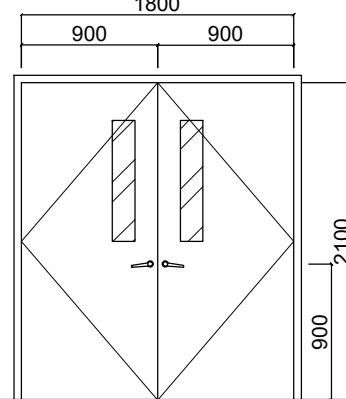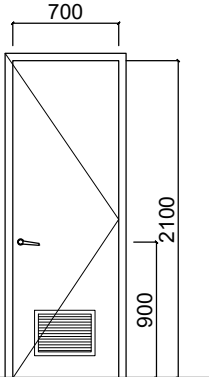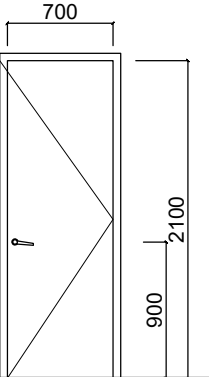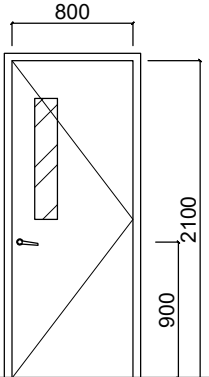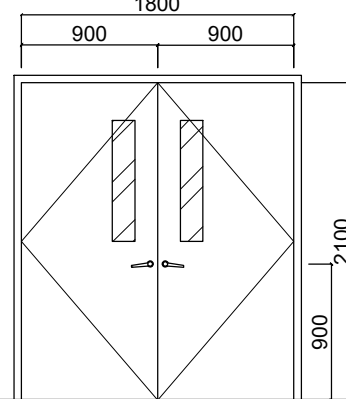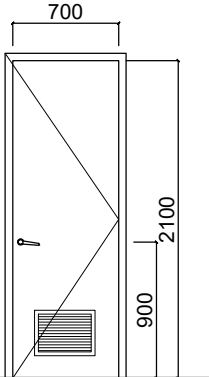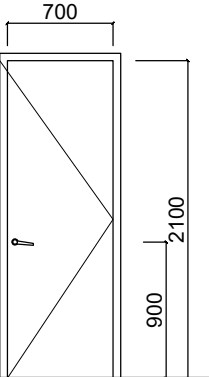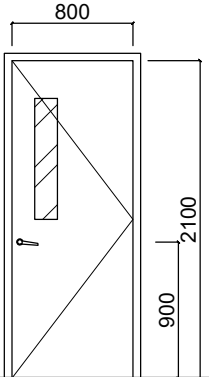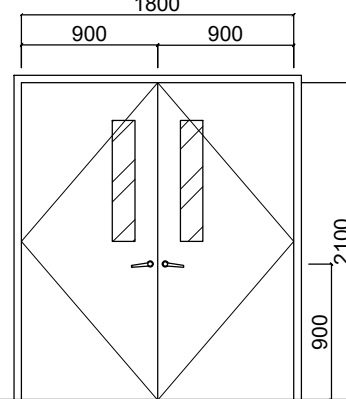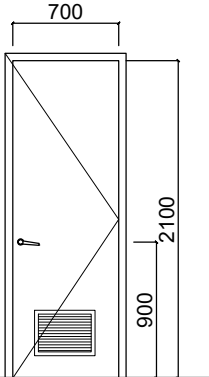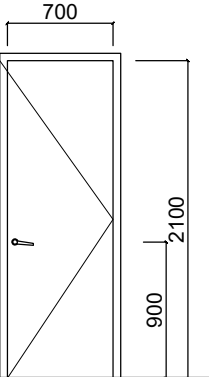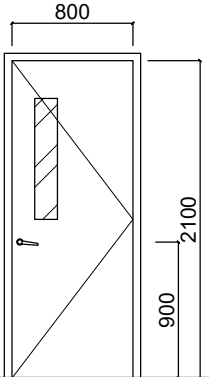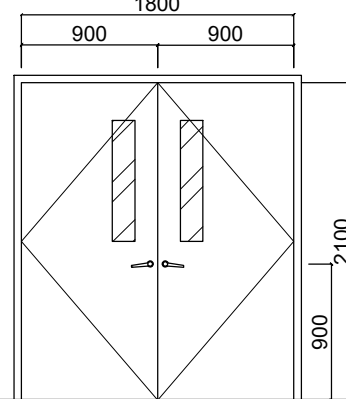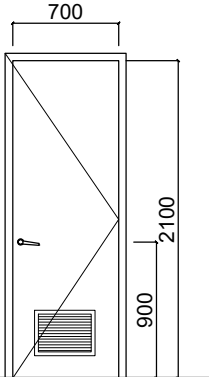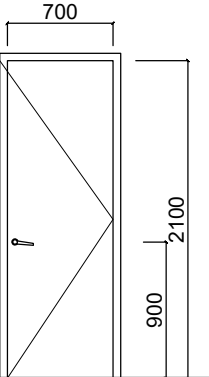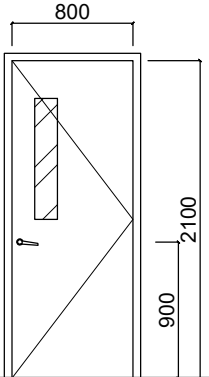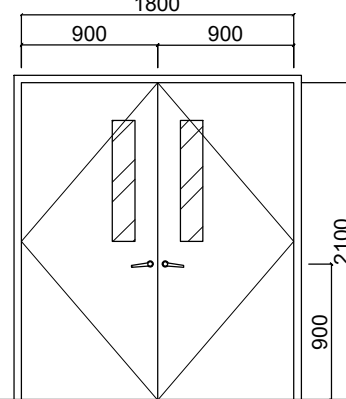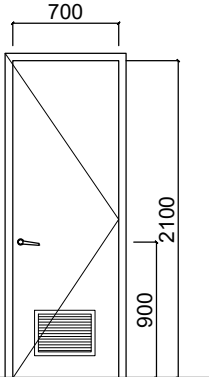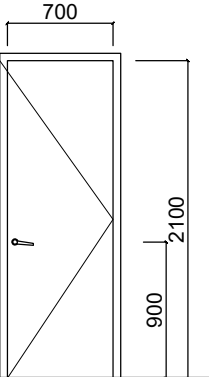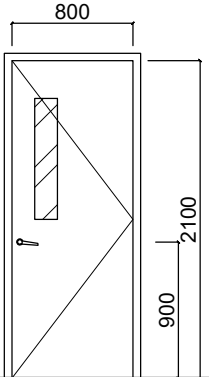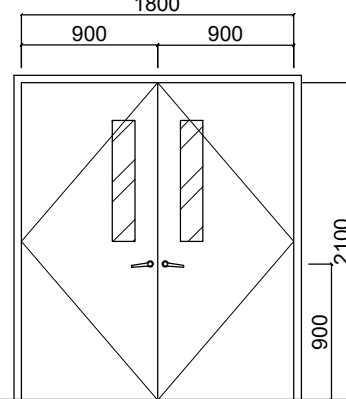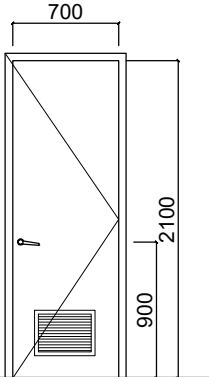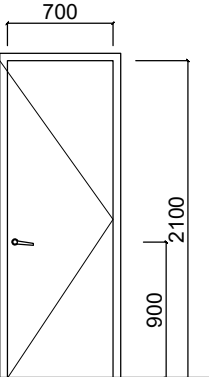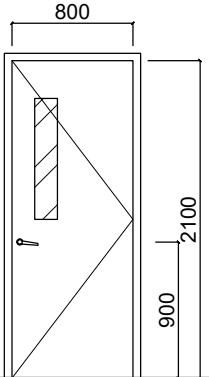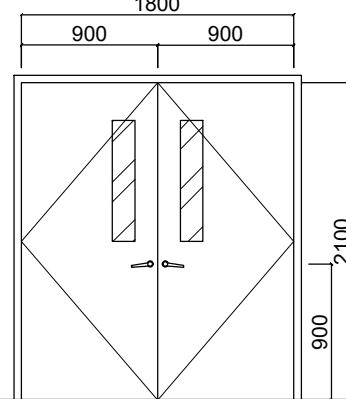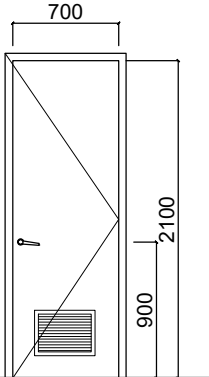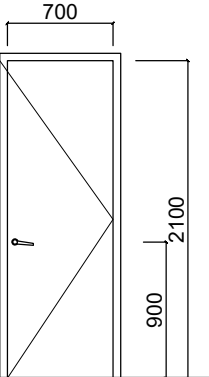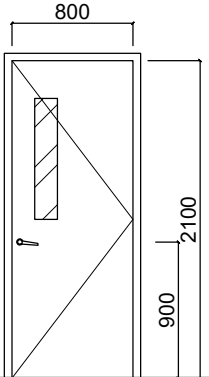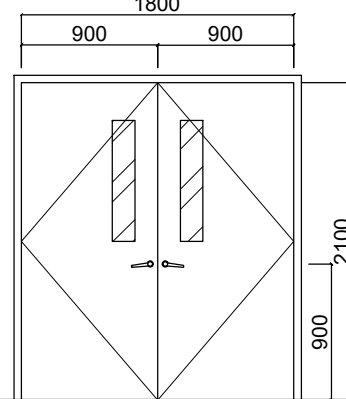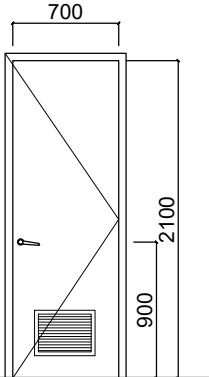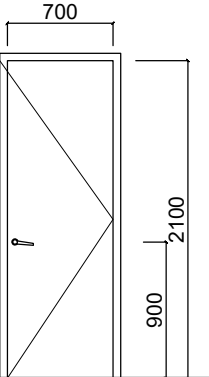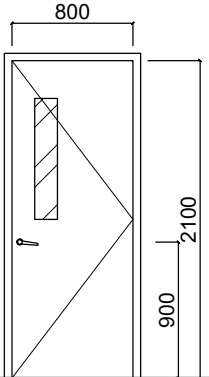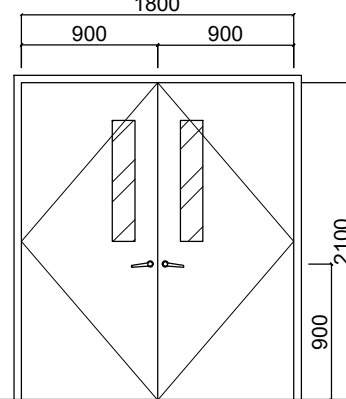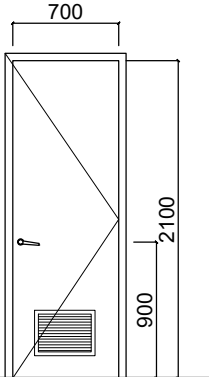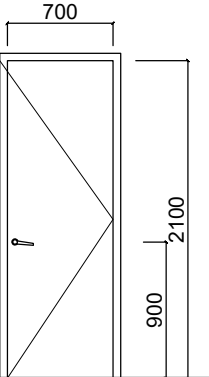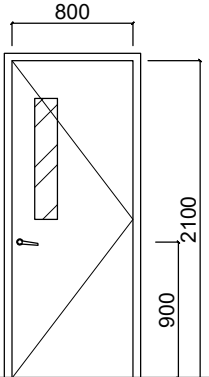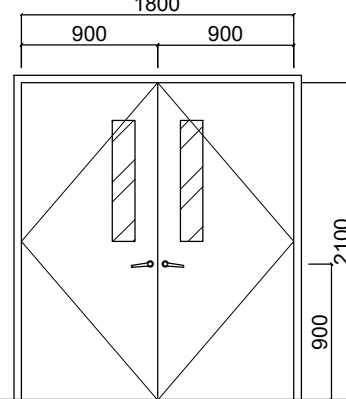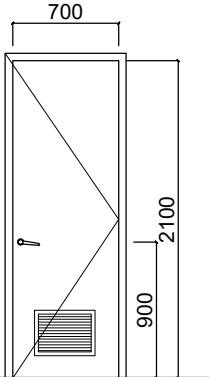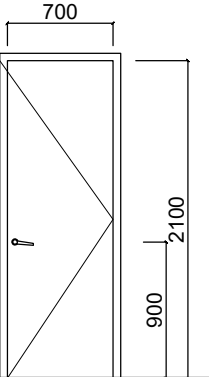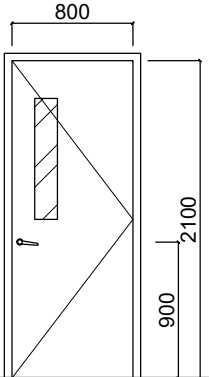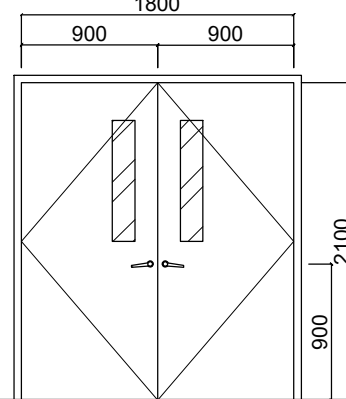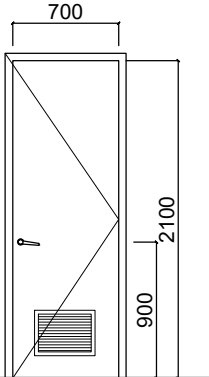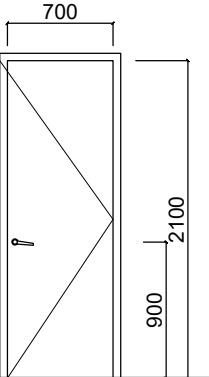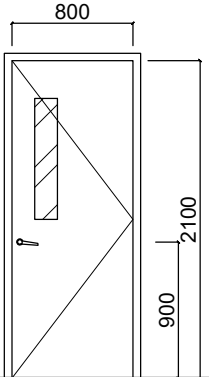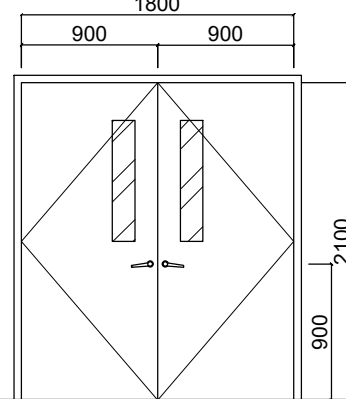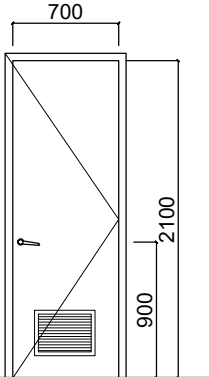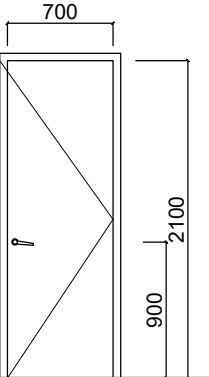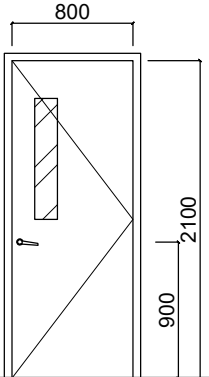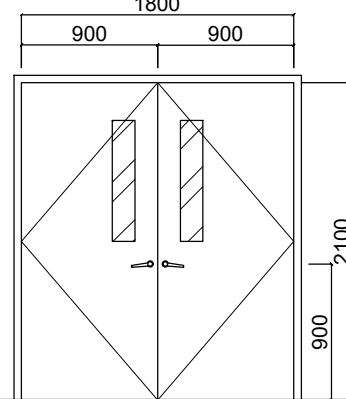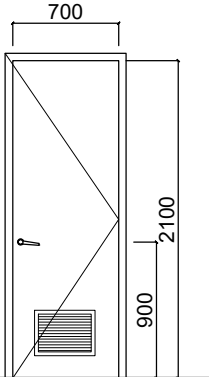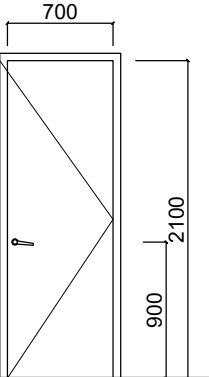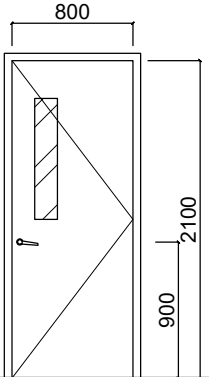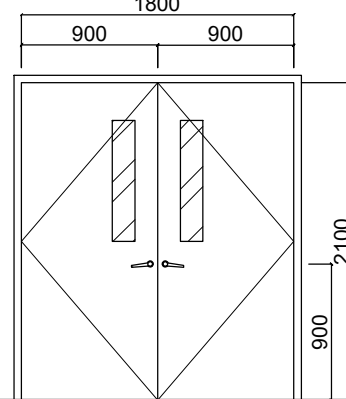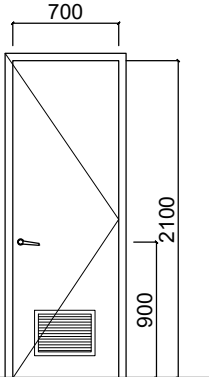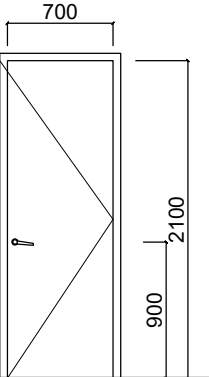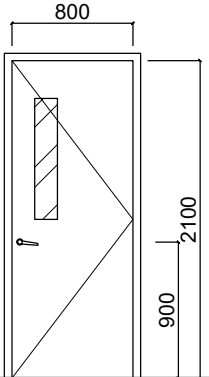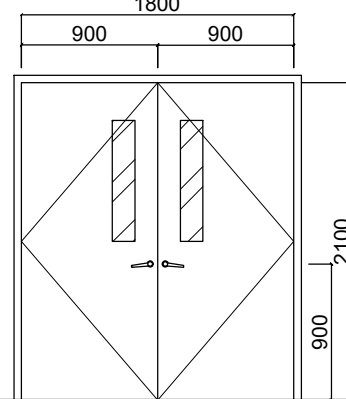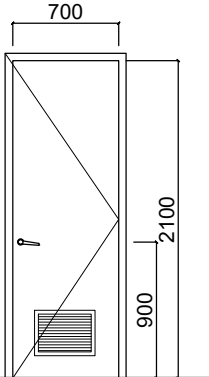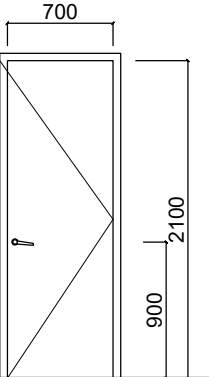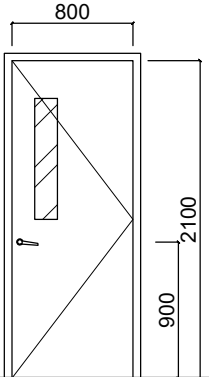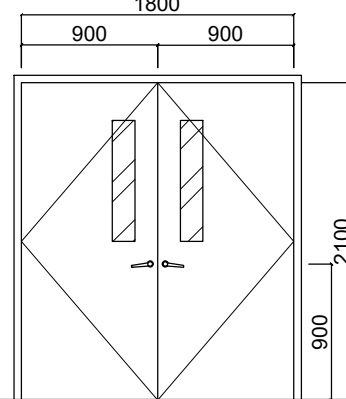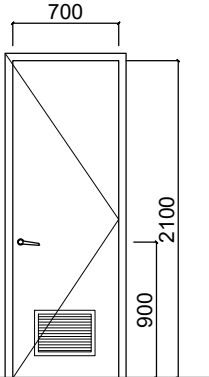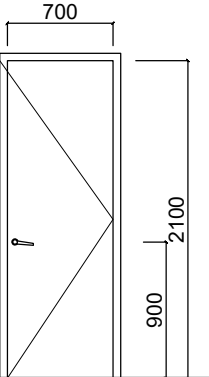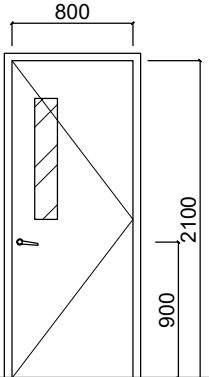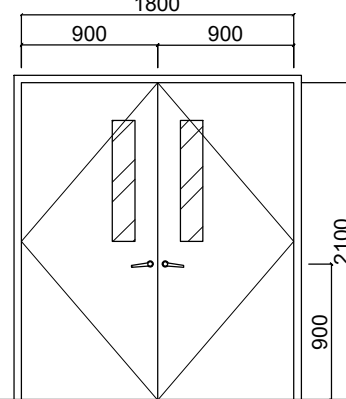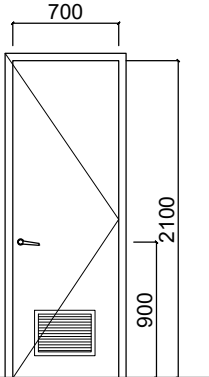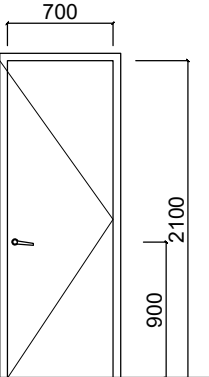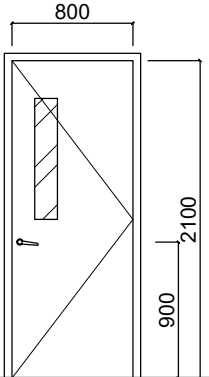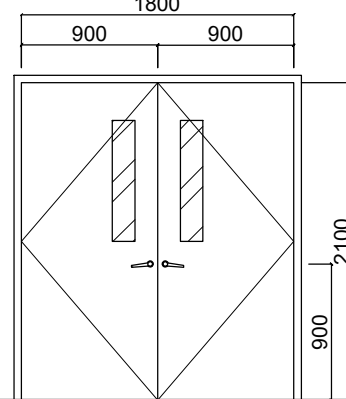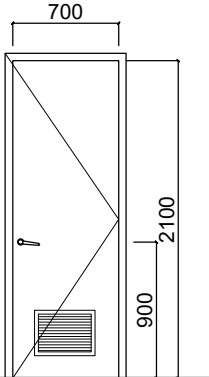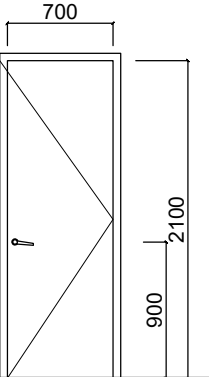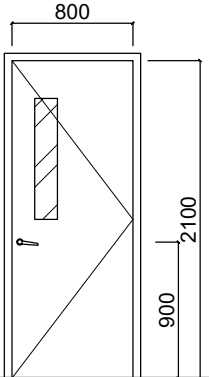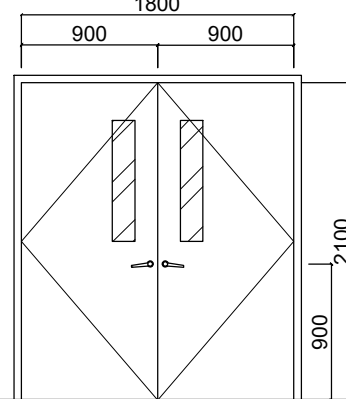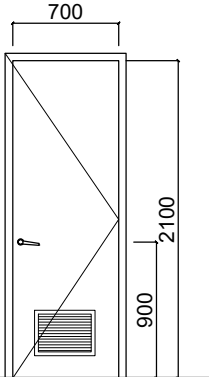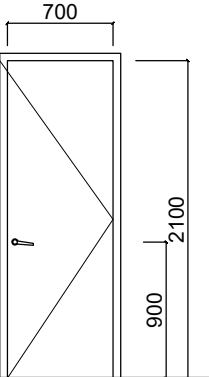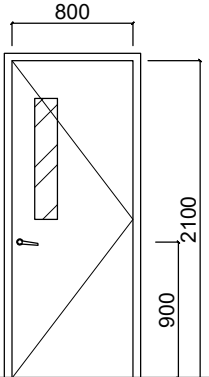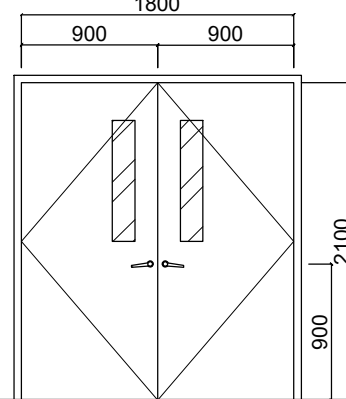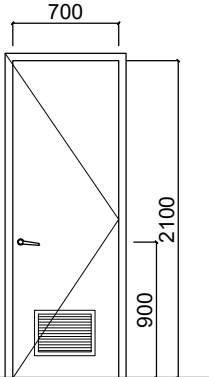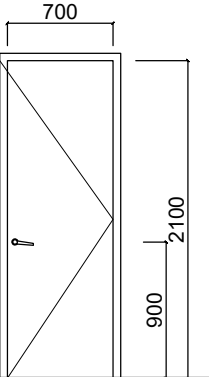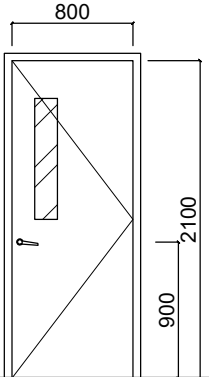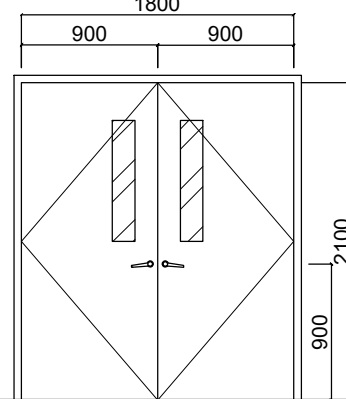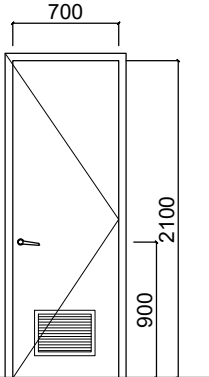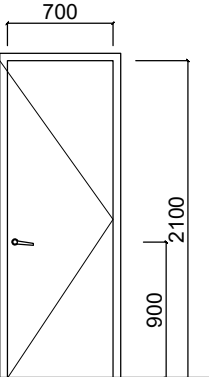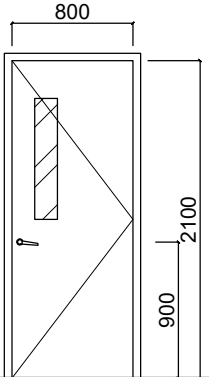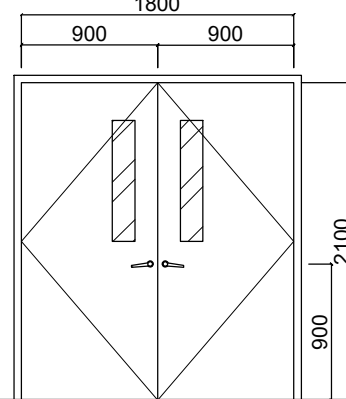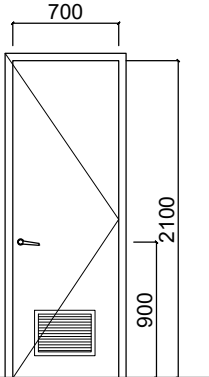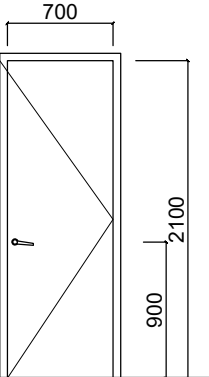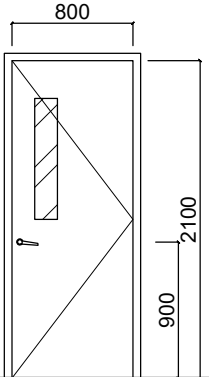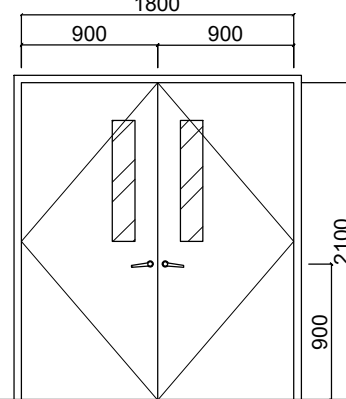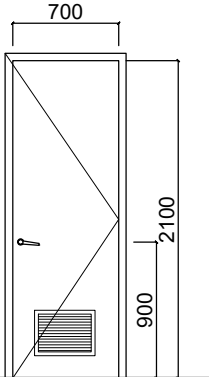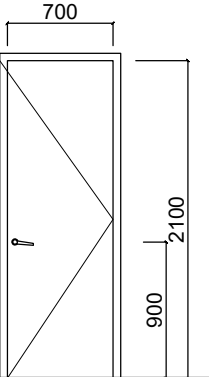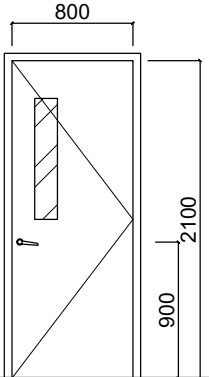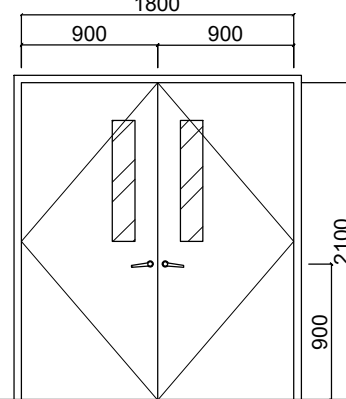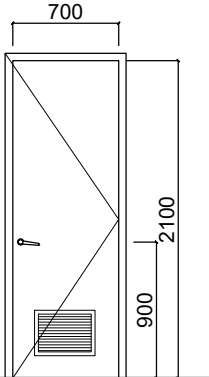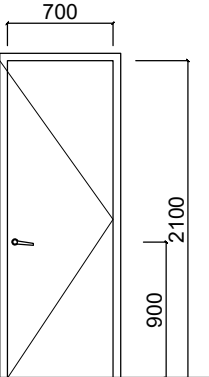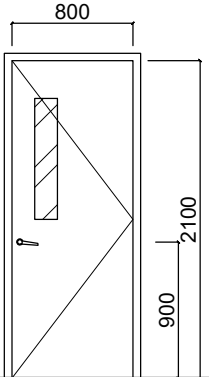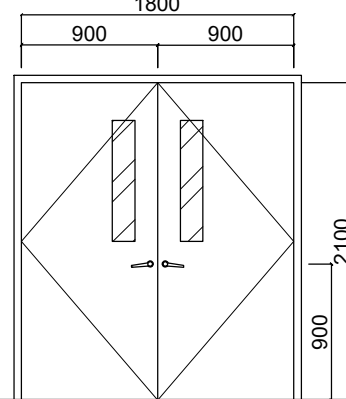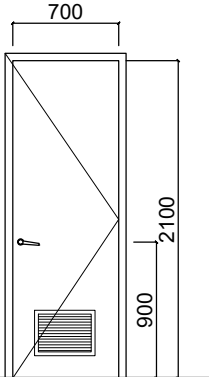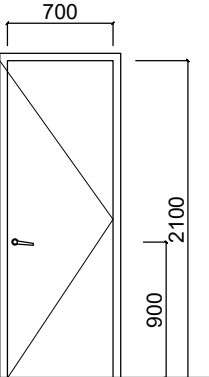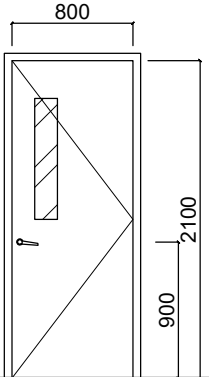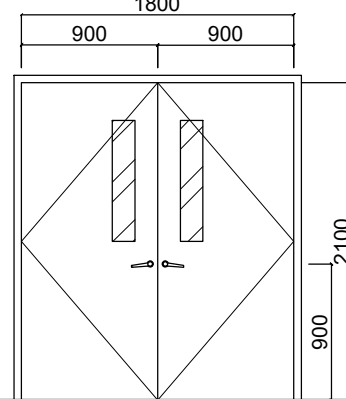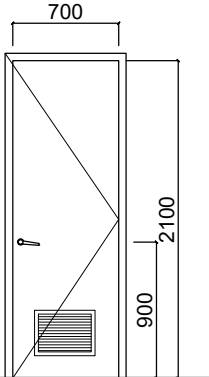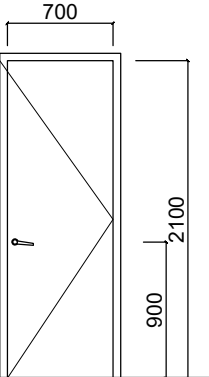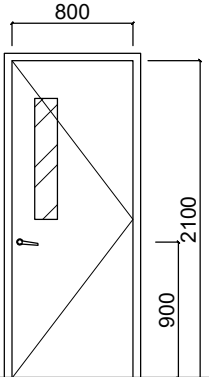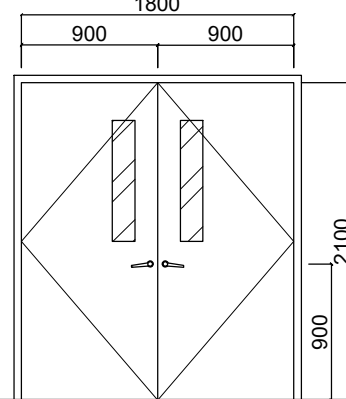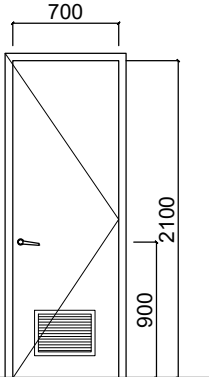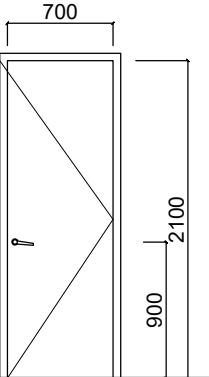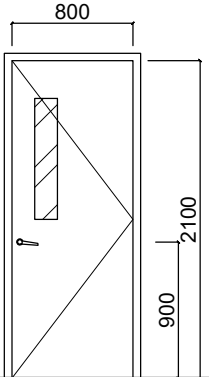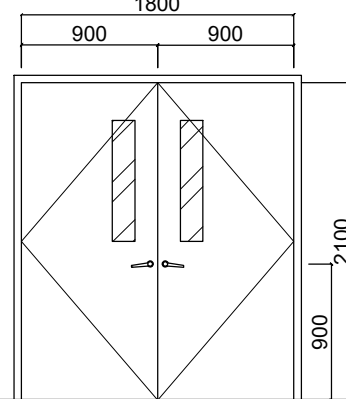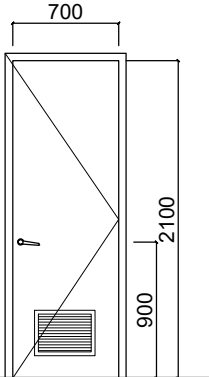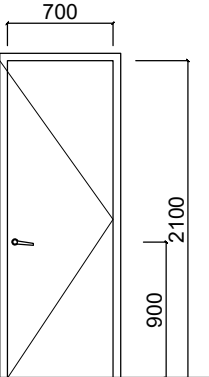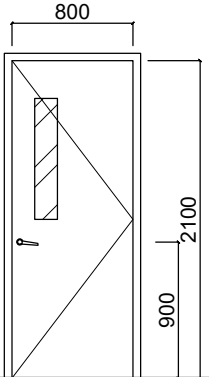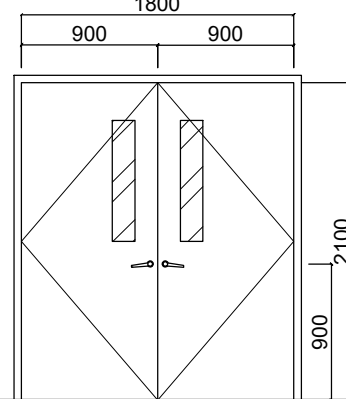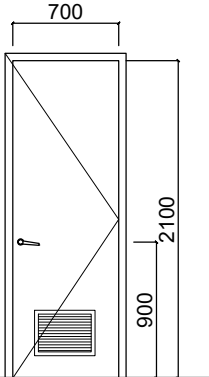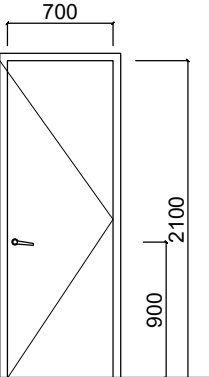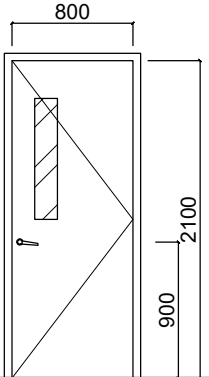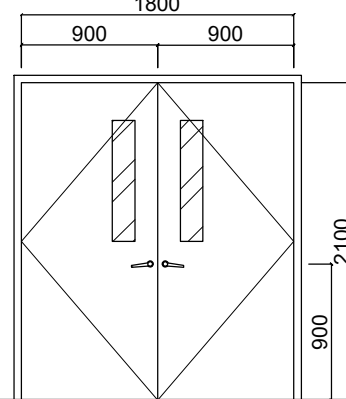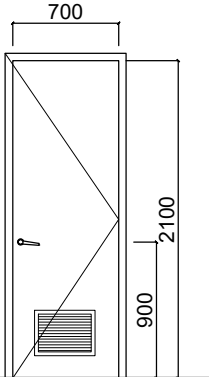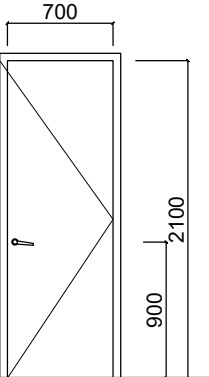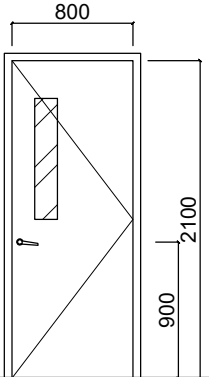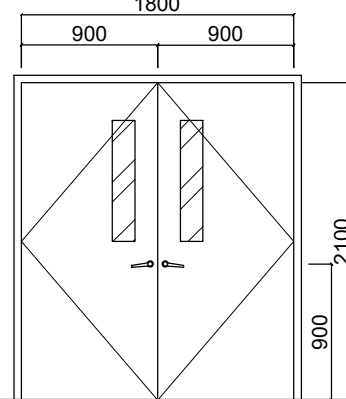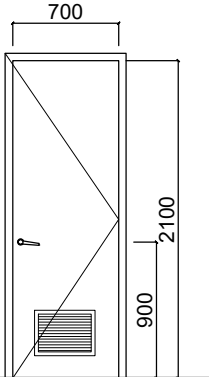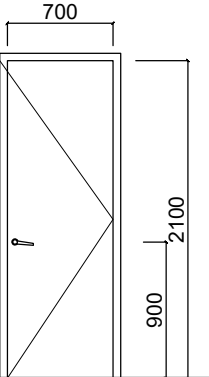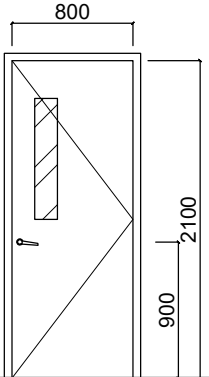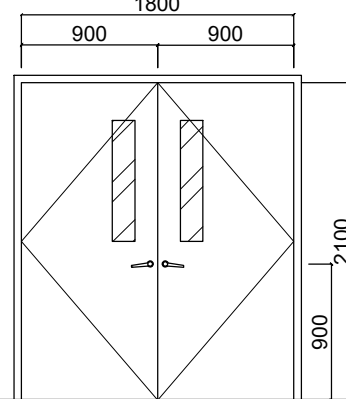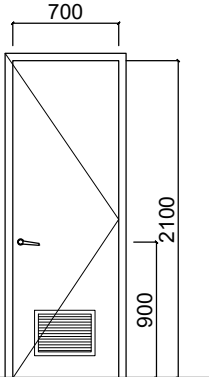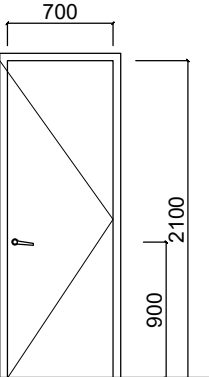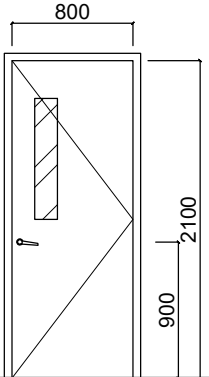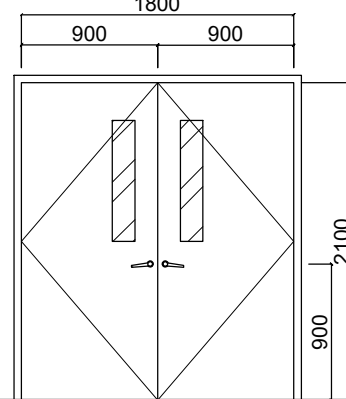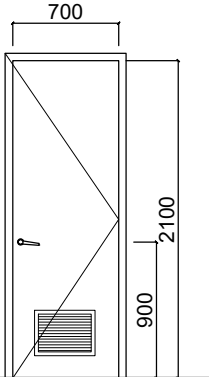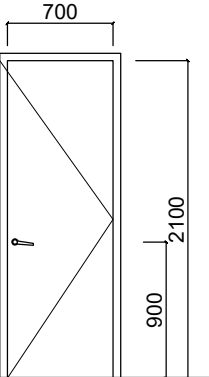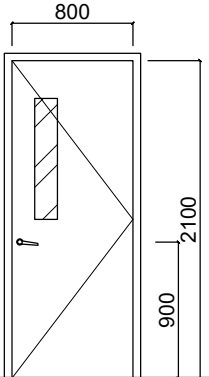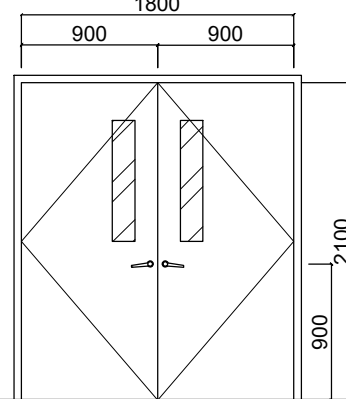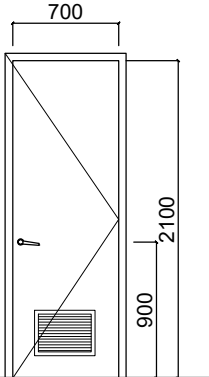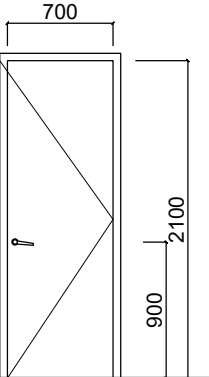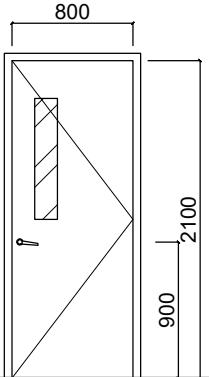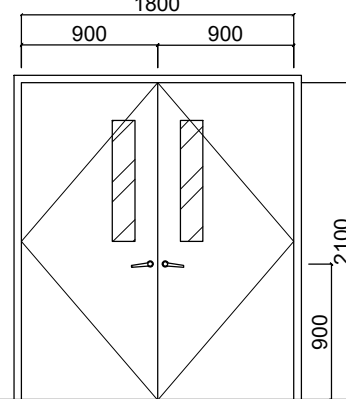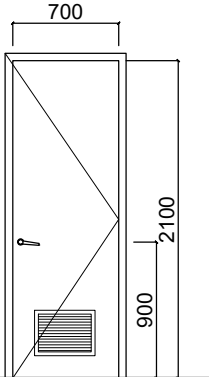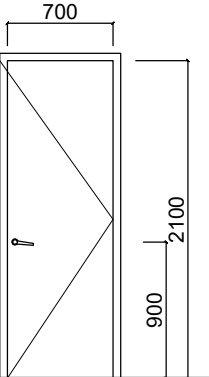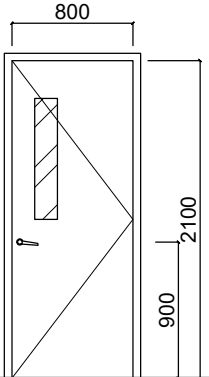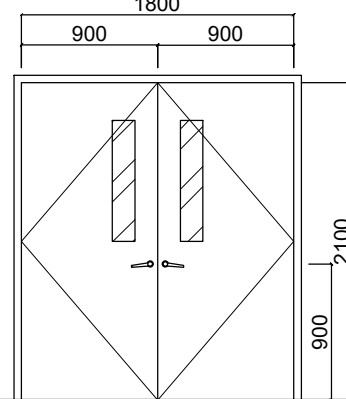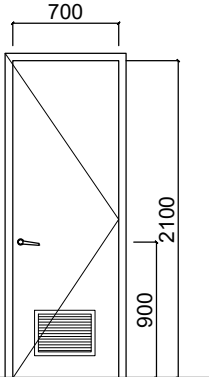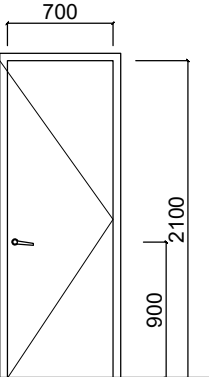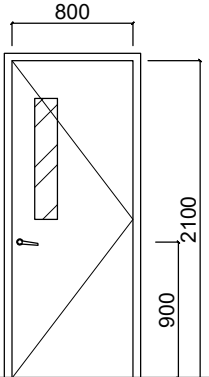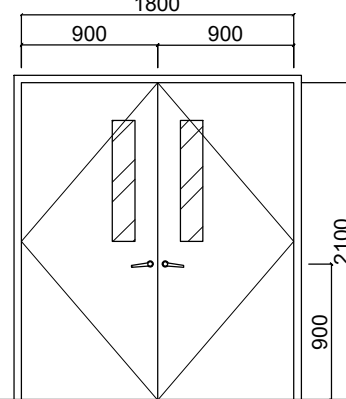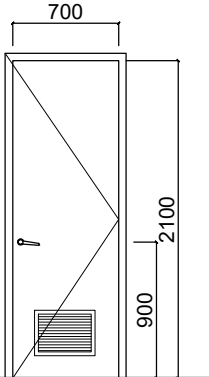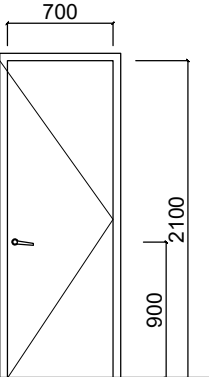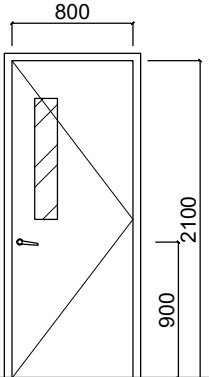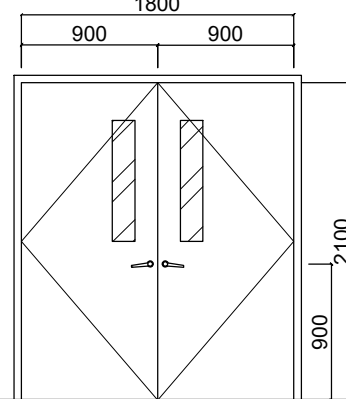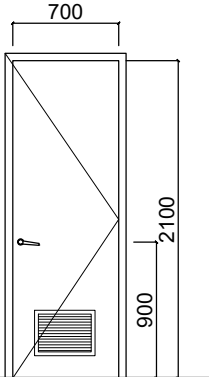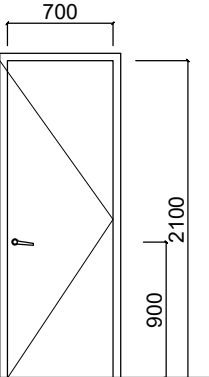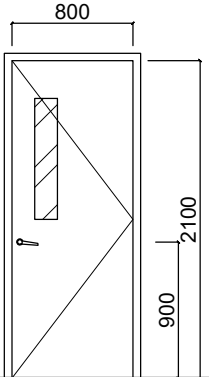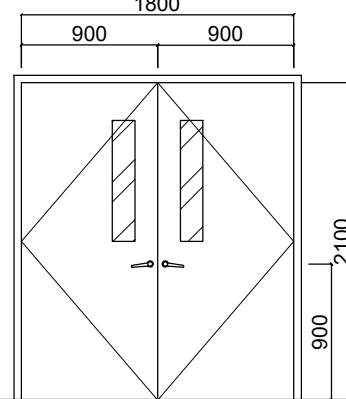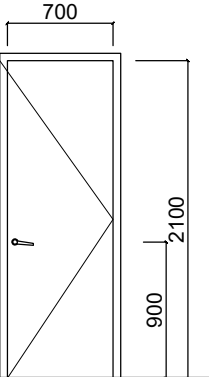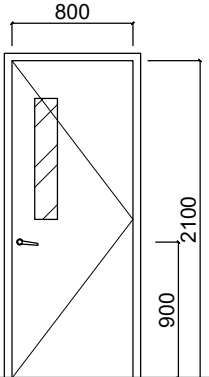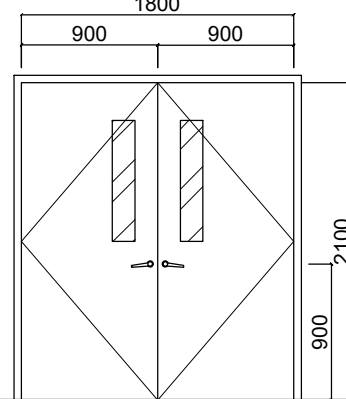
						CONTRACTOR  O C M STEEL CORPORATION 100-A WILSON RD. (COR. BAYVIEW) - BAYVIEW AREA, QUEZON CITY TEL. NO. 481-6418 / 481-6438 FAX NO. 837-2724 ELECTRICAL ENGINEER EMMANUEL D. AGDA PRC REG. NO. 0114252 FIR. 7377946 DATE: 01 / 09 / 19 PLACE: QUEZON CITY OWNER  DOST-ITDI PROJECT NAME EXPANSION AND EXTENSION RENOVATION OF THE EXISTING TSD FOR THE MODULAR MULTI-INDUSTRY INNOVATION CENTER AND EXECUTIVE OFFICES LOCATION: BICUTAN, TAGUIG APPROVED ANNABELLE V. BRIONES OIC-OFFICE OF THE DIRECTOR CONCURRED SHEET CONTENTS SCHEDULE OF DOORS SHEET NUMBER A07 AS-BUILT
						
						
						
						
						
						
						
						
						
						
						
						
						
						
						
						
						
						
						
						
						

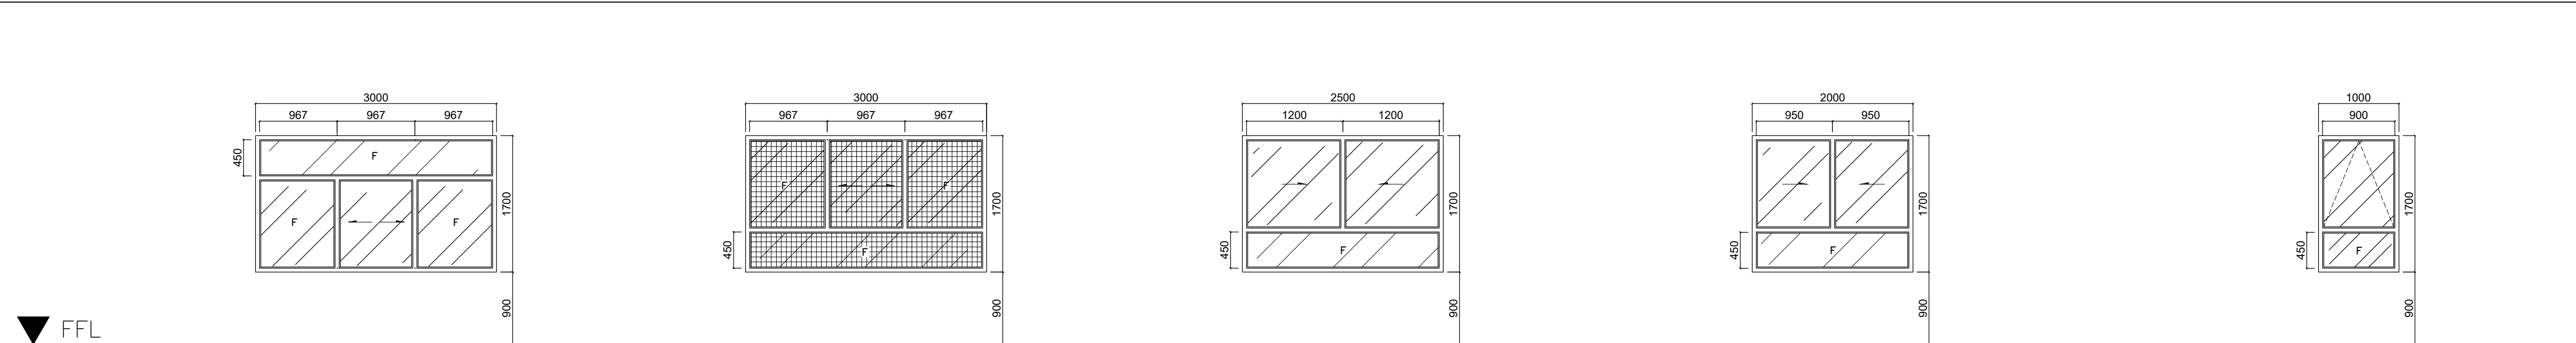

TAG:	W01	W1a	W02	W03	W3a
LOCATION:	LOWER GROUND FLOOR: — CLIENT RM., STAFF RM., OC LAB., UPPER GROUND FLOOR: — ICS RM., PS RM., PDS RM., SECOND FLOOR: — MEETING RM., OFFICE OF THE DEPUTY DIRECTOR, OC FMD RM., OC ADM RM., ADM RM., THIRD FLOOR: — MEETING RM., STAFF RM., FMISD RM., CHIEF OFFICE RM., OS TSD RM., & TSD RM. ROOF DECK:	LOWER GROUND FLOOR: UPPER GROUND FLOOR: — HOT RM., SPECIALIZED EQUIPMENT RM. & STORAGE/SOLVENT RM., SECOND FLOOR: — STORAGE RM., EXTRACTION RM., DIGESTION RM., SAMPLING PANTRY THIRD FLOOR: ROOF DECK:	LOWER GROUND FLOOR: UPPER GROUND FLOOR: SECOND FLOOR: — DIRECTOR'S OFFICE RM. & MEETING RM. THIRD FLOOR: — STAFF RM. ROOF DECK:	LOWER GROUND FLOOR: UPPER GROUND FLOOR: SECOND FLOOR: — STAFF RM. THIRD FLOOR: — STAFF RM. ROOF DECK:	LOWER GROUND FLOOR: UPPER GROUND FLOOR: SECOND FLOOR: — DIRECTOR'S OFFICE THIRD FLOOR: ROOF DECK:
DESCRIPTION:	6MM THICK ALUMINUM FRAMED GLASS	6MM THICK ALUMINUM FRAMED W/ INSECT SCREEN GLASS WINDOW	6MM THICK ALUMINUM FRAMED GLASS WINDOW	6MM THICK ALUMINUM FRAMED GLASS WINDOW	6MM THICK ALUMINUM FRAMED GLASS WINDOW
FINISHES/HARDWARE:	VERIFY HARDWARE SCHEDULE	VERIFY HARDWARE SCHEDULE	VERIFY HARDWARE SCHEDULE	VERIFY HARDWARE SCHEDULE	VERIFY HARDWARE SCHEDULE
NO. OF SETS:	VERIFY	VERIFY	VERIFY	VERIFY	VERIFY

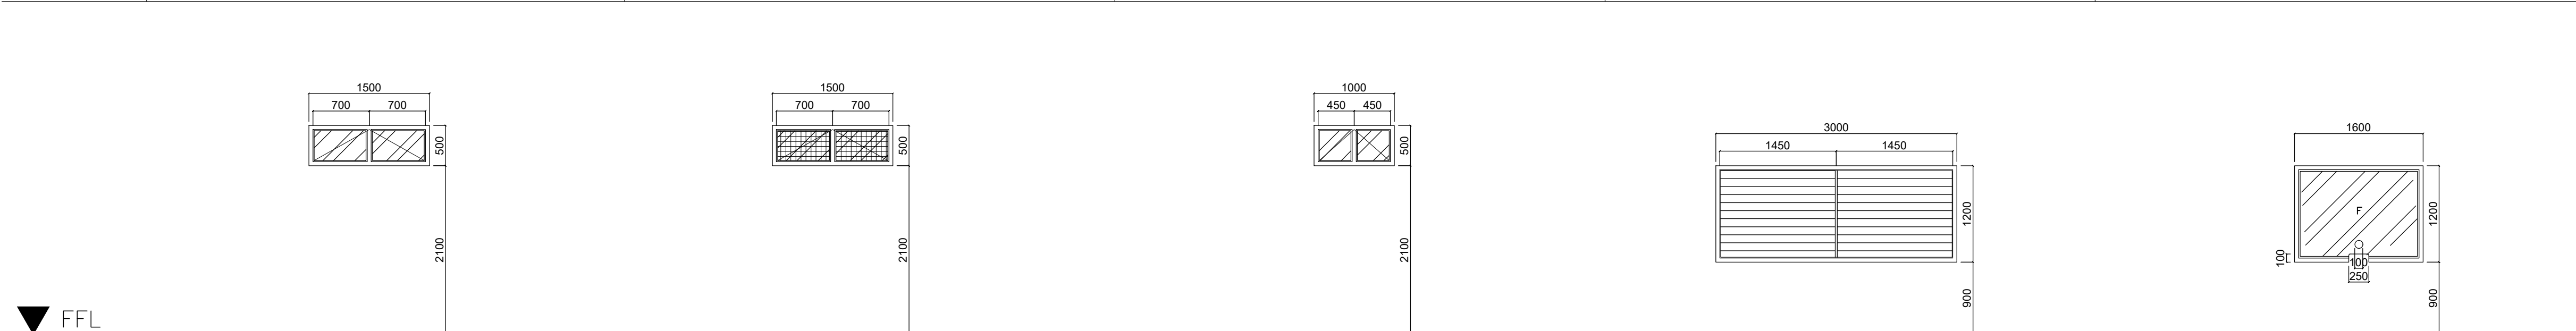

TAG:	W04	W4a	W05	W06	W07
LOCATION:	LOWER GROUND FLOOR: — MALE TOILET & FEMALE TOILET UPPER GROUND FLOOR: — MALE TOILET & FEMALE TOILET SECOND FLOOR: — MALE TOILET & FEMALE TOILET THIRD FLOOR: — MALE TOILET & FEMALE TOILET ROOF DECK:	LOWER GROUND FLOOR: — PHARMA RM. UPPER GROUND FLOOR: SECOND FLOOR: THIRD FLOOR: ROOF DECK:	LOWER GROUND FLOOR: UPPER GROUND FLOOR: SECOND FLOOR: — TOILET THIRD FLOOR: — TOILET ROOF DECK:	LOWER GROUND FLOOR: — UTILITY BAY, EQUIPMENT BAY, LIQUIDS AND EMULSION AND BOILER ROOM UPPER GROUND FLOOR: SECOND FLOOR: THIRD FLOOR: ROOF DECK:	LOWER GROUND FLOOR: UPPER GROUND FLOOR: — CASHIER RM. SECOND FLOOR: THIRD FLOOR: ROOF DECK:
DESCRIPTION:	6MM THICK ALUMINUM FRAMED GLASS WINDOW	6MM THICK ALUMINUM FRAMED W/ INSECT SCREEN GLASS WINDOW	6MM THICK ALUMINUM FRAMED GLASS WINDOW	METAL LOUVERED WITH ALUMINUM INSECT SCREEN WINDOW	10MM THICK ALUMINUM FRAMED GLASS WINDOW
FINISHES/HARDWARE:	VERIFY HARDWARE SCHEDULE	VERIFY HARDWARE SCHEDULE	VERIFY HARDWARE SCHEDULE	VERIFY HARDWARE SCHEDULE	VERIFY HARDWARE SCHEDULE
NO. OF SETS:	VERIFY	VERIFY	VERIFY	VERIFY	VERIFY

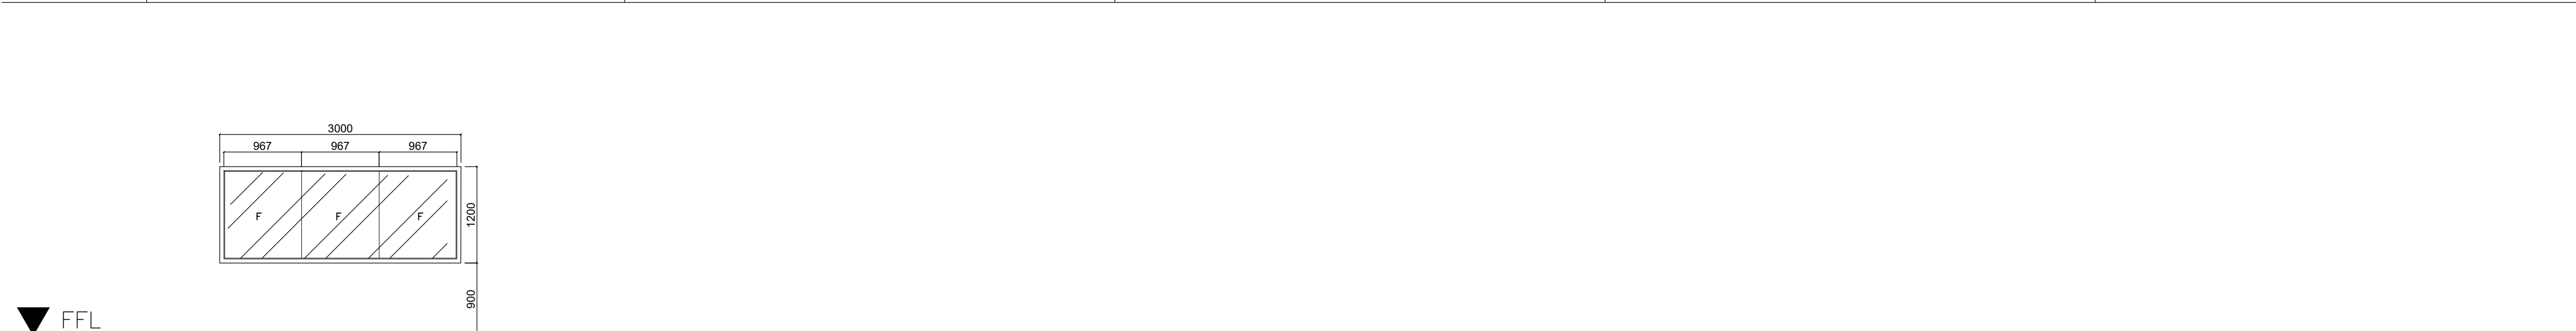



TAG:	W08	
LOCATION:	LOWER GROUND FLOOR: — MIX BLEND POWDER RM., SAUCES RM., LIQUID RM., EMULSION RM., FINISH PRODUCT RM., PACKAGING RM., CLIENT RM., STAFF RM. & OC LAB RM., UPPER GROUND FLOOR: — SPECIALIZED EQUIPMENT RM., BALANCE RM., CHANGING RM., HOT RM., AMBIENT RM., CENTRALIZED LABORATORY, PS RM., ICS RM., STAFF RM., DIVISION CHIEF RM., ENERGY RM., & PDS RM., SECOND FLOOR: — OC ADM RM., OC FMD RM., ADM RM., FMD RM., COA STAFF RM., OFFICE OF THE DEPUTY DIRECTOR, STAFF RM., & DIRECTOR'S OFFICE THIRD FLOOR: — OC TSD RM., TSD RM., CHIEF OFFICE RM., FMISD RM., COMUTER LABORATORY, STAFF & SERVER ROOM ROOF DECK:	
DESCRIPTION:	10MM THICK ALUMINUM FRAMED PANEL VIEWING GLASS WINDOW	
FINISHES/HARDWARE:	VERIFY HARDWARE SCHEDULE	
NO. OF SETS:	VERIFY	

CONTRACTOR

**OCM STEEL CORPORATION**
PHILIPPINE STEEL INDUSTRIES, INC. (A SUBSIDIARY OF THE STEEL ROLLERS ASSOCIATION OF THE PHILIPPINES) 1000 N. AVENUE 10, QUEZON CITY, PHILIPPINES 1100
TEL. NO. 461-6191 / 461-6192 FAX NO. 937-2724

ELECTRICAL ENGINEER

  EMMANUEL D. AGDA



OWNER

**DOST-ITDI**

PROJECT NAME

EXPANSION AND EXTENSION
RENOVATION OF THE EXISTING TSD
FOR THE MODULAR MULTI-INDUSTRY
INNOVATION CENTER AND
EXECUTIVE OFFICES

LOCATION: BICUTAN, TAGUIG

APPROVED

ANNABELLE V. BRIONES
OIC-OFFICE OF THE DIRECTOR

CONCURRED

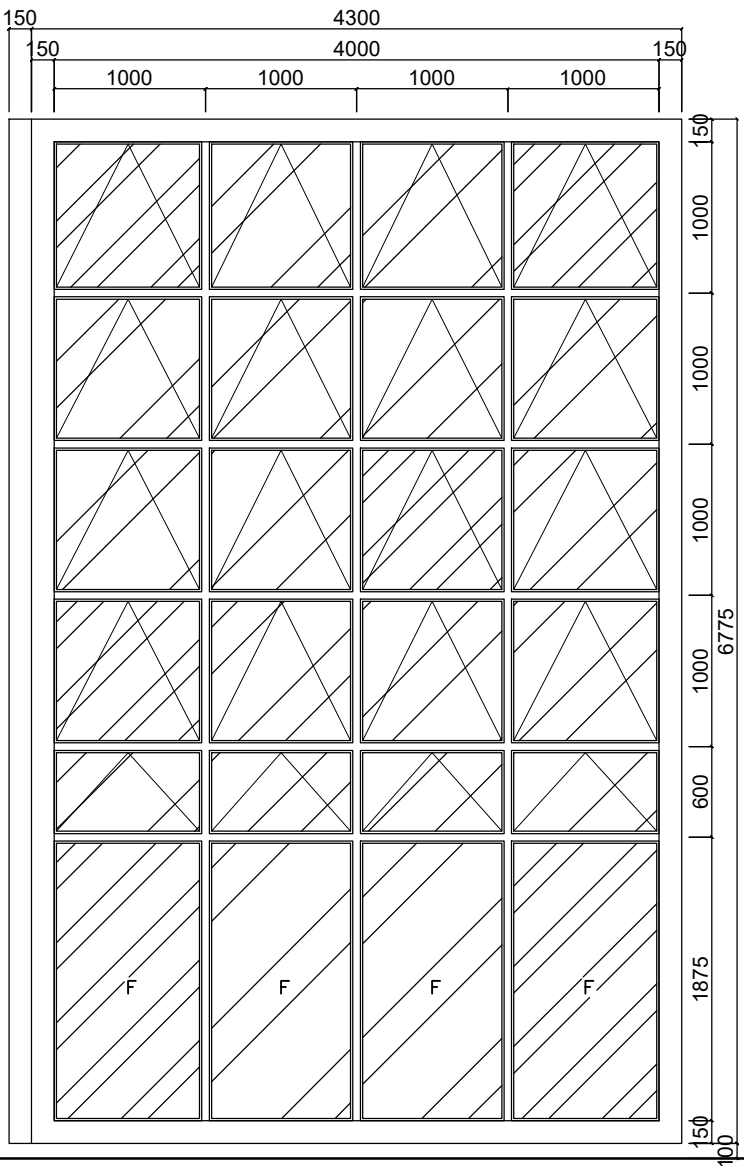
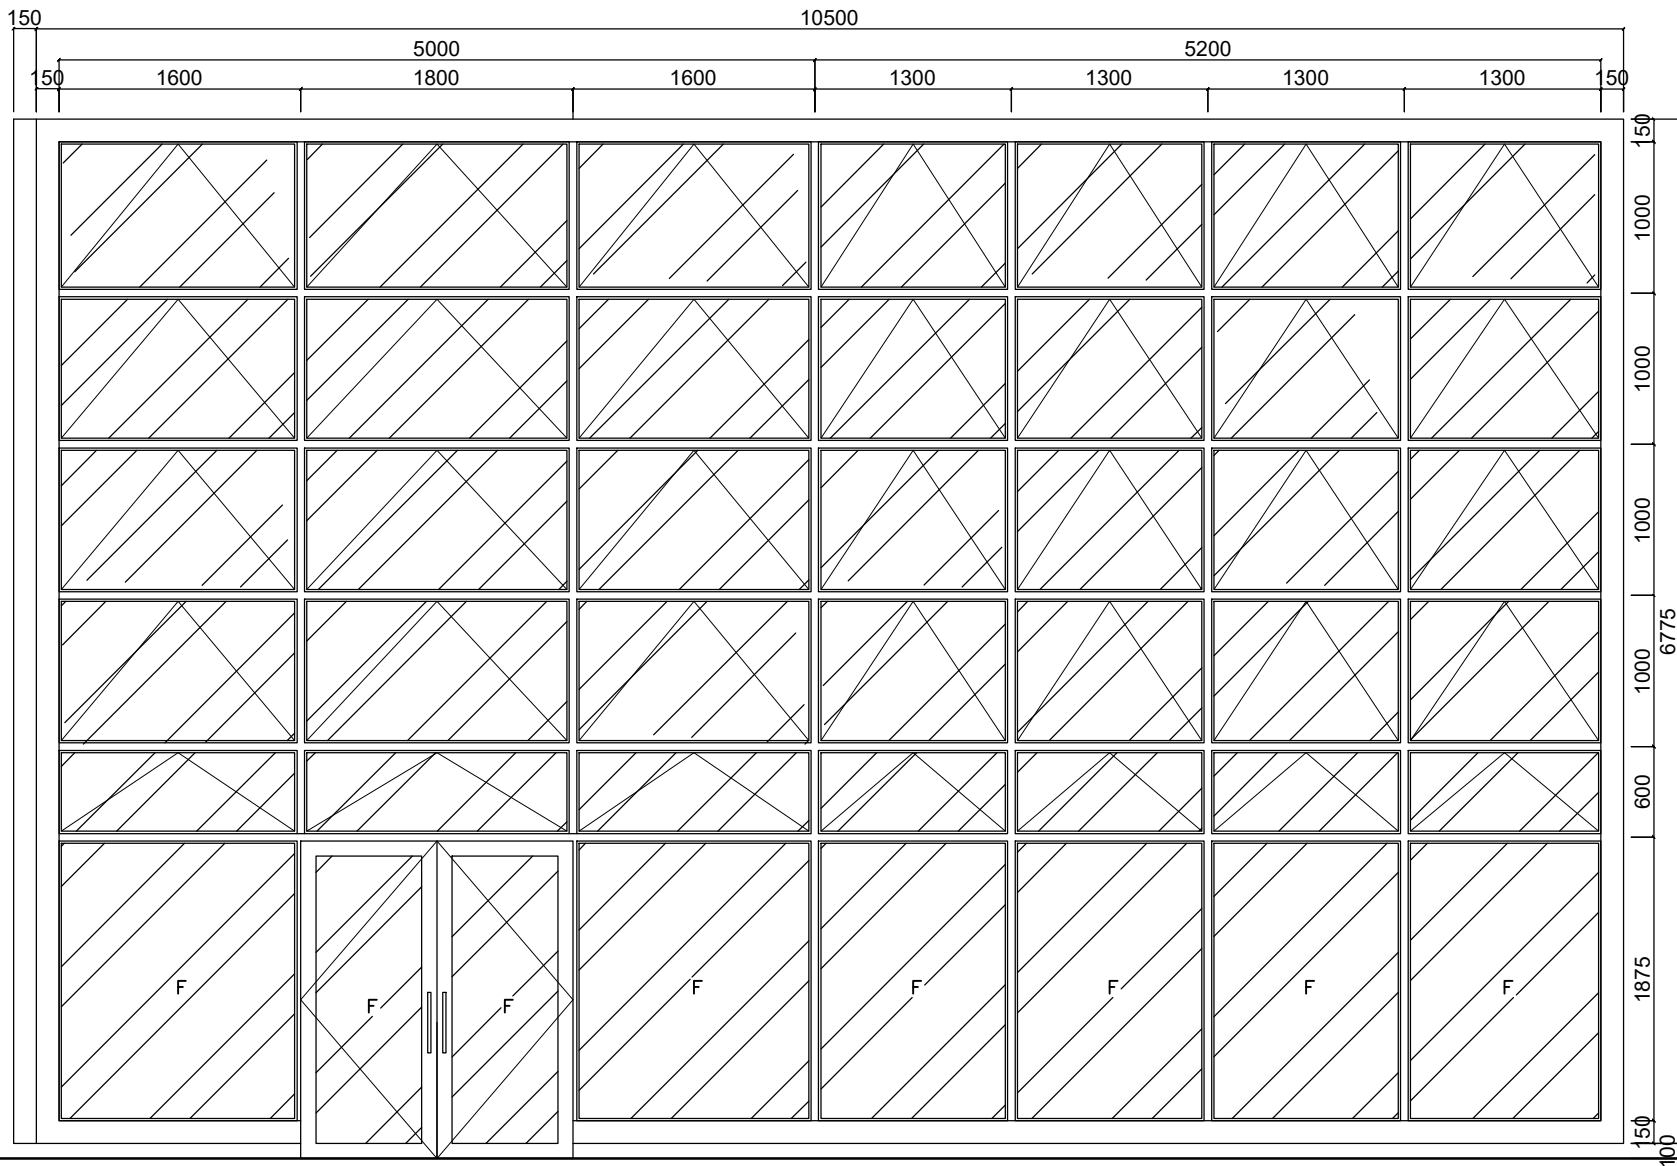
SHEET CONTENTS

SCHEDULE OF WINDOWS

SHEET NUMBER

A08

AS-BUILT



TAG:	CW 01	CW 02
LOCATION:	LOWER GROUND FLOOR:	LOWER GROUND FLOOR:
	UPPER GROUND FLOOR:	UPPER GROUND FLOOR:
	SECOND FLOOR: - ELEVATOR LOBBY	SECOND FLOOR: - ELEVATOR LOBBY
	THIRD FLOOR: - ELEVATOR LOBBY	THIRD FLOOR: - ELEVATOR LOBBY
	ROOF DECK:	ROOF DECK:
DESCRIPTION:	12MM THICK ALUMINUM FRAMED TEMPERED GLASS WALL	12MM THICK ALUMINUM FRAMED TEMPERED GLASS WALL
FINISHES/HARDWARE:	VERIFY HARDWARE SCHEDULE	VERIFY HARDWARE SCHEDULE
NO. OF SETS:	VERIFY	VERIFY

01

A-09

SCHEDULE OF WINDOWS

SCALE

1:100M.

CONTRACTOR



OCM STEEL CORPORATION
PHILIPPINE STEEL INDUSTRIES, INC. (A SUBSIDIARY OF THE STEEL CORPORATION OF PHILIPPINES)
TEL. NO. 461-6191 / 461-6192 FAX NO. 837-2724

ELECTRICAL ENGINEER

EMMANUEL D. AGDA

PRC REG. NO.: 0114252

DATE: 01 / 09 / 19

P.R. 7377945

PLACE: QUEZON CITY

T.N. 400-460-256

OWNER



DOST-ITDI

PROJECT NAME

EXPANSION AND EXTENSION
RENOVATION OF THE EXISTING TSD
FOR THE MODULAR MULTI-INDUSTRY
INNOVATION CENTER AND
EXECUTIVE OFFICES

LOCATION: BICUTAN, TAGUIG

APPROVED

ANNABELLE V. BRIONES
OIC-OFFICE OF THE DIRECTOR

CONCURRED

SHEET CONTENTS

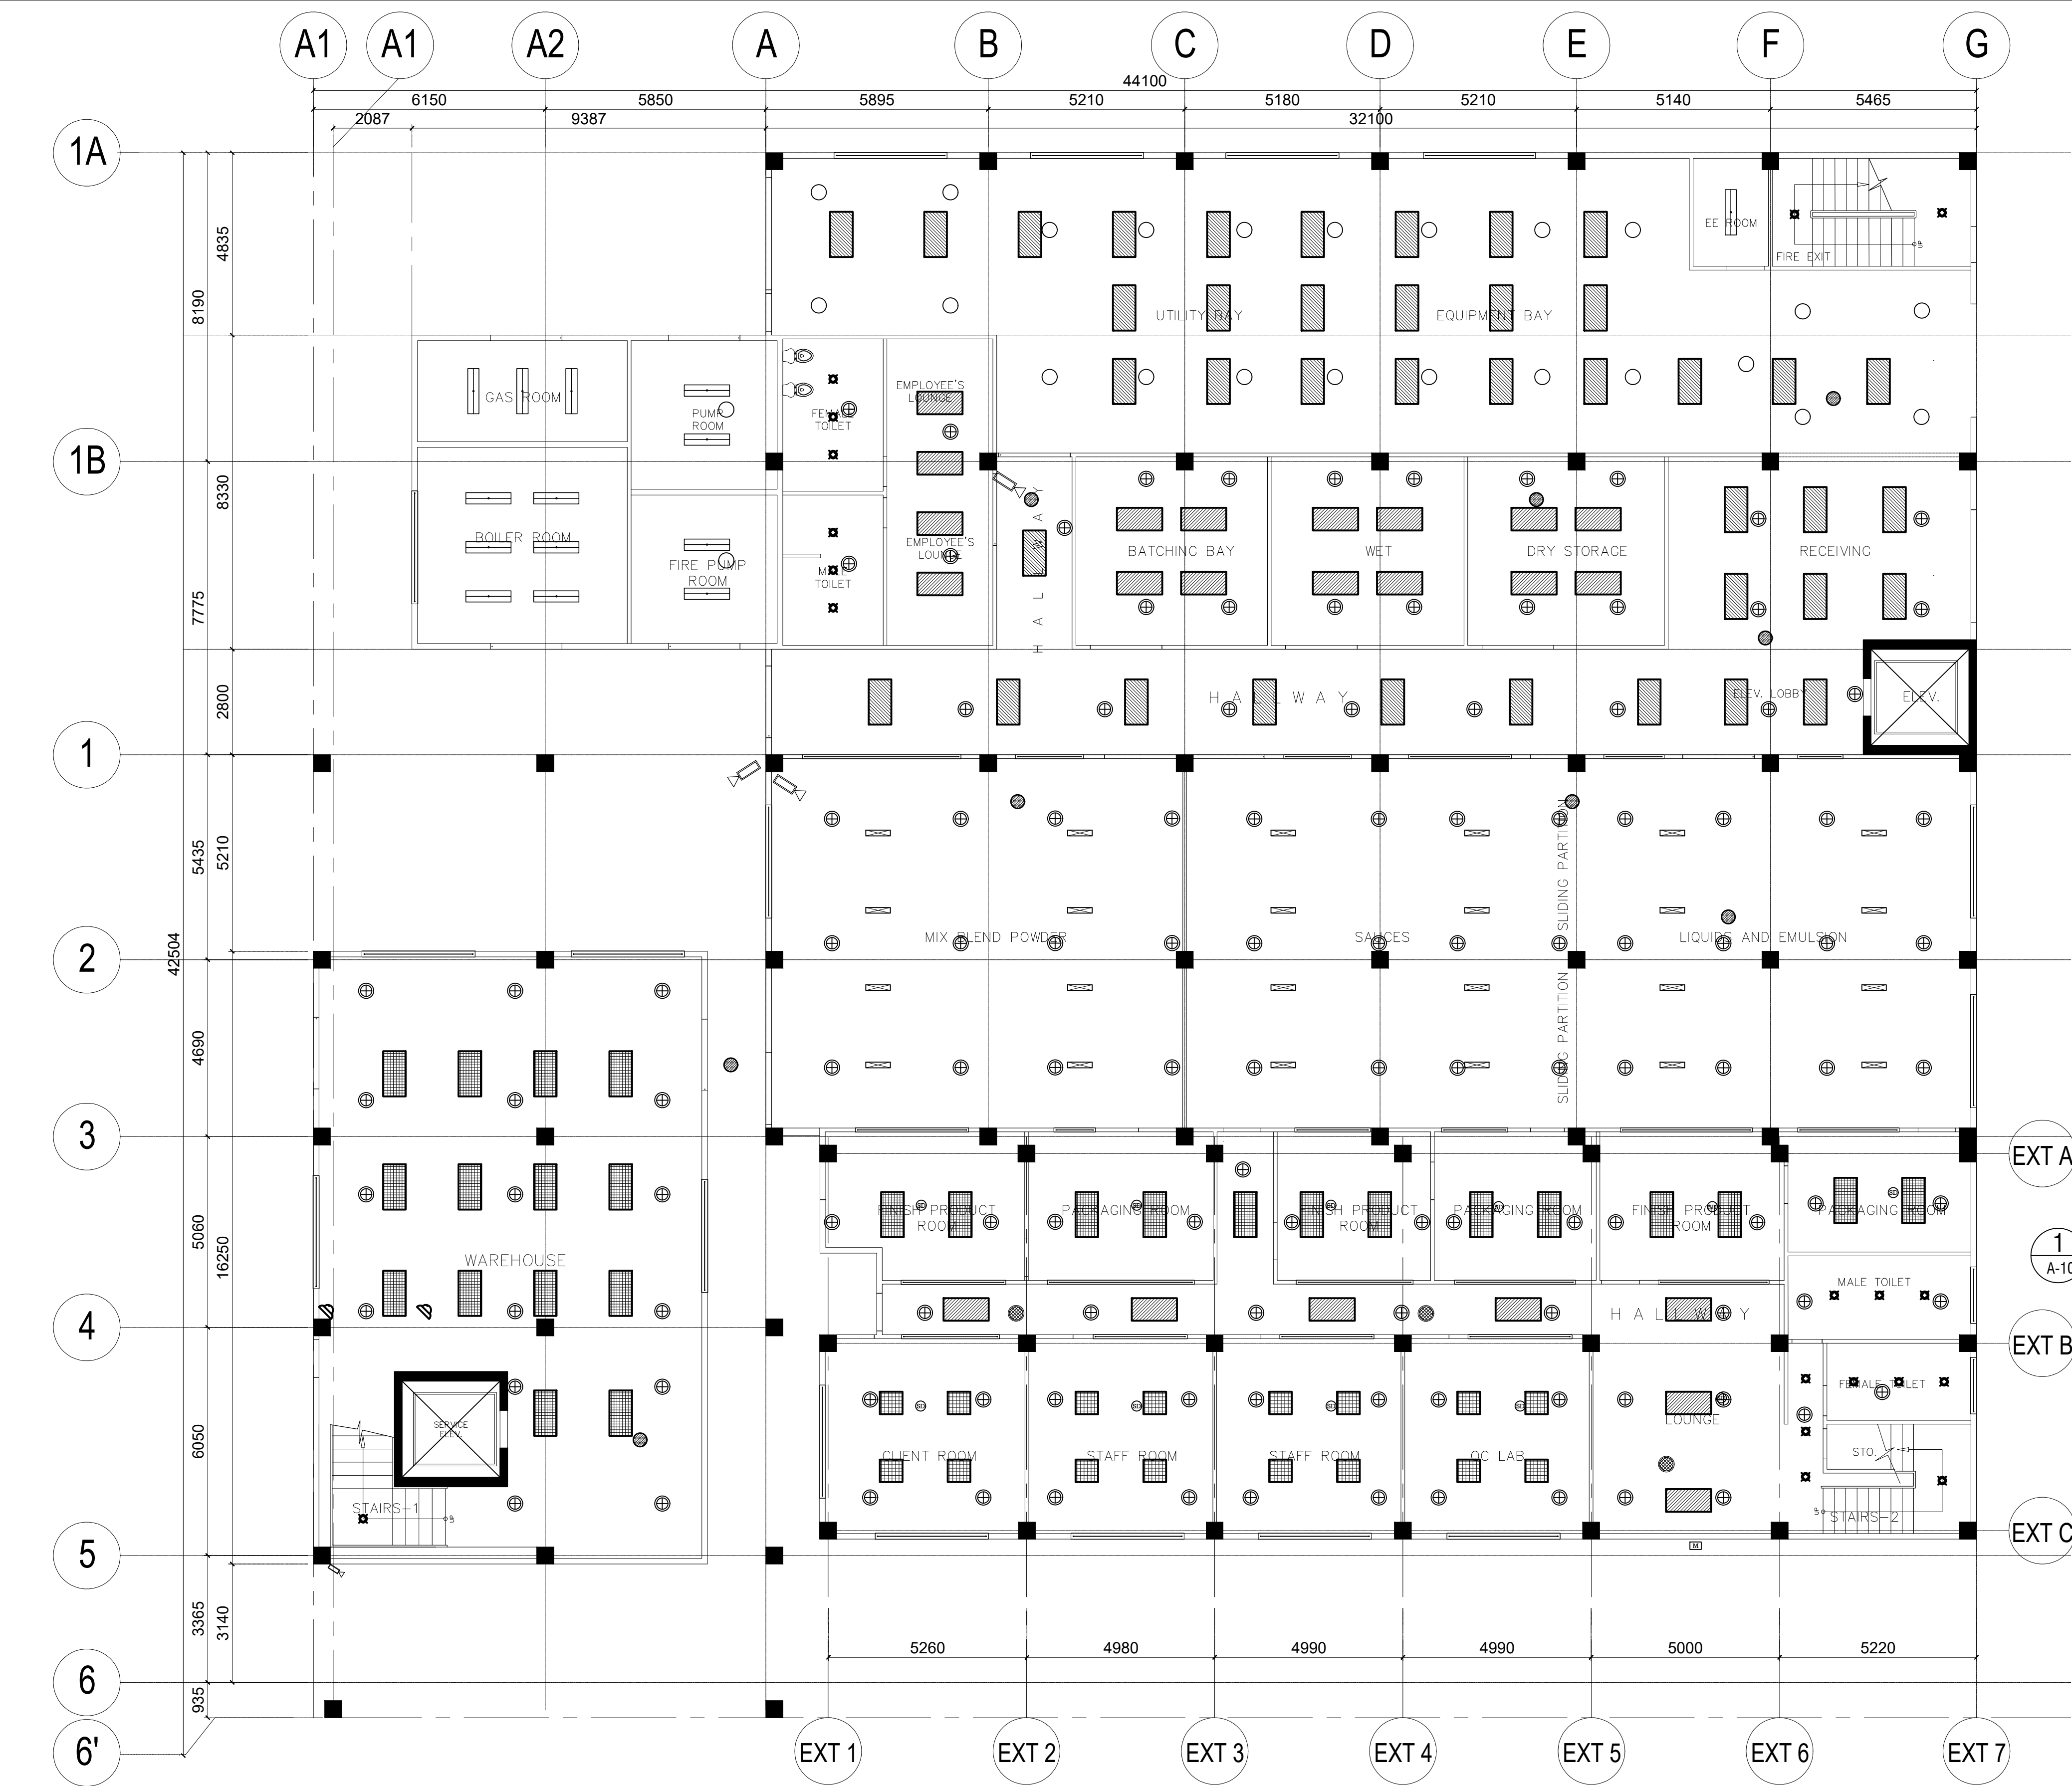
SCHEDULE OF WINDOWS

SHEET NUMBER

A

09


AS-BUILT



**LOWER GROUND FLOOR
REFLECTED CEILING PLAN**
SCALE 1:200M.

- LEGEND**
- 60X120 TROFFER TYPE LUMINAIRE FLOURESCENT
 - 60X120 TROFFER TYPE LUMINAIRE W/ PRISMATIC DIFFUSER FLOURESCENT
 - DOWNLIGHT (COMPACT FLOURESCENT)
 - TROFFER TYPE LUMINAIRE FLOURESCENT
 - MOISTURE/DUSTPROOF LUMINAIRE LINEAR FLOURESCENT
 - WALL MOUNTED CAMERA
 - DOME TYPE CAMERA
 - FIRE SPRINKLER HEAD
 - SMOKE DETECTOR
 - CEILING MOUNTED SPEAKER

CONTRACTOR	
 OCM STEEL CORPORATION PHILIPPINE INDUSTRIAL DEVELOPMENT CORPORATION (PILINDCO) INC. A JOINT VENTURE OF THE PHILIPPINE GOVERNMENT AND THE UNITED STATES GOVERNMENT TEL. NO. 464-4391 • 464-4392 FAX NO. 937-2724	
ELECTRICAL ENGINEER	
EMMANUEL D. AGDA	
PRC REG. NO. 0114252 DATE: 01 / 09 / 19 FIR. 7377946 TIN. 400-460-256 PLACE: QUEZON CITY	
OWNER	
 DOST-ITDI	
PROJECT NAME	
EXPANSION AND EXTENSION RENOVATION OF THE EXISTING TSD FOR THE MODULAR MULTI-INDUSTRY INNOVATION CENTER AND EXECUTIVE OFFICES LOCATION: BICUTAN, TAGUIG	
APPROVED	
ANNABELLE V. BRIONES OIC-OFFICE OF THE DIRECTOR	
CONCURRED	
SHEET CONTENTS	
LOWER GROUND FLOORPLAN REFLECTED CEILING PLAN	
SHEET NUMBER	
A	10
AS-BUILT	

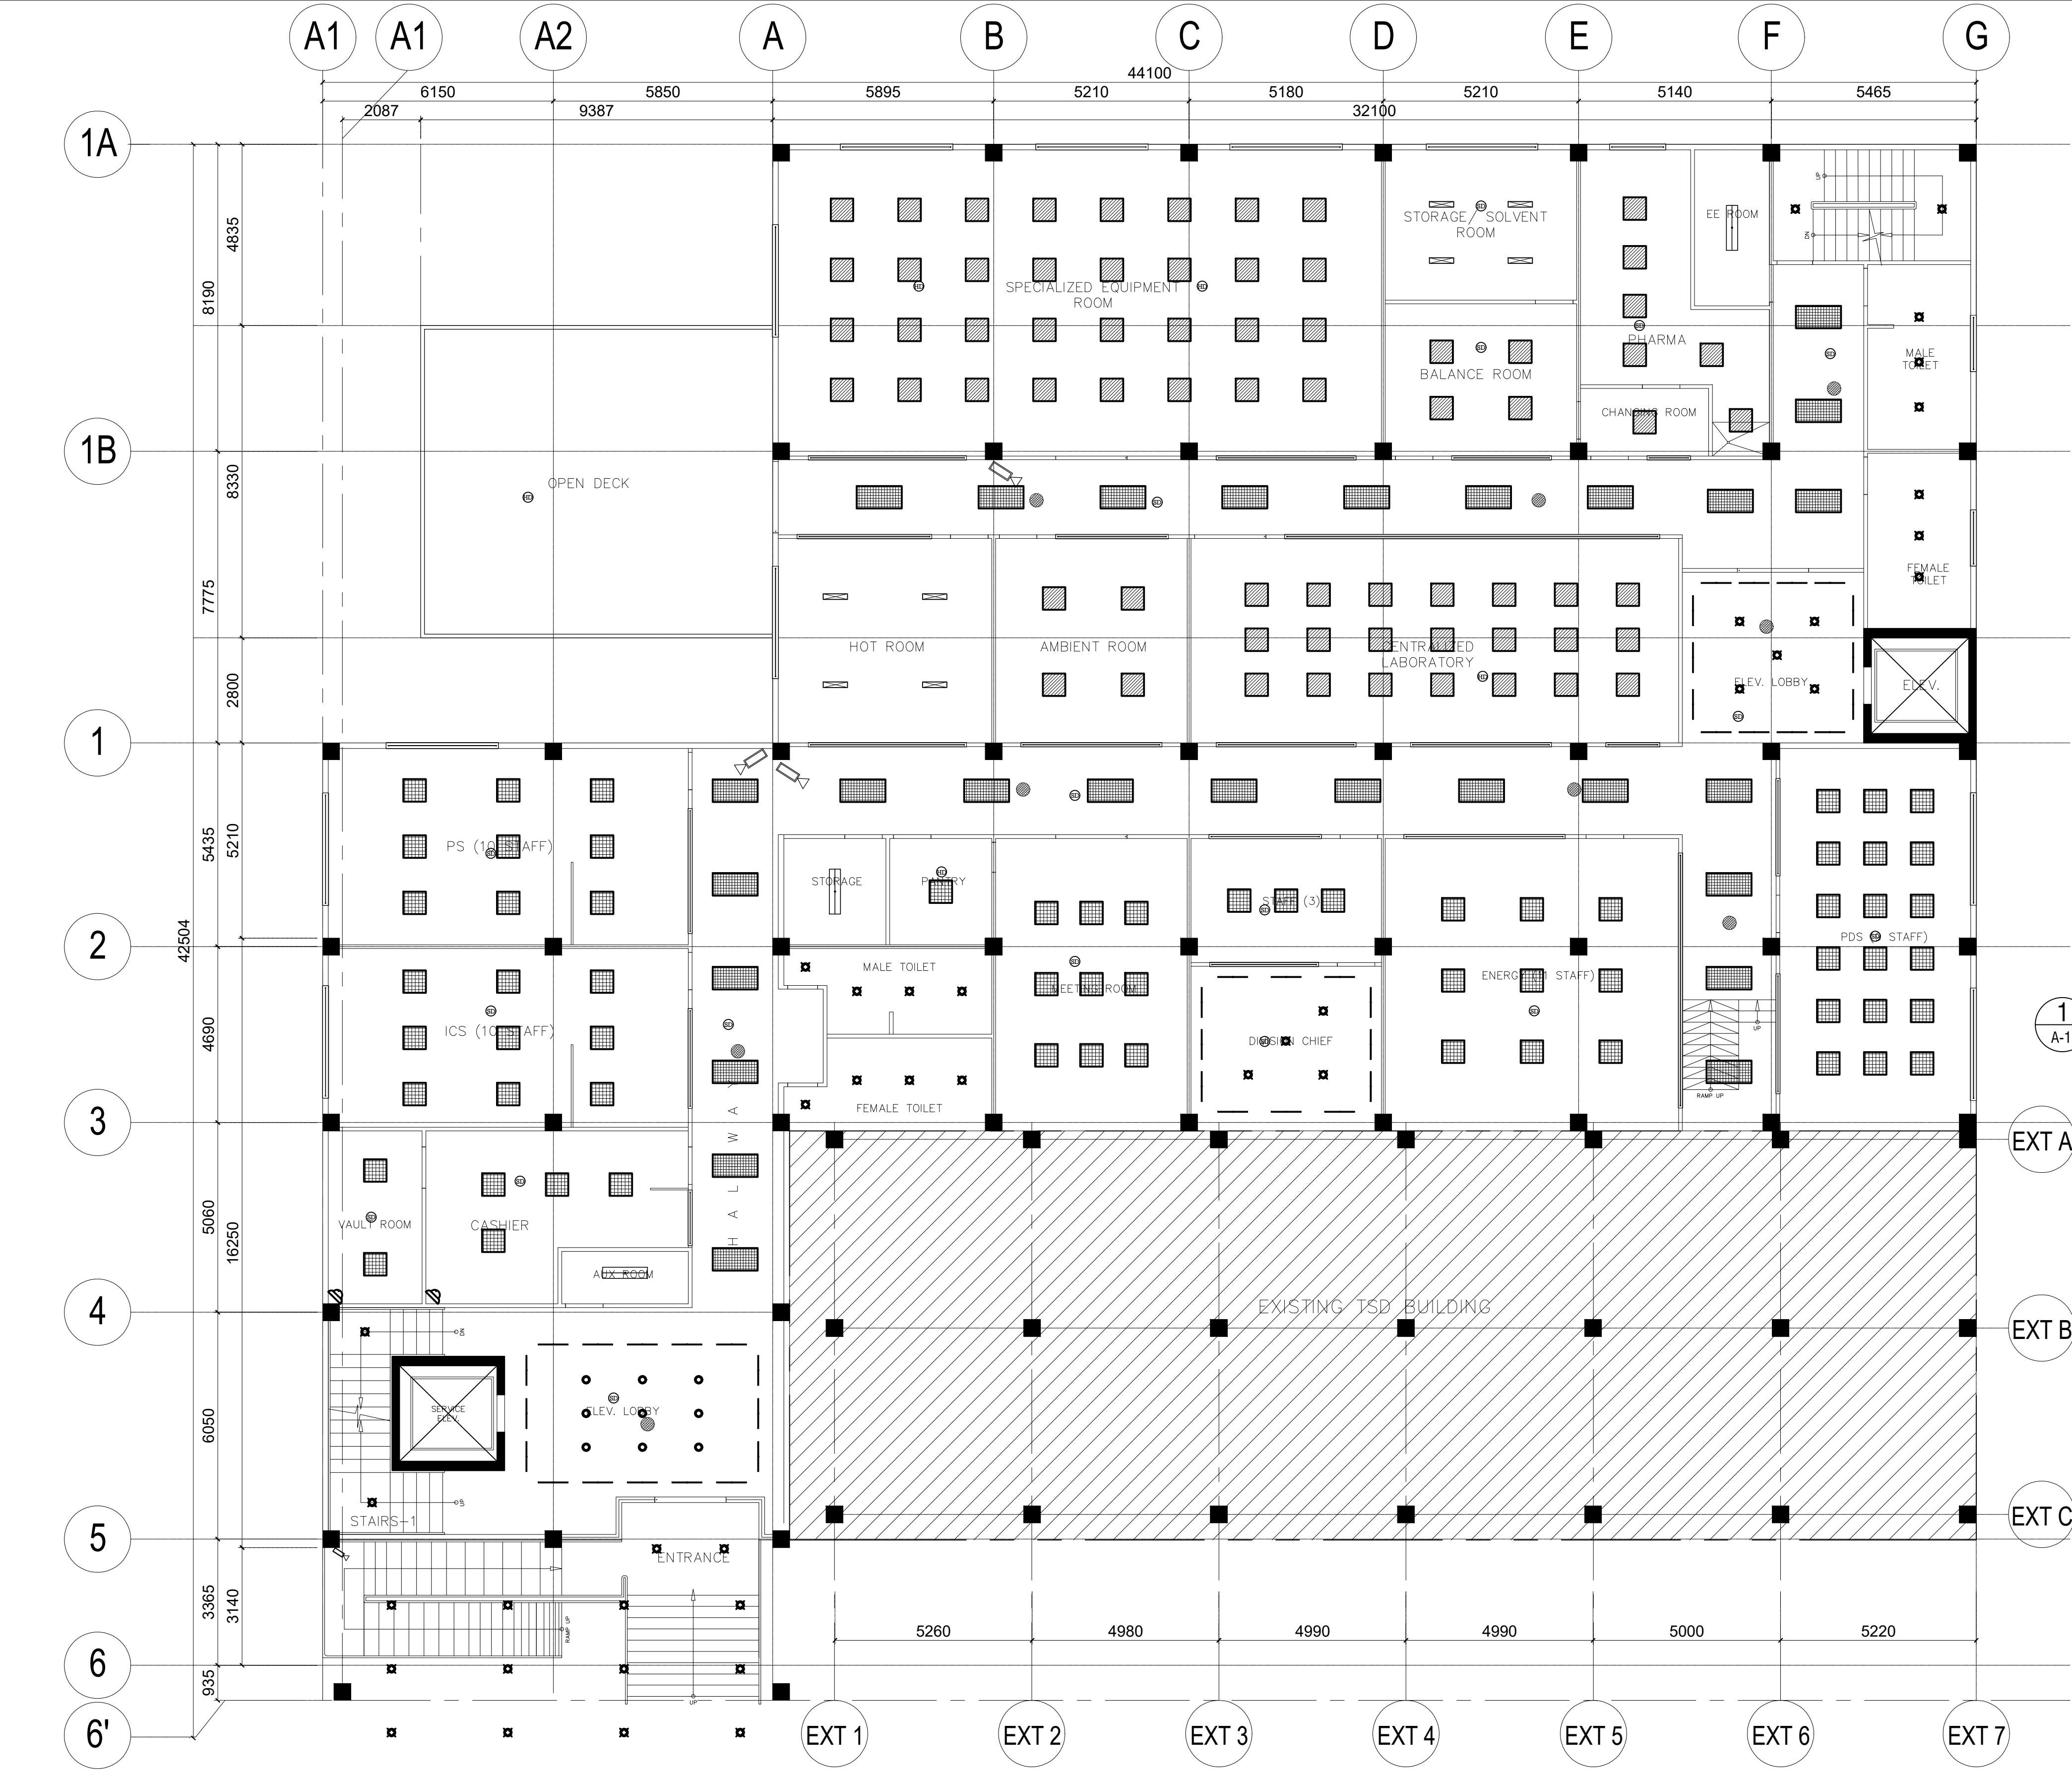

**UPPER GROUND FLOOR
REFLECTED CEILING PLAN**
SCALE 1:200M.

- LEGEND**
- 60X120 TROFFER TYPE LUMINAIRE FLOURESCENT
 - 60X120 TROFFER TYPE LUMINAIRE W/ PRISMATIC DIFFUSER FLOURESCENT
 - DOWNLIGHT (COMPACT FLOURESCENT)
 - TROFFER TYPE LUMINAIRE FLOURESCENT
 - MOISTURE/DUSTPROOF LUMINAIRE LINEAR FLOURESCENT
 - WALL MOUNTED CAMERA
 - DOME TYPE CAMERA
 - FIRE SPRINKLER HEAD
 - SMOKE DETECTOR
 - CEILING MOUNTED SPEAKER

CONTRACTOR

OCM STEEL CORPORATION
100-A, INDUSTRIAL ESTATE, ALABANG, MARIKINA CITY, METRO MANILA
TEL. NO. 464-8391 • 464-8392 FAX NO. 937-2724

ELECTRICAL ENGINEER

EMMANUEL D. AGDA

PRC REG. NO. 0114252
FIR. 7377945
TIN. 400-460-256

DATE: 01 / 09 / 19
PLACE: QUEZON CITY

OWNER

DOST-ITDI

PROJECT NAME

EXPANSION AND EXTENSION
RENOVATION OF THE EXISTING TSD
FOR THE MODULAR MULTI-INDUSTRY
INNOVATION CENTER AND
EXECUTIVE OFFICES

LOCATION: BICUTAN, TAGUIG

APPROVED

ANNABELLE V. BRIONES

OIC-OFFICE OF THE DIRECTOR

CONCURRED

SHEET CONTENTS

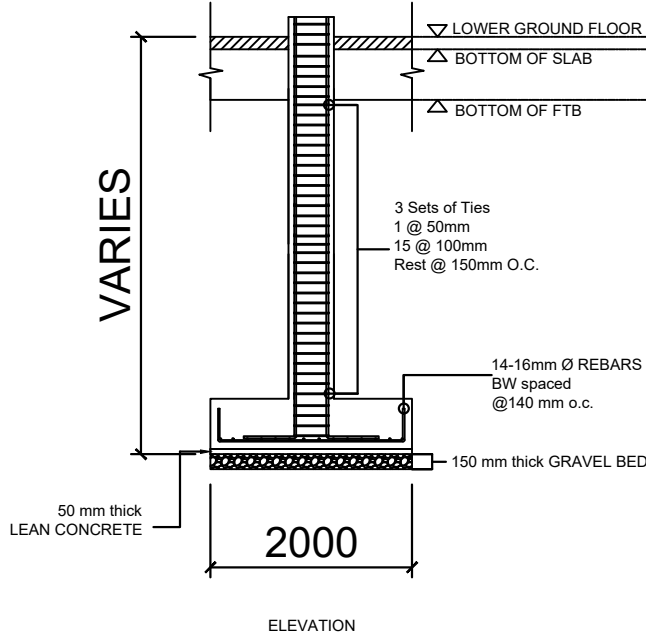
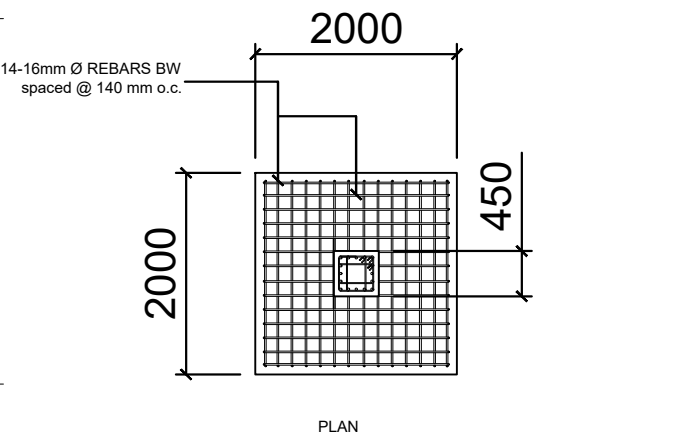
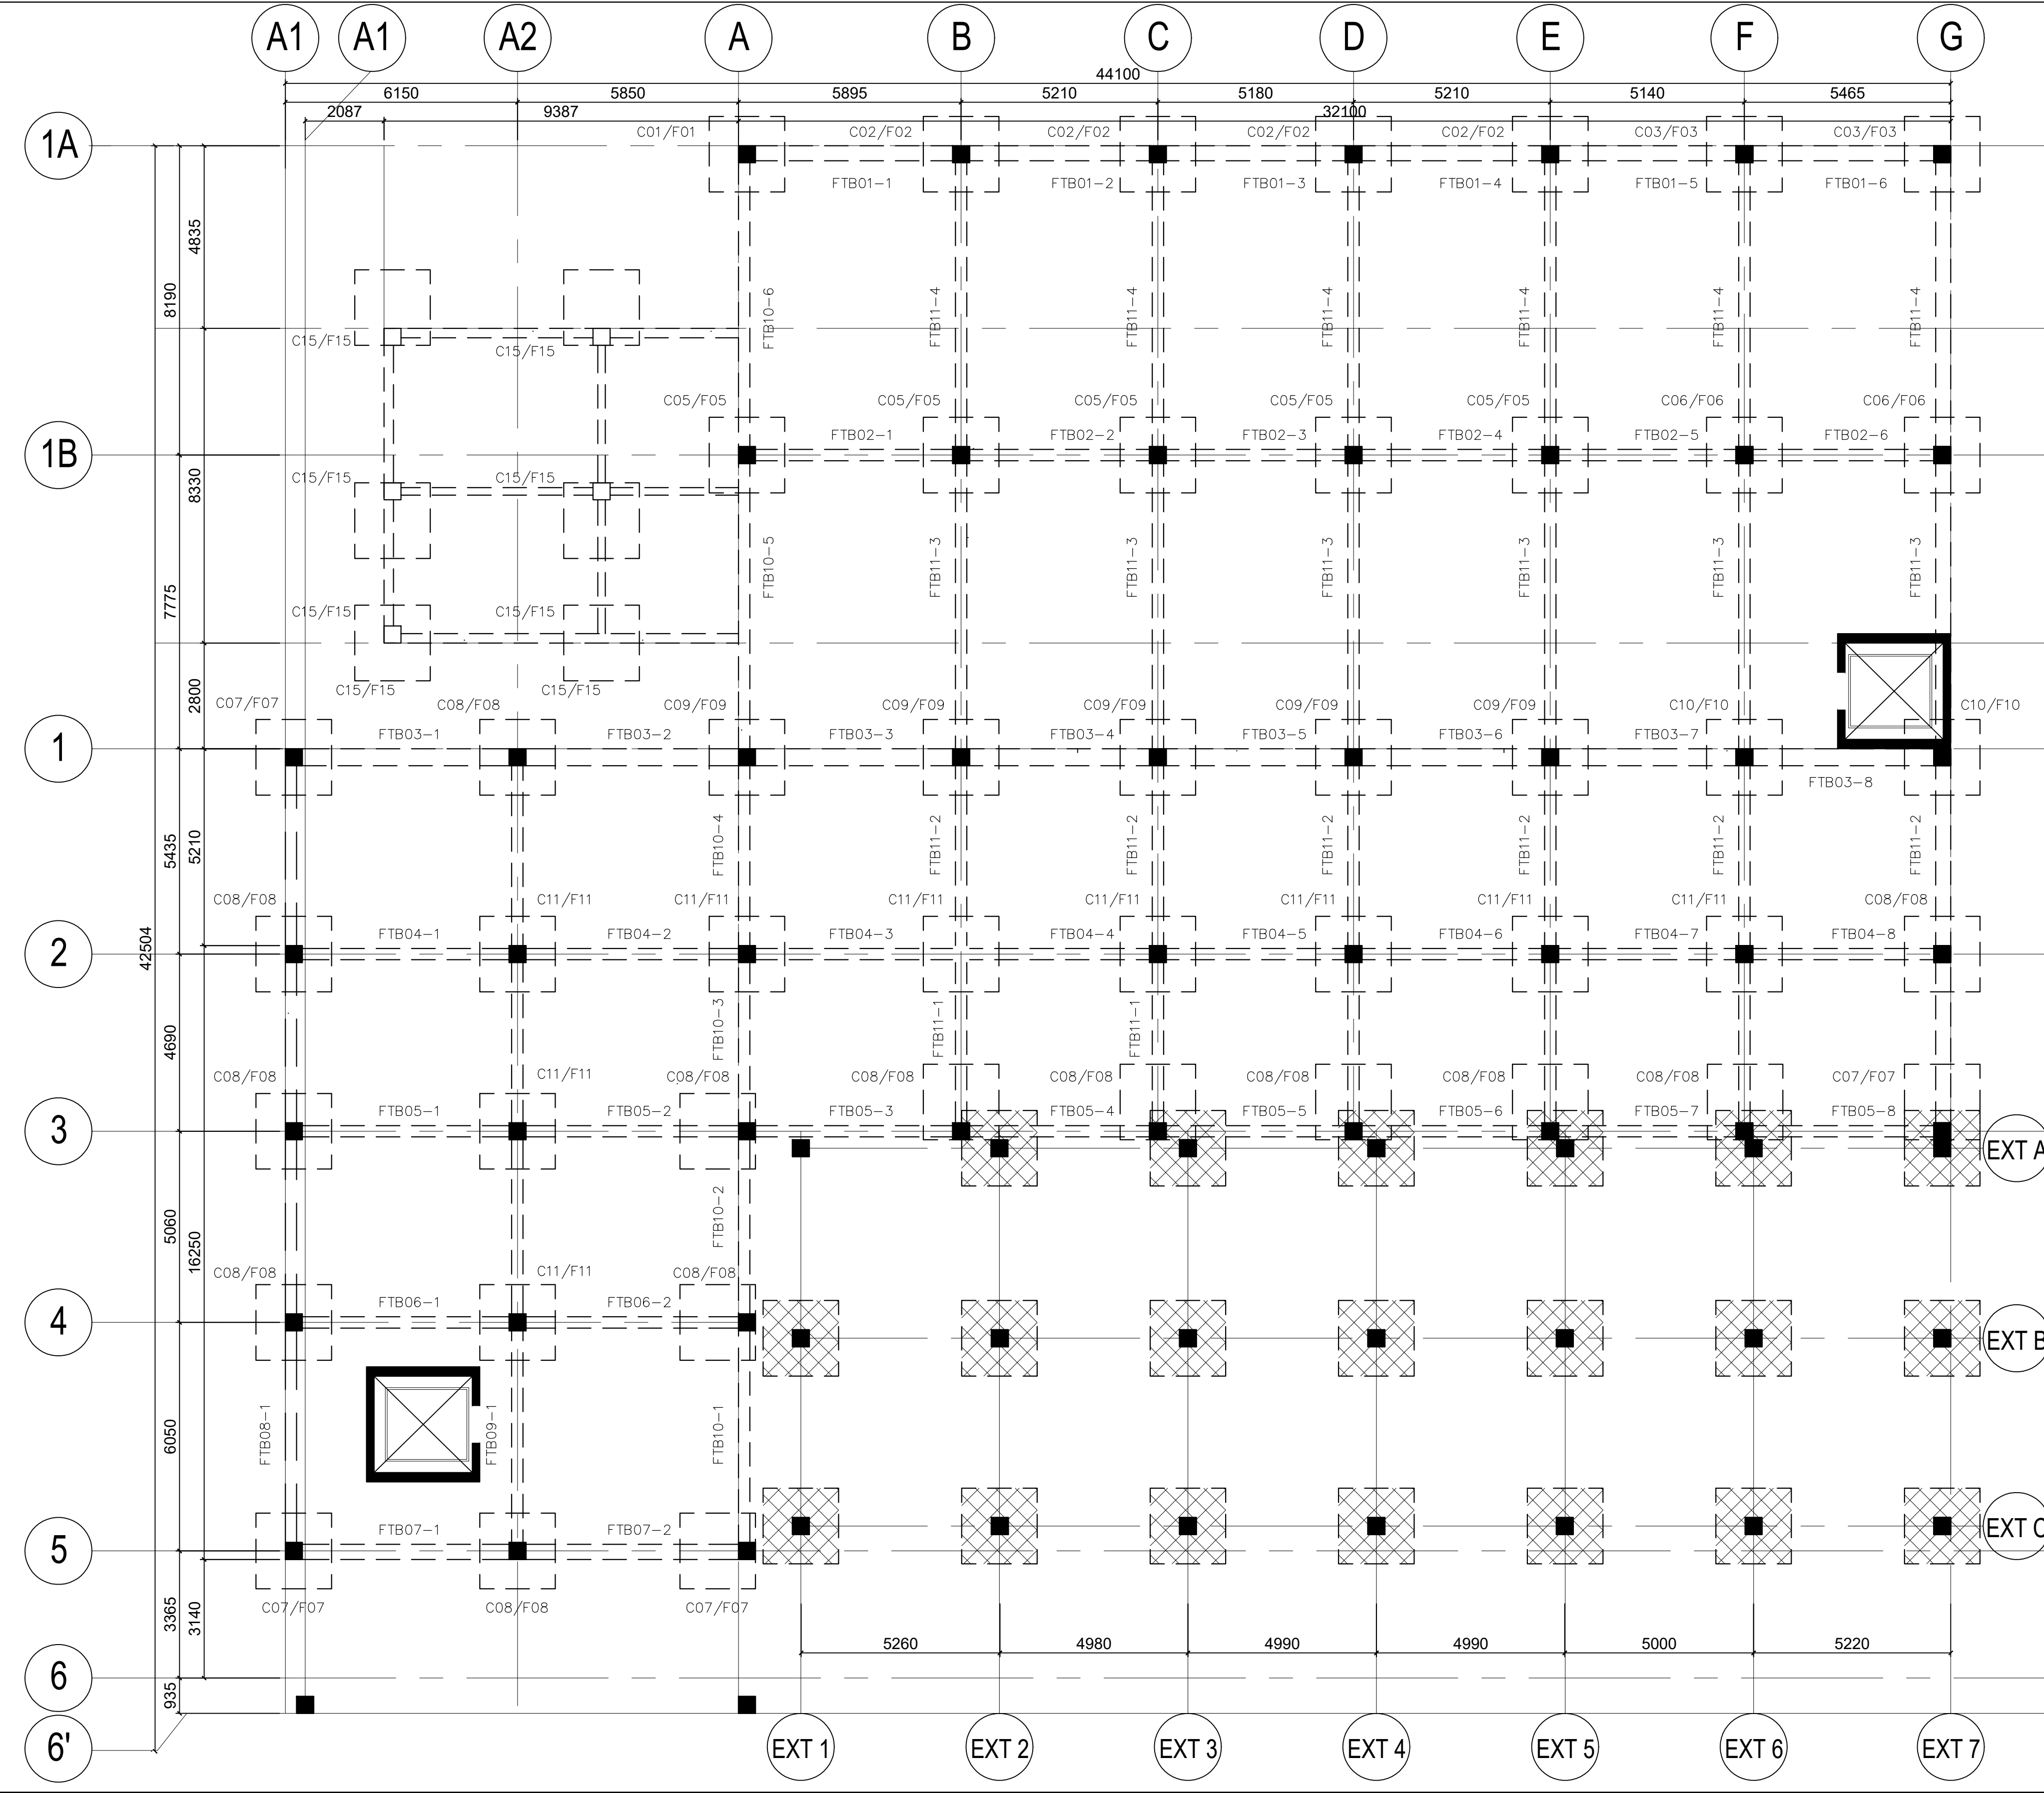
UPPER GROUND FLOORPLAN
REFLECTED CEILING PLAN

SHEET NUMBER

A

11


AS-BUILT



02 FOOTING DETAIL
S-01 SCALE NTS


01 FOUNDATION PLAN
S-01 SCALE 1:200M.

CONTRACTOR	
	
CIVIL ENGINEER	
EMMANUEL D. AGDA	
PRC REG. NO. 0114252	DATE: 01 / 09 / 19
PR. 7577945	PLACE: QUEZON CITY
OWNER	
	
PROJECT NAME	
EXPANSION AND EXTENSION RENOVATION OF THE EXISTING TSD FOR THE MODULAR MULTI-INDUSTRY INNOVATION CENTER AND EXECUTIVE OFFICES LOCATION: BICUTAN, TAGUIG	
APPROVED	
ANNABELLE V. BRIONES OIC-OFFICE OF THE DIRECTOR	
CONCURRED	
SHEET CONTENTS	
FOUNDATION PLAN	
SHEET NUMBER	
S	01
AS-BUILT	

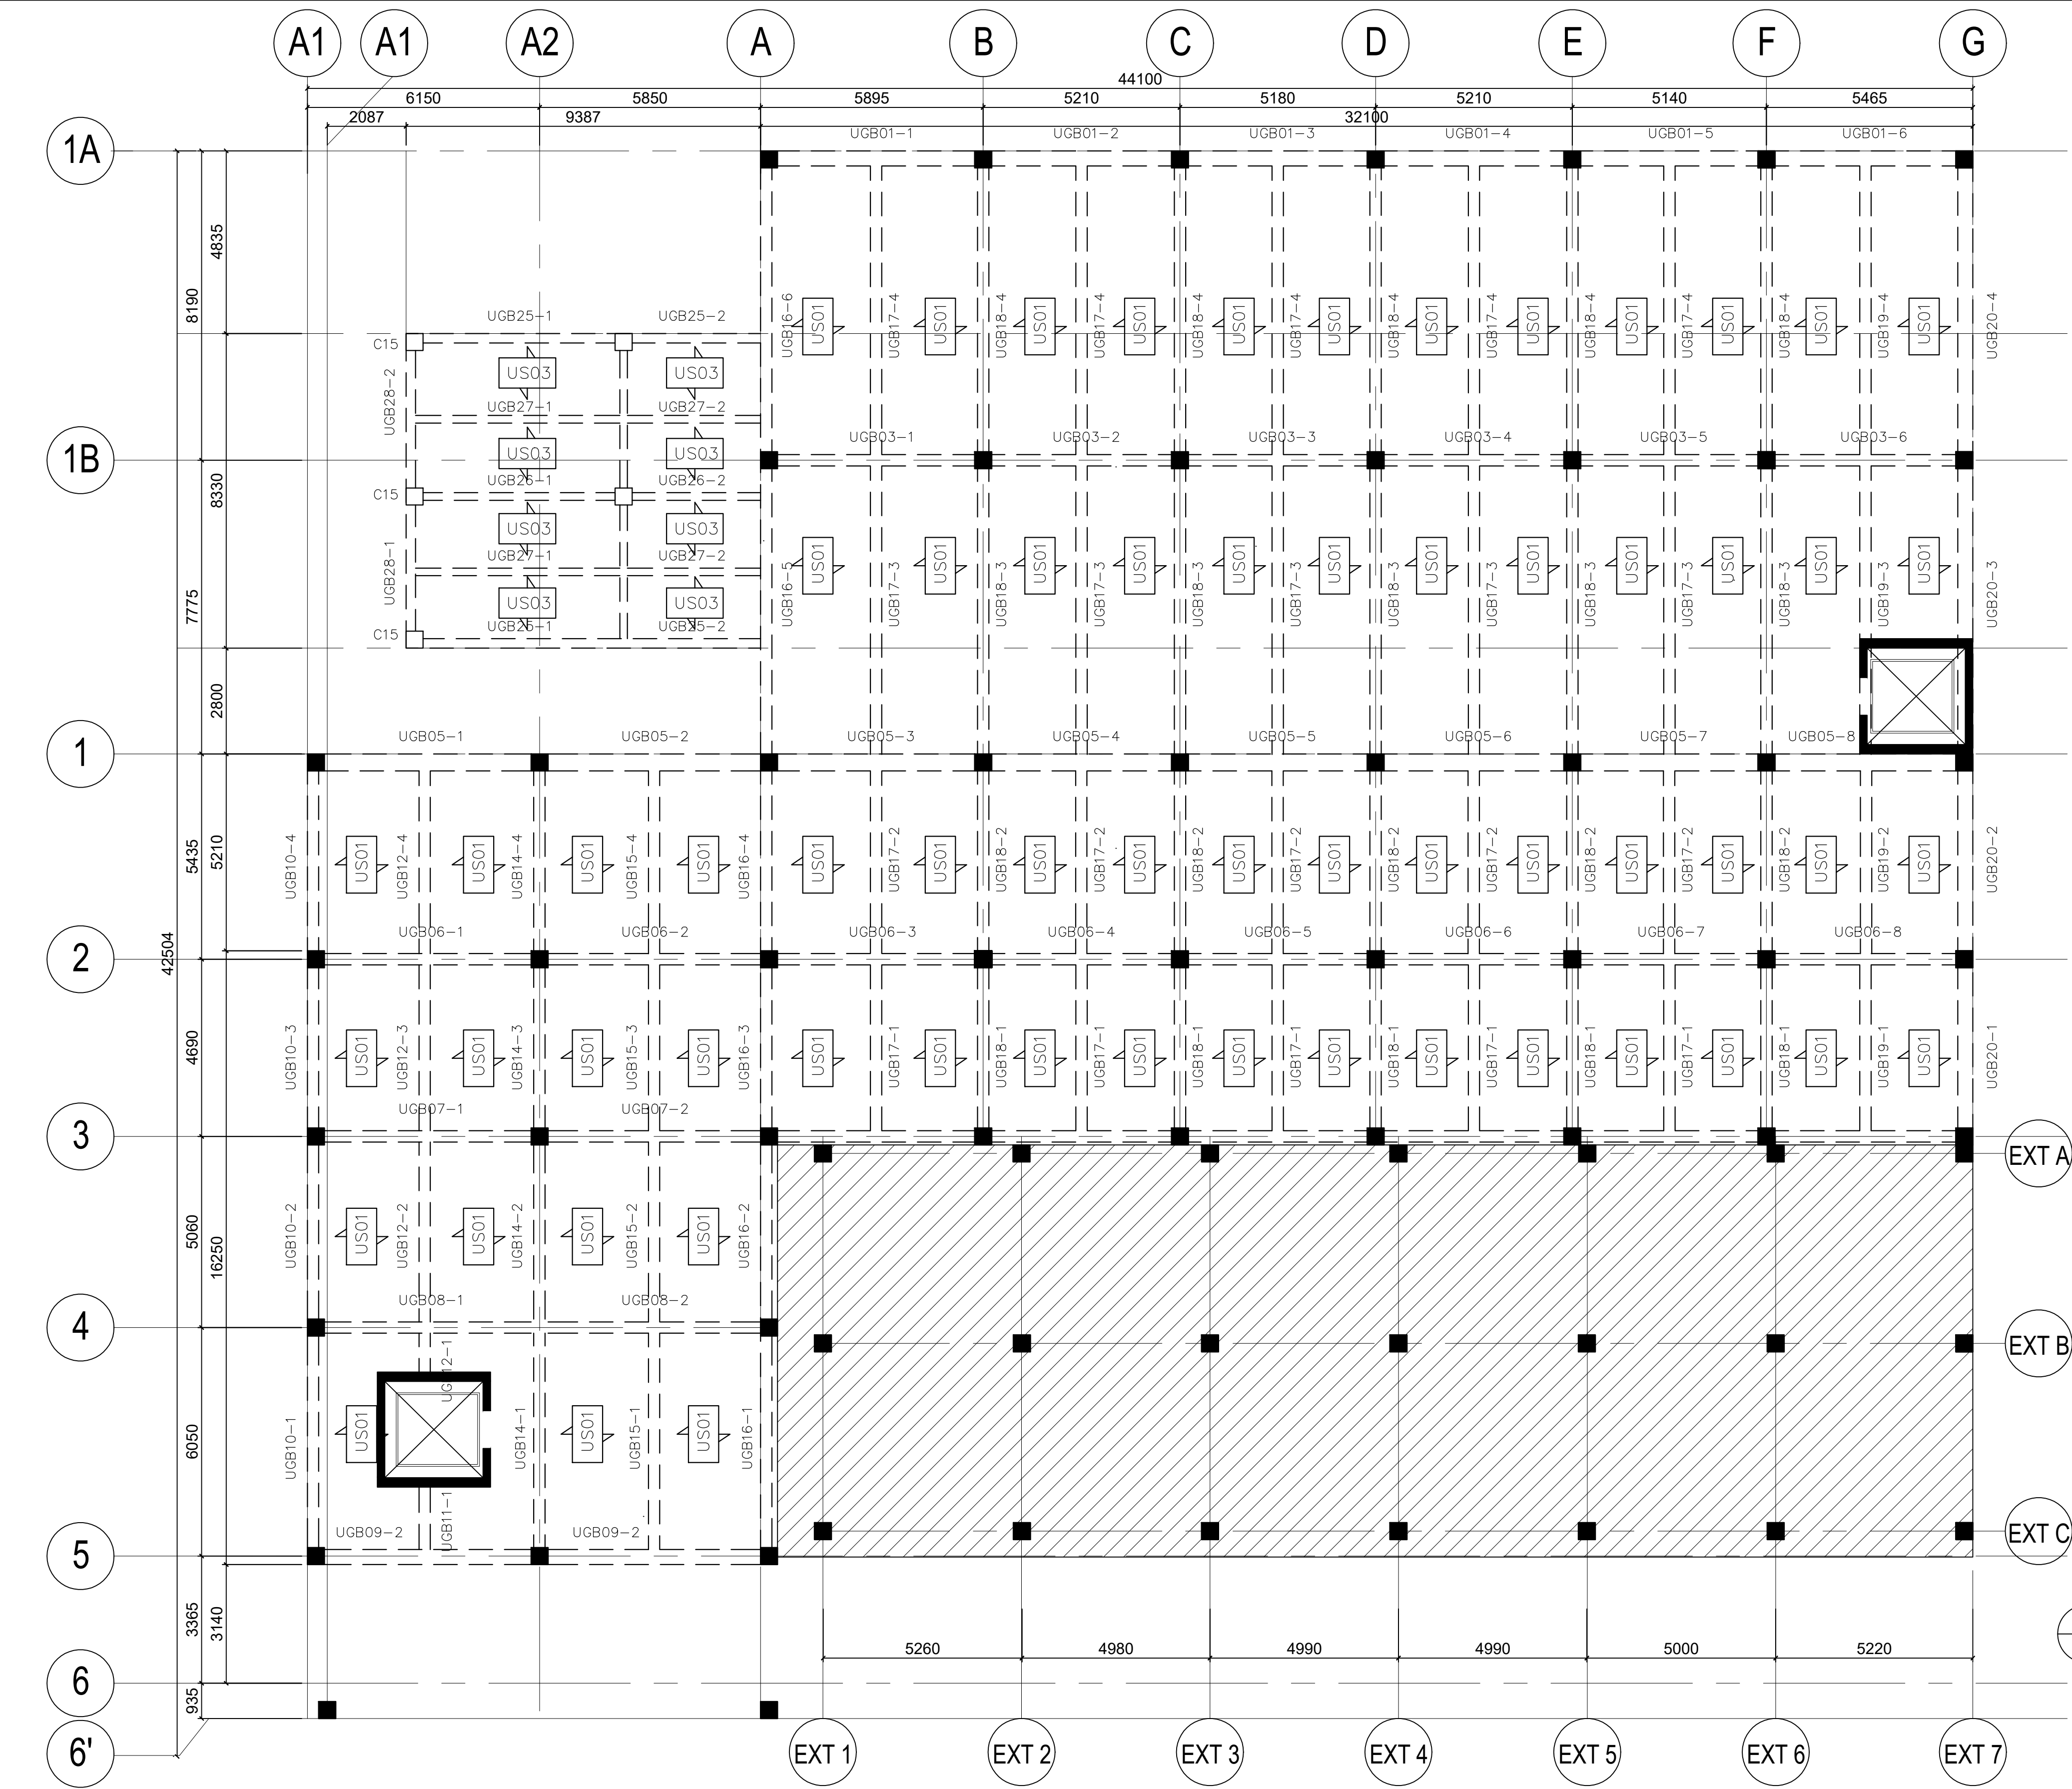

**UPPER GROUND
FLOOR FRAMING PLAN**
01
S-02 SCALE 1:200M.


CONTRACTOR	
	
CIVIL ENGINEER	
EMMANUEL D. AGDA	
PRC REG. NO. 0114252 DATE: 01 / 09 / 19 FIR: 7377945 TEL: 400-460-256 PLACE: QUEZON CITY	
OWNER	
	
PROJECT NAME	
EXPANSION AND EXTENSION RENOVATION OF THE EXISTING TSD FOR THE MODULAR MULTI-INDUSTRY INNOVATION CENTER AND EXECUTIVE OFFICES LOCATION: BICUTAN, TAGUIG	
APPROVED	
ANNABELLE V. BRIONES OIC-OFFICE OF THE DIRECTOR	
CONCURRED	
SHEET CONTENTS	
UPPER GROUND FLOOR FRAMING PLAN	
SHEET NUMBER	
S	02
AS-BUILT	

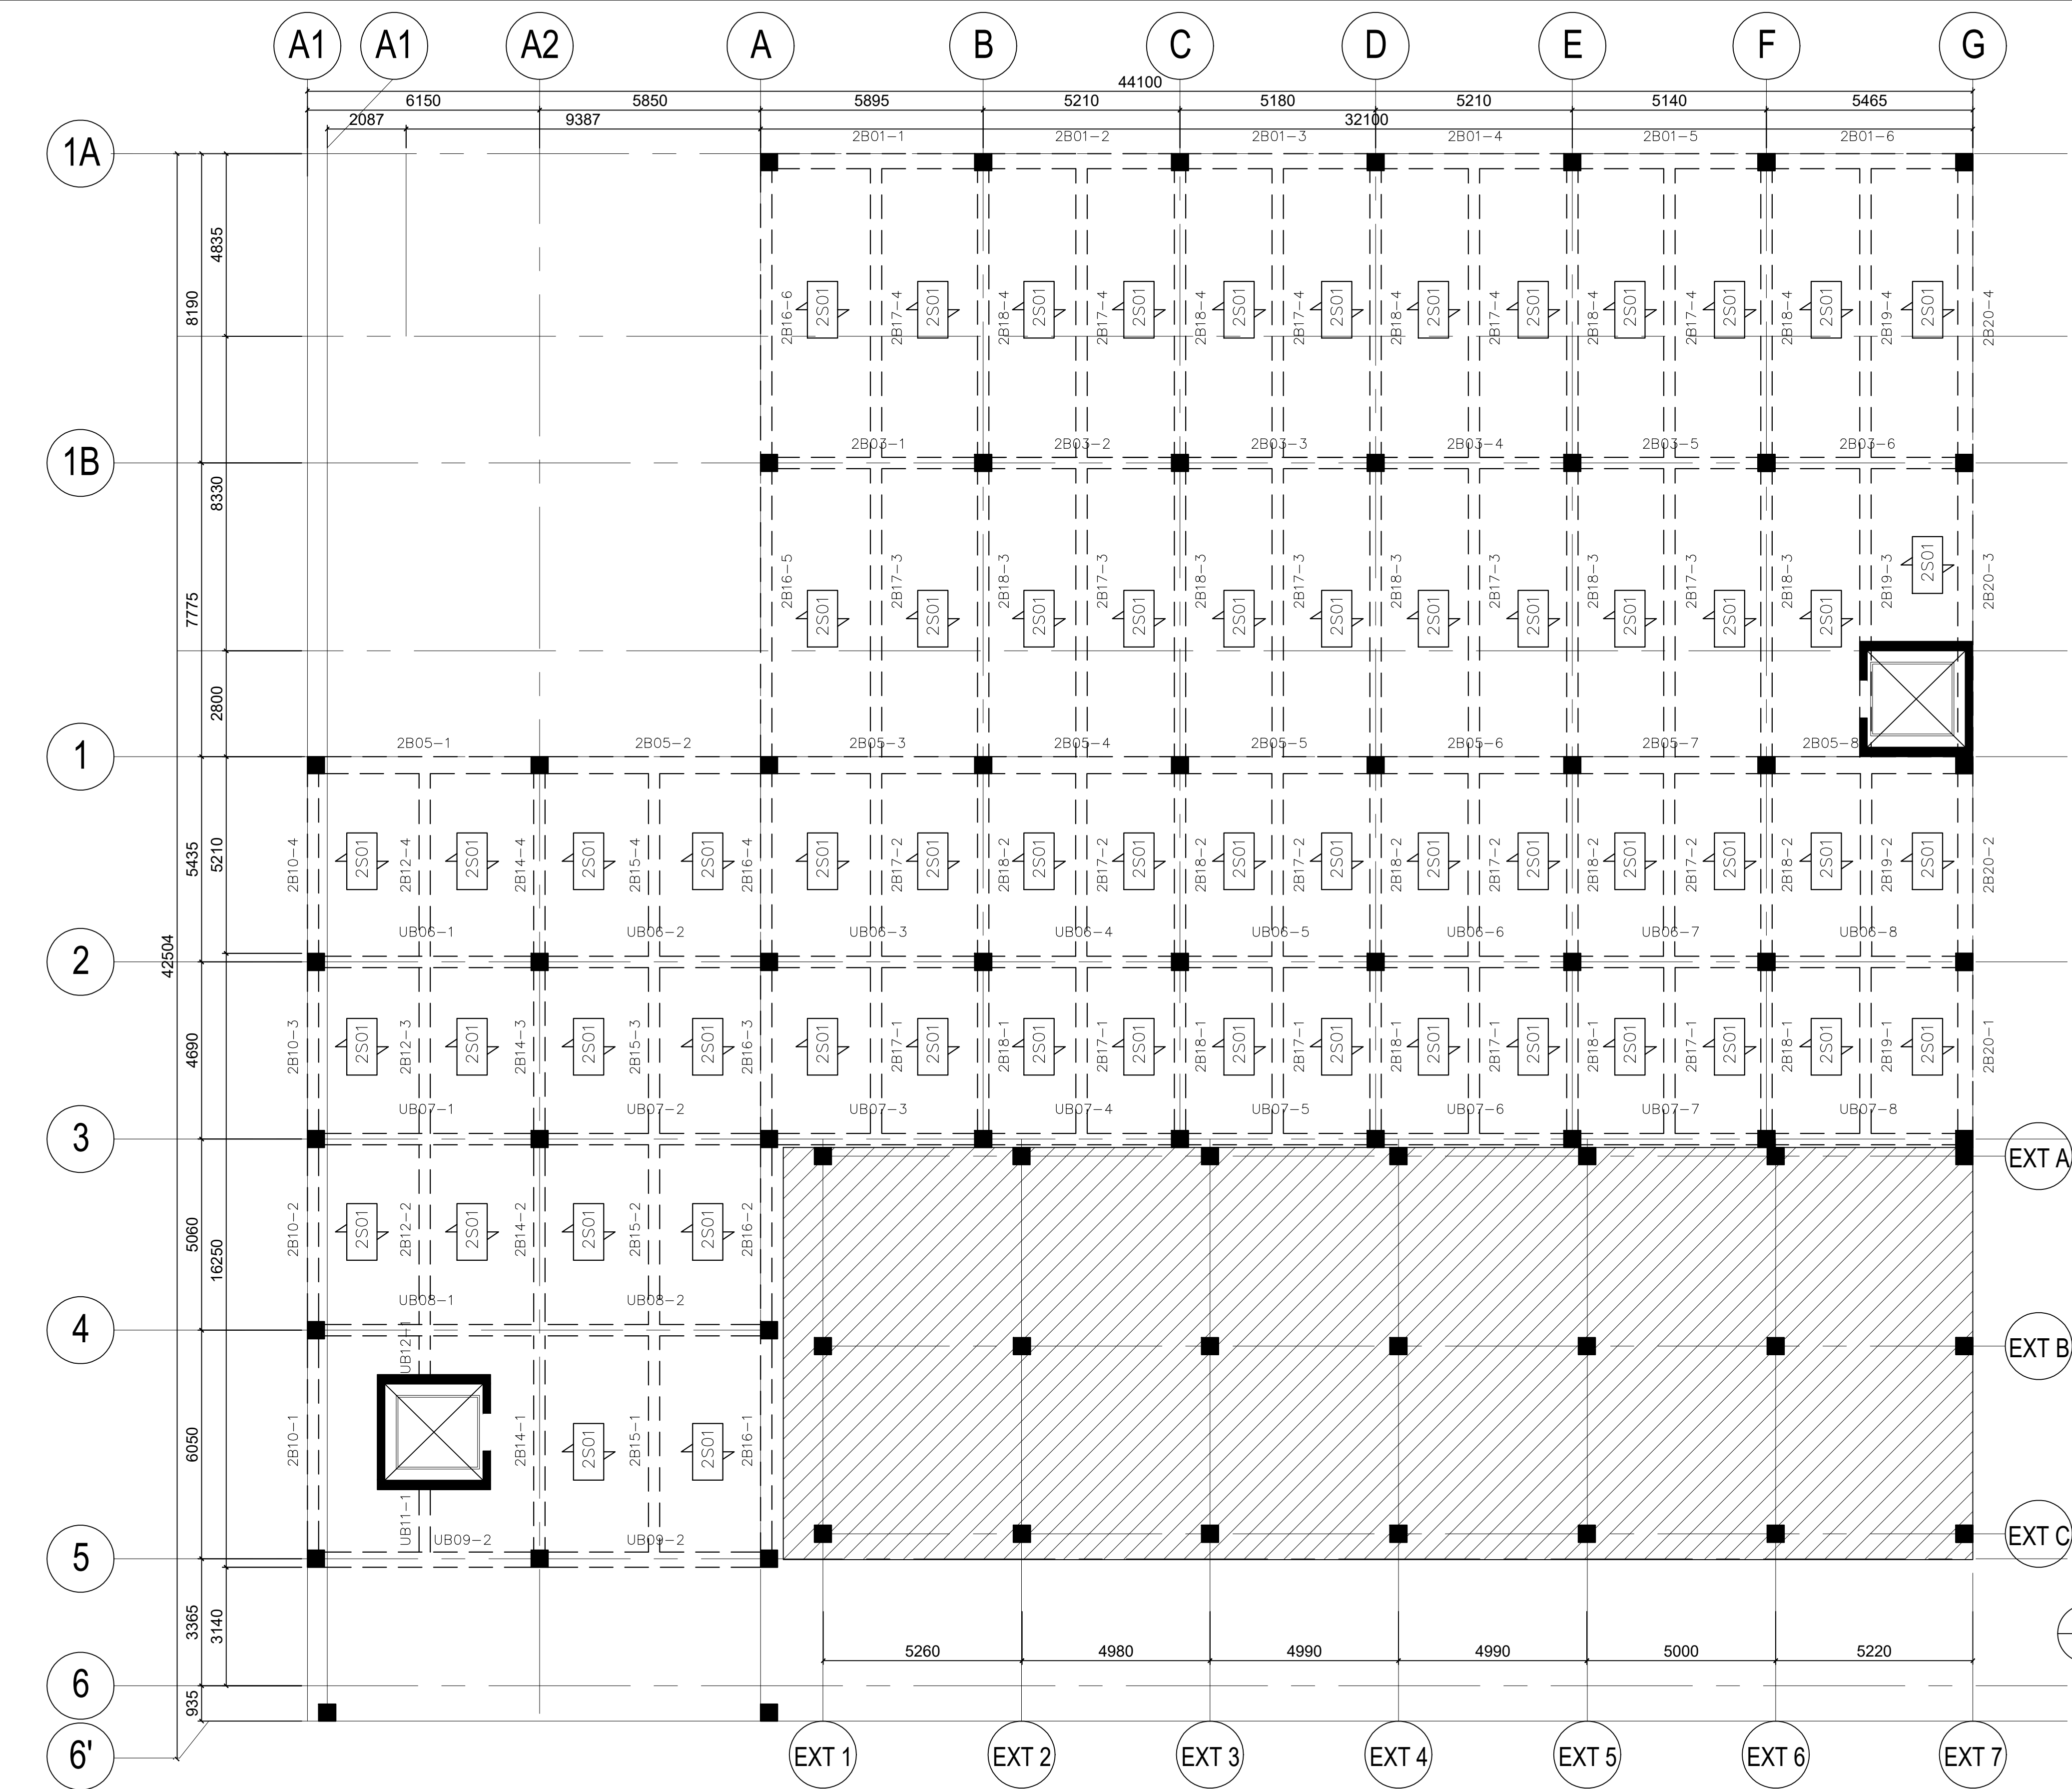

01
S-2.1 SCALE 1:200M.

SECOND FLOOR
FRAMING PLAN


CONTRACTOR	
	
CIVIL ENGINEER	
EMMANUEL D. AGDA	
PROJECT NAME	
EXPANSION AND EXTENSION RENOVATION OF THE EXISTING TSD FOR THE MODULAR MULTI-INDUSTRY INNOVATION CENTER AND EXECUTIVE OFFICES LOCATION: BICUTAN, TAGUIG	
APPROVED	
ANNABELLE V. BRIONES OIC-OFFICE OF THE DIRECTOR	
CONCURRED	
SHEET CONTENTS	
SECOND FLOOR FRAMING PLAN	
SHEET NUMBER	
S	2.1
AS-BUILT	

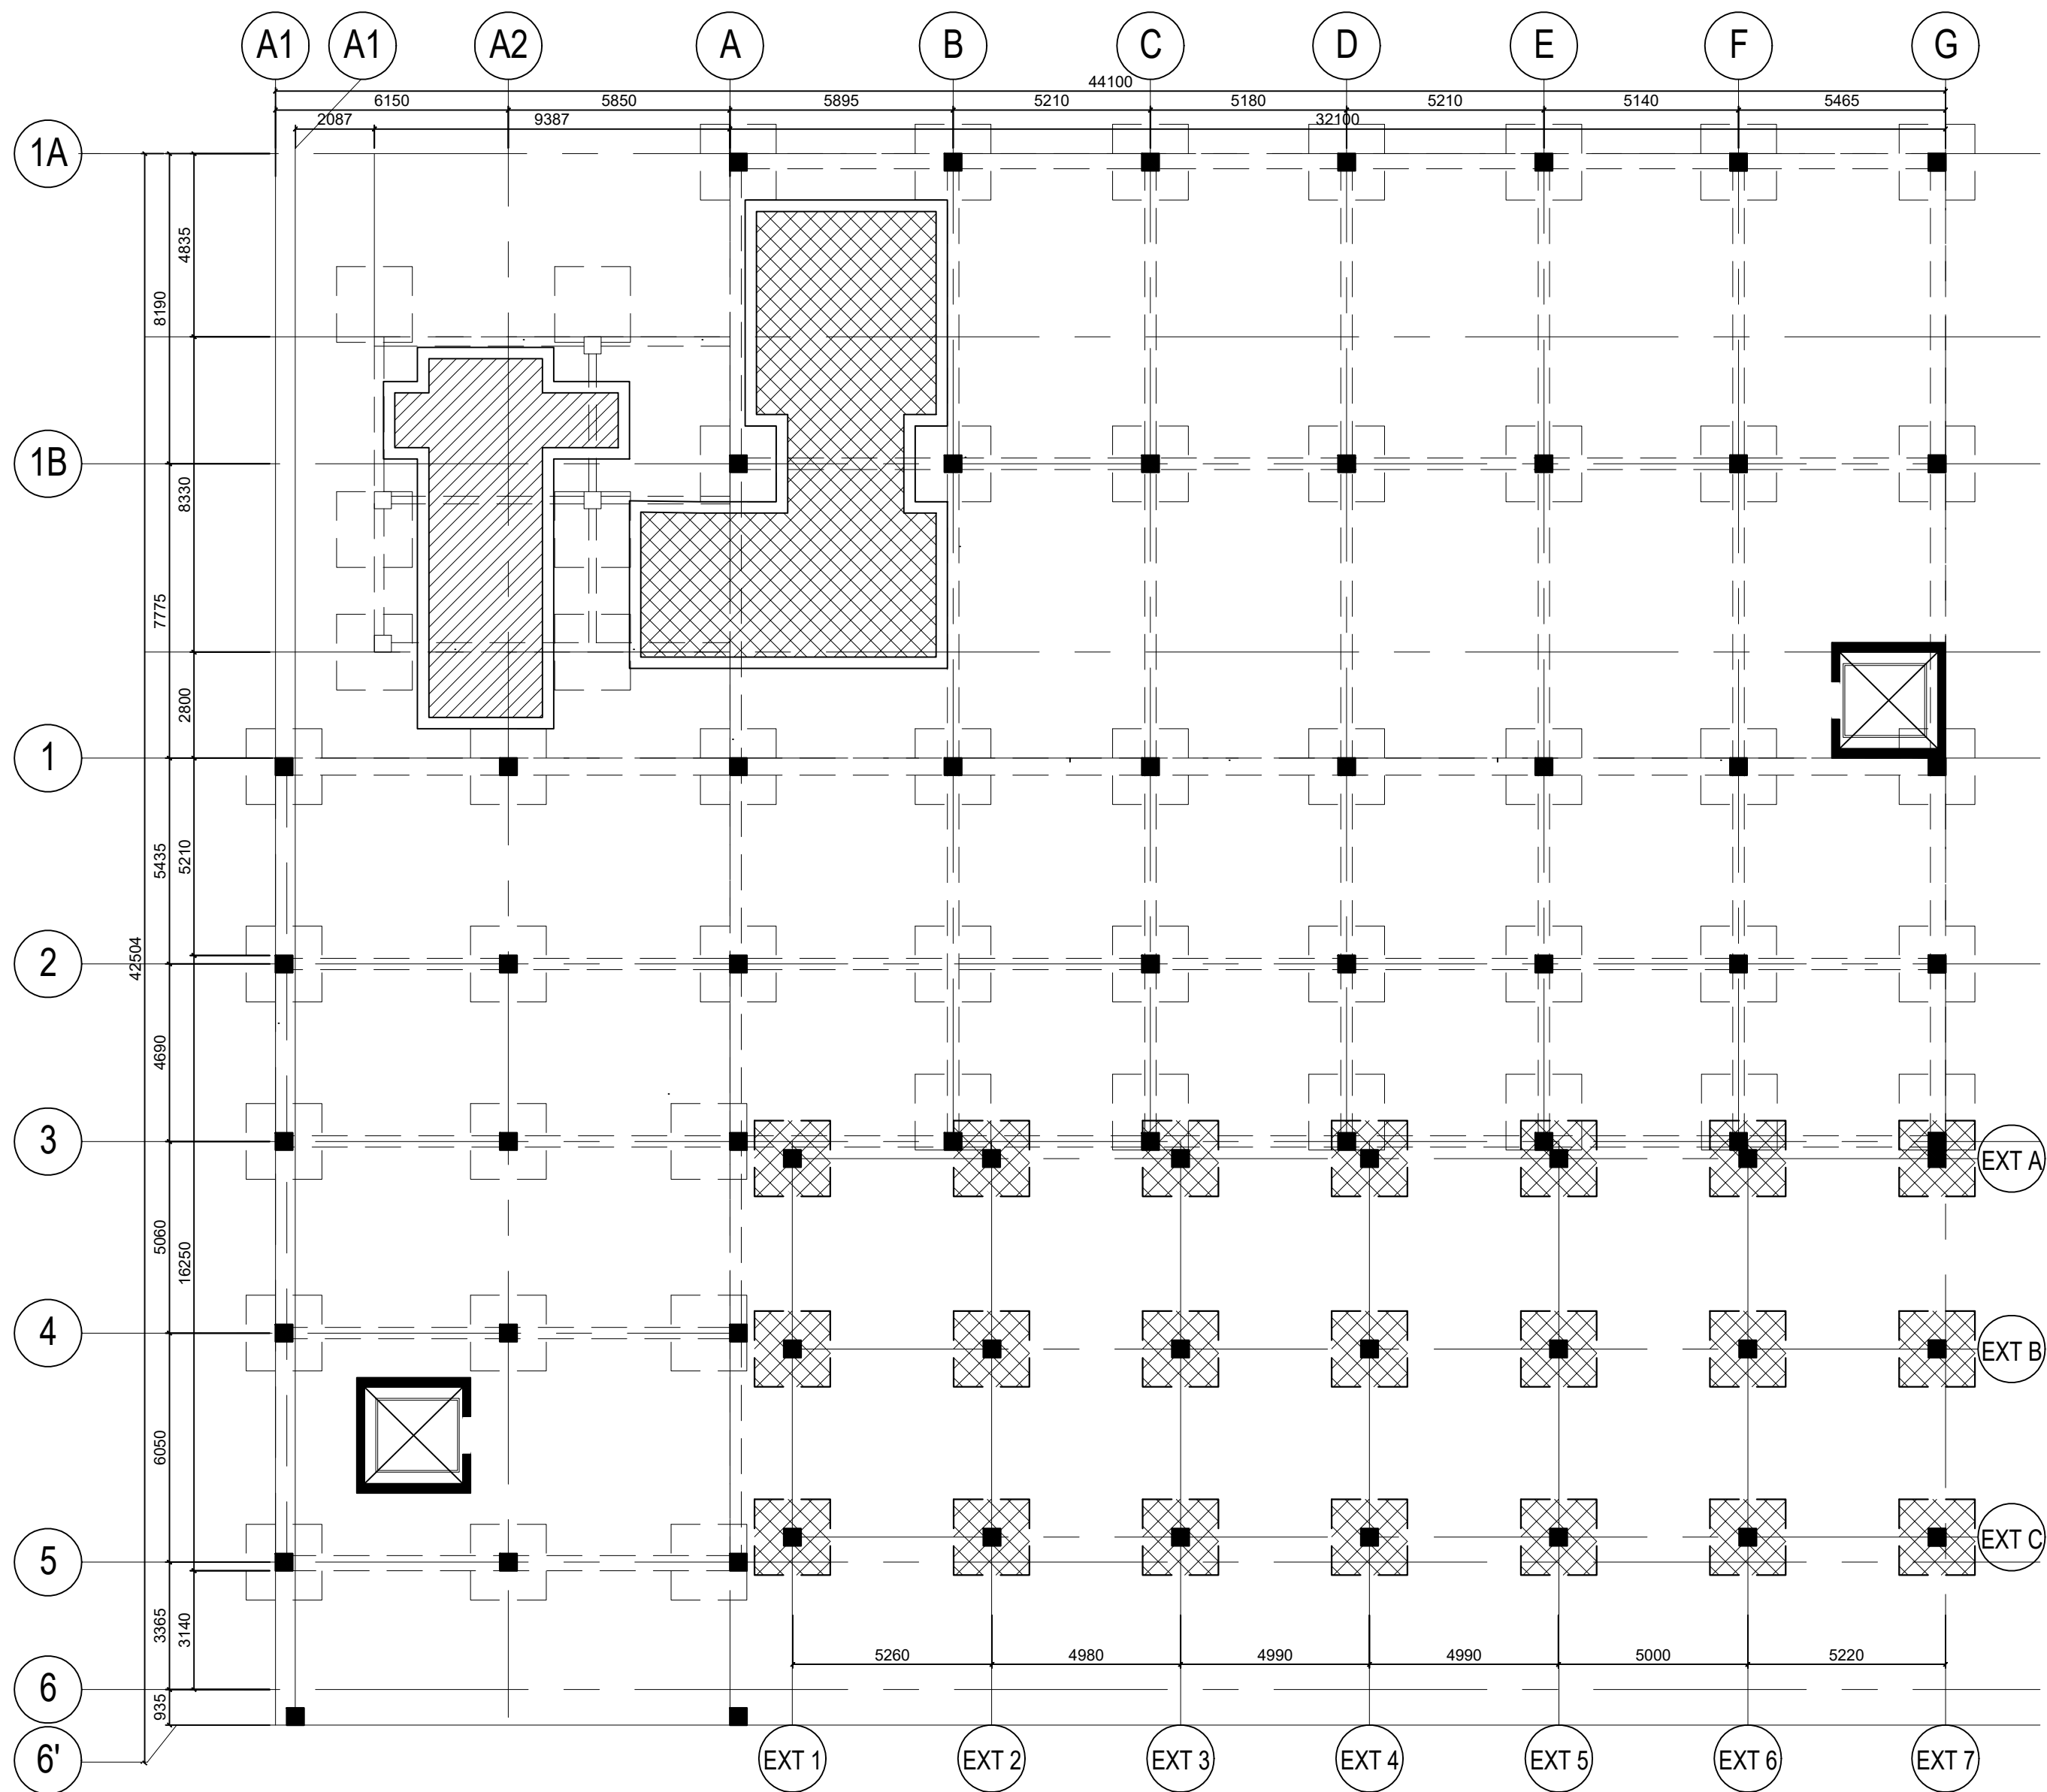




01 LOCATION OF DOMESTIC WATER TANK AND FIRE STORAGE TANK
S-03 SCALE 1:300 M.

DOMESTIC WATER TANK
LOCATION (61.83 cu.m;
32.63 sq.m)

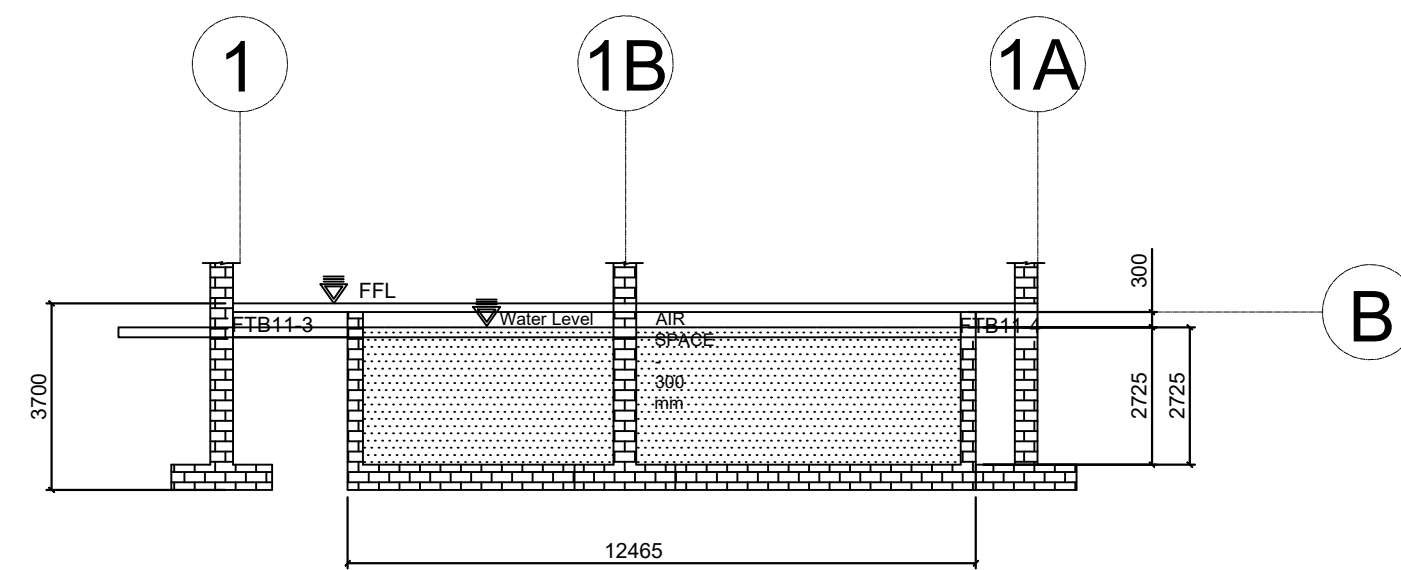
FIRE STORAGE TANK
LOCATION (172.26 cu.m;
63.10 sq.m)



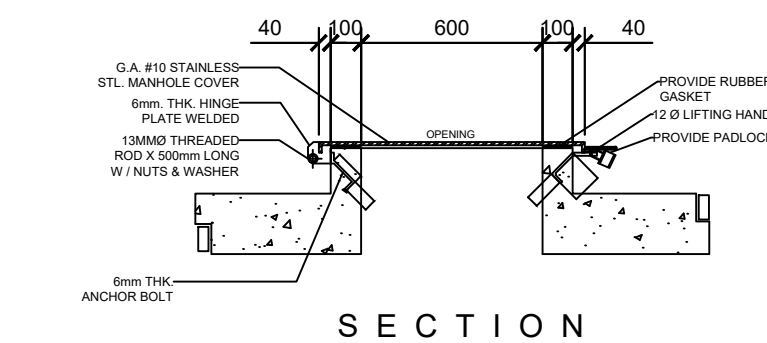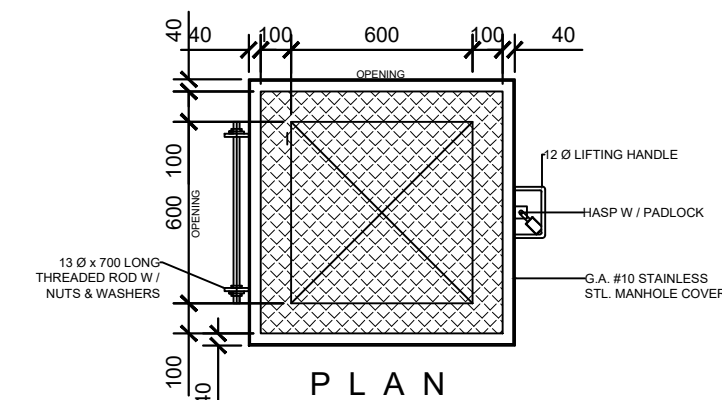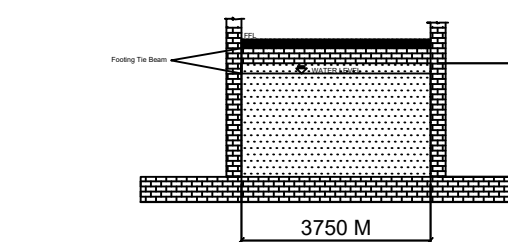
02 DOMESTIC WATERTANK AND
FIRE STORAGE TANK SECTION DETAIL
S-03 SCALE 1:300 M.



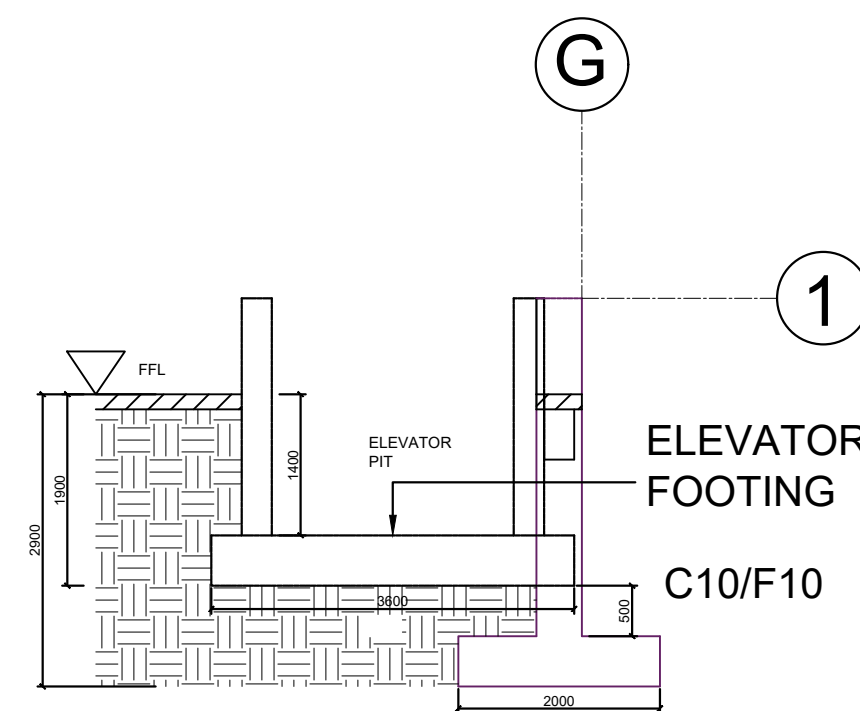03 MANHOLE COVER DETAIL
S-03 SCALE 1:50 M.



SECTION A-A

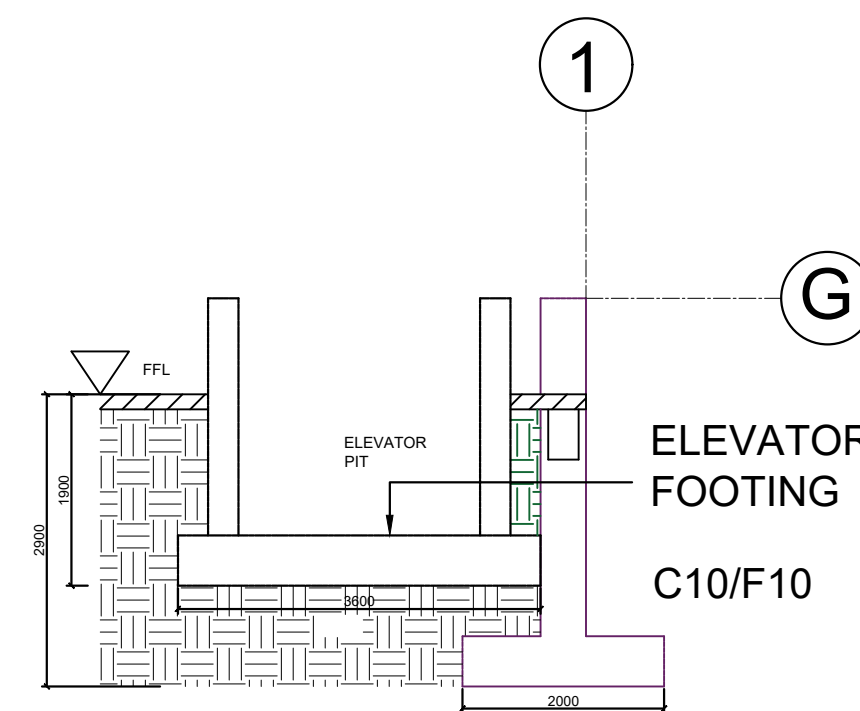

SECTION B-B

04 ELEVATOR PIT SECTION DETAIL
S-03 SCALE 1:150M.

CONTRACTOR	
	
CIVIL ENGINEER	
EMMANUEL D. AGDA	
PRC REG. NO. 0114252 FIR 7377945 TIN 400-460-256	DATE: 01 / 09 / 19 PLACE: QUEZON CITY
OWNER	
	
PROJECT NAME	
EXPANSION AND EXTENSION RENOVATION OF THE EXISTING TSD FOR THE MODULAR MULTI-INDUSTRY INNOVATION CENTER AND EXECUTIVE OFFICES LOCATION: BICUTAN, TAGUIG	
APPROVED	
ANNABELLE V. BRIONES OIC-OFFICE OF THE DIRECTOR	
CONCURRED	
SHEET CONTENTS	
LOCATION OF DOMESTIC WATER TANK AND FIRE STORAGE TANK DETAILS	
SHEET NUMBER	
S	03
AS-BUILT	

SCHEDULES OF GIRDERS / BEAMS

GIDERS	SPAN	b	h	DIA	END A				END B		STIRRUPS				REMARKS
BEAM		(mm)	(mm)	(mm)	TOP	BOTTOM	TOP	BOTTOM	TOP	BOTTOM	DIA	TYPE	SPACING		
UPPER ROOF LEVEL															
URB01-	1	300	600	20∅	5 = ³ / ₂	3	3	5 = ² / ₃	5 = ³ / ₂	3	10 ∅	A	1 @ 50 , REST100		
URB02-	1	300	600	20∅	5 = ³ / ₂	3	3	5 = ² / ₃	5 = ³ / ₂	3	10 ∅	A	1 @ 50 , REST100		
URB03-	1	300	600	20∅	5 = ³ / ₂	3	3	5 = ² / ₃	5 = ³ / ₂	3	10 ∅	A	1 @ 50 , 1 @ 100, REST150		
	2	300	600	20∅	5 = ³ / ₂	3	3	5 = ² / ₃	5 = ³ / ₂	3	10 ∅	A	1 @ 50 , 1 @ 100, REST150		
URB04-	1	300	600	20∅	5 = ³ / ₂	3	3	5 = ² / ₃	5 = ³ / ₂	3	10 ∅	A	1 @ 50 , 1 @ 100, REST150		
	2	300	600	20∅	5 = ³ / ₂	3	3	5 = ² / ₃	5 = ³ / ₂	3	10 ∅	A	1 @ 50 , 1 @ 100, REST150		

SCHEDULES OF FOOTING TIE BEAMS

GIDERS		SPAN	b	h	DIA	END A		MIDDLE		END B		STIRRUPS				REMARKS
BEAM			(mm)	(mm)	(mm)	TOP	BOTTOM	TOP	BOTTOM	TOP	BOTTOM	DIA	TYPE	SPACING		
FOOTING LEVEL																
FTB01-	ALL	300	500	20∅	3	3	3	3	3	3	10 ∅	A	1 @ 50 , REST	150		
FTB02-	ALL	300	500	20∅	3	3	3	3	3	3	10 ∅	A	1 @ 50 , REST	150		
FTB03-	ALL	300	500	20∅	3	3	3	3	3	3	10 ∅	A	1 @ 50 , REST	150		
FTB04-	ALL	300	500	20∅	3	3	3	3	3	3	10 ∅	A	1 @ 50 , REST	150		
FTB05-	ALL	300	500	20∅	3	3	3	3	3	3	10 ∅	A	1 @ 50 , REST	150		
FTB06-	ALL	300	500	20∅	3	3	3	3	3	3	10 ∅	A	1 @ 50 , REST	150		
FTB07-	ALL	300	500	20∅	3	3	3	3	3	3	10 ∅	A	1 @ 50 , REST	150		
FTB08-	ALL	300	500	20∅	3	3	3	3	3	3	10 ∅	A	1 @ 50 , REST	150		
FTB09-	ALL	300	500	20∅	3	3	3	3	3	3	10 ∅	A	1 @ 50 , REST	150		
FTB10-	ALL	300	500	20∅	3	3	3	3	3	3	10 ∅	A	1 @ 50 , REST	150		
FTB11-	ALL	300	500	20∅	3	3	3	3	3	3	10 ∅	A	1 @ 50 , REST	150		
FTB12-	ALL	300	500	20∅	3	3	3	3	3	3	10 ∅	A	1 @ 50 , REST	150		
FTB13-	ALL	300	500	20∅	3	3	3	3	3	3	10 ∅	A	1 @ 50 , REST	150		
FTB14-	ALL	300	500	20∅	3	3	3	3	3	3	10 ∅	A	1 @ 50 , REST	150		
FTB15-	ALL	300	500	20∅	3	3	3	3	3	3	10 ∅	A	1 @ 50 , REST	150		
FTB16-	ALL	300	500	20∅	3	3	3	3	3	3	10 ∅	A	1 @ 50 , REST	150		
FTB17-	ALL	300	500	20∅	3	3	3	3	3	3	10 ∅	A	1 @ 50 , REST	150		
FTB18-	ALL	300	500	20∅	3	3	3	3	3	3	10 ∅	A	1 @ 50 , REST	150		
FTB19-	ALL	300	500	20∅	3	3	3	3	3	3	10 ∅	A	1 @ 50 , REST	150		

SCHEDULES OF FOOTING

MARK	FOOTING EDIMENSIONS			FOOTING REINFORCEMENT SCHEDULE				REMARKS
	LENGTH WIDTH		THICKNESS	TOP BARS		BOTTOM BARS		
	A (mm)	B (mm)	t (mm)	'a' BARS	'b' BARS	'a' BARS	'b' BARS	
F01	2000	2000	500	—	—	14-∅ 16	14-∅ 16	
F02	2000	2000	500	—	—	14-∅ 16	14-∅ 16	
F03	2000	2000	500	—	—	14-∅ 16	14-∅ 16	
F04	2000	2000	500	—	—	14-∅ 16	14-∅ 16	
F05	2000	2000	500	—	—	14-∅ 16	14-∅ 16	
F06	2000	2000	500	—	—	14-∅ 16	14-∅ 16	
F07	2000	2000	500	—	—	14-∅ 16	14-∅ 16	
F08	2000	2000	500	—	—	14-∅ 16	14-∅ 16	
F09	2000	2000	500	—	—	14-∅ 16	14-∅ 16	
F10	2000	2000	500	—	—	14-∅ 16	14-∅ 16	
F11	2000	2000	500	—	—	14-∅ 16	14-∅ 16	
F12	3600	3600	500	24-∅ 16	24-∅ 16	24-∅ 16	24-∅ 16	COMBINE
F13	2000	2000	500	—	—	14-∅ 16	14-∅ 16	
F14	2000	2000	500	—	—	14-∅ 16	14-∅ 16	
F15	2000	2000	500	—	—	14-∅ 16	14-∅ 16	
F16	2000	2000	500	—	—	14-∅ 16	14-∅ 16	

CONTRACTOR



O C M STEEL CORPORATION
PHILIPPINE INDUSTRIAL DEVELOPMENT CORPORATION, INC. (PILINDCO) LTD.
TEL. NO. 465-4386 • 465-4388 FAX NO. 837-2724

CIVIL ENGINEER

EMMANUEL D. AGDA

PRC REG. NO.: 0114252
P.R. 7577945
TIN 400-460-256

DATE: 01 / 09 / 19
PLACE: QUEZON CITY

OWNER



DOST-ITDI

PROJECT NAME

EXPANSION AND EXTENSION
RENOVATION OF THE EXISTING TSD
FOR THE MODULAR MULTI-INDUSTRY
INNOVATION CENTER AND
EXECUTIVE OFFICES

LOCATION: BICUTAN, TAGUIG

APPROVED

ANNABELLE V. BRIONES
OIC-OFFICE OF THE DIRECTOR

CONCURRED

SHEET CONTENTS

SCHEDULES AS SHOWN

SHEET NUMBER

S04

AS-BUILT